


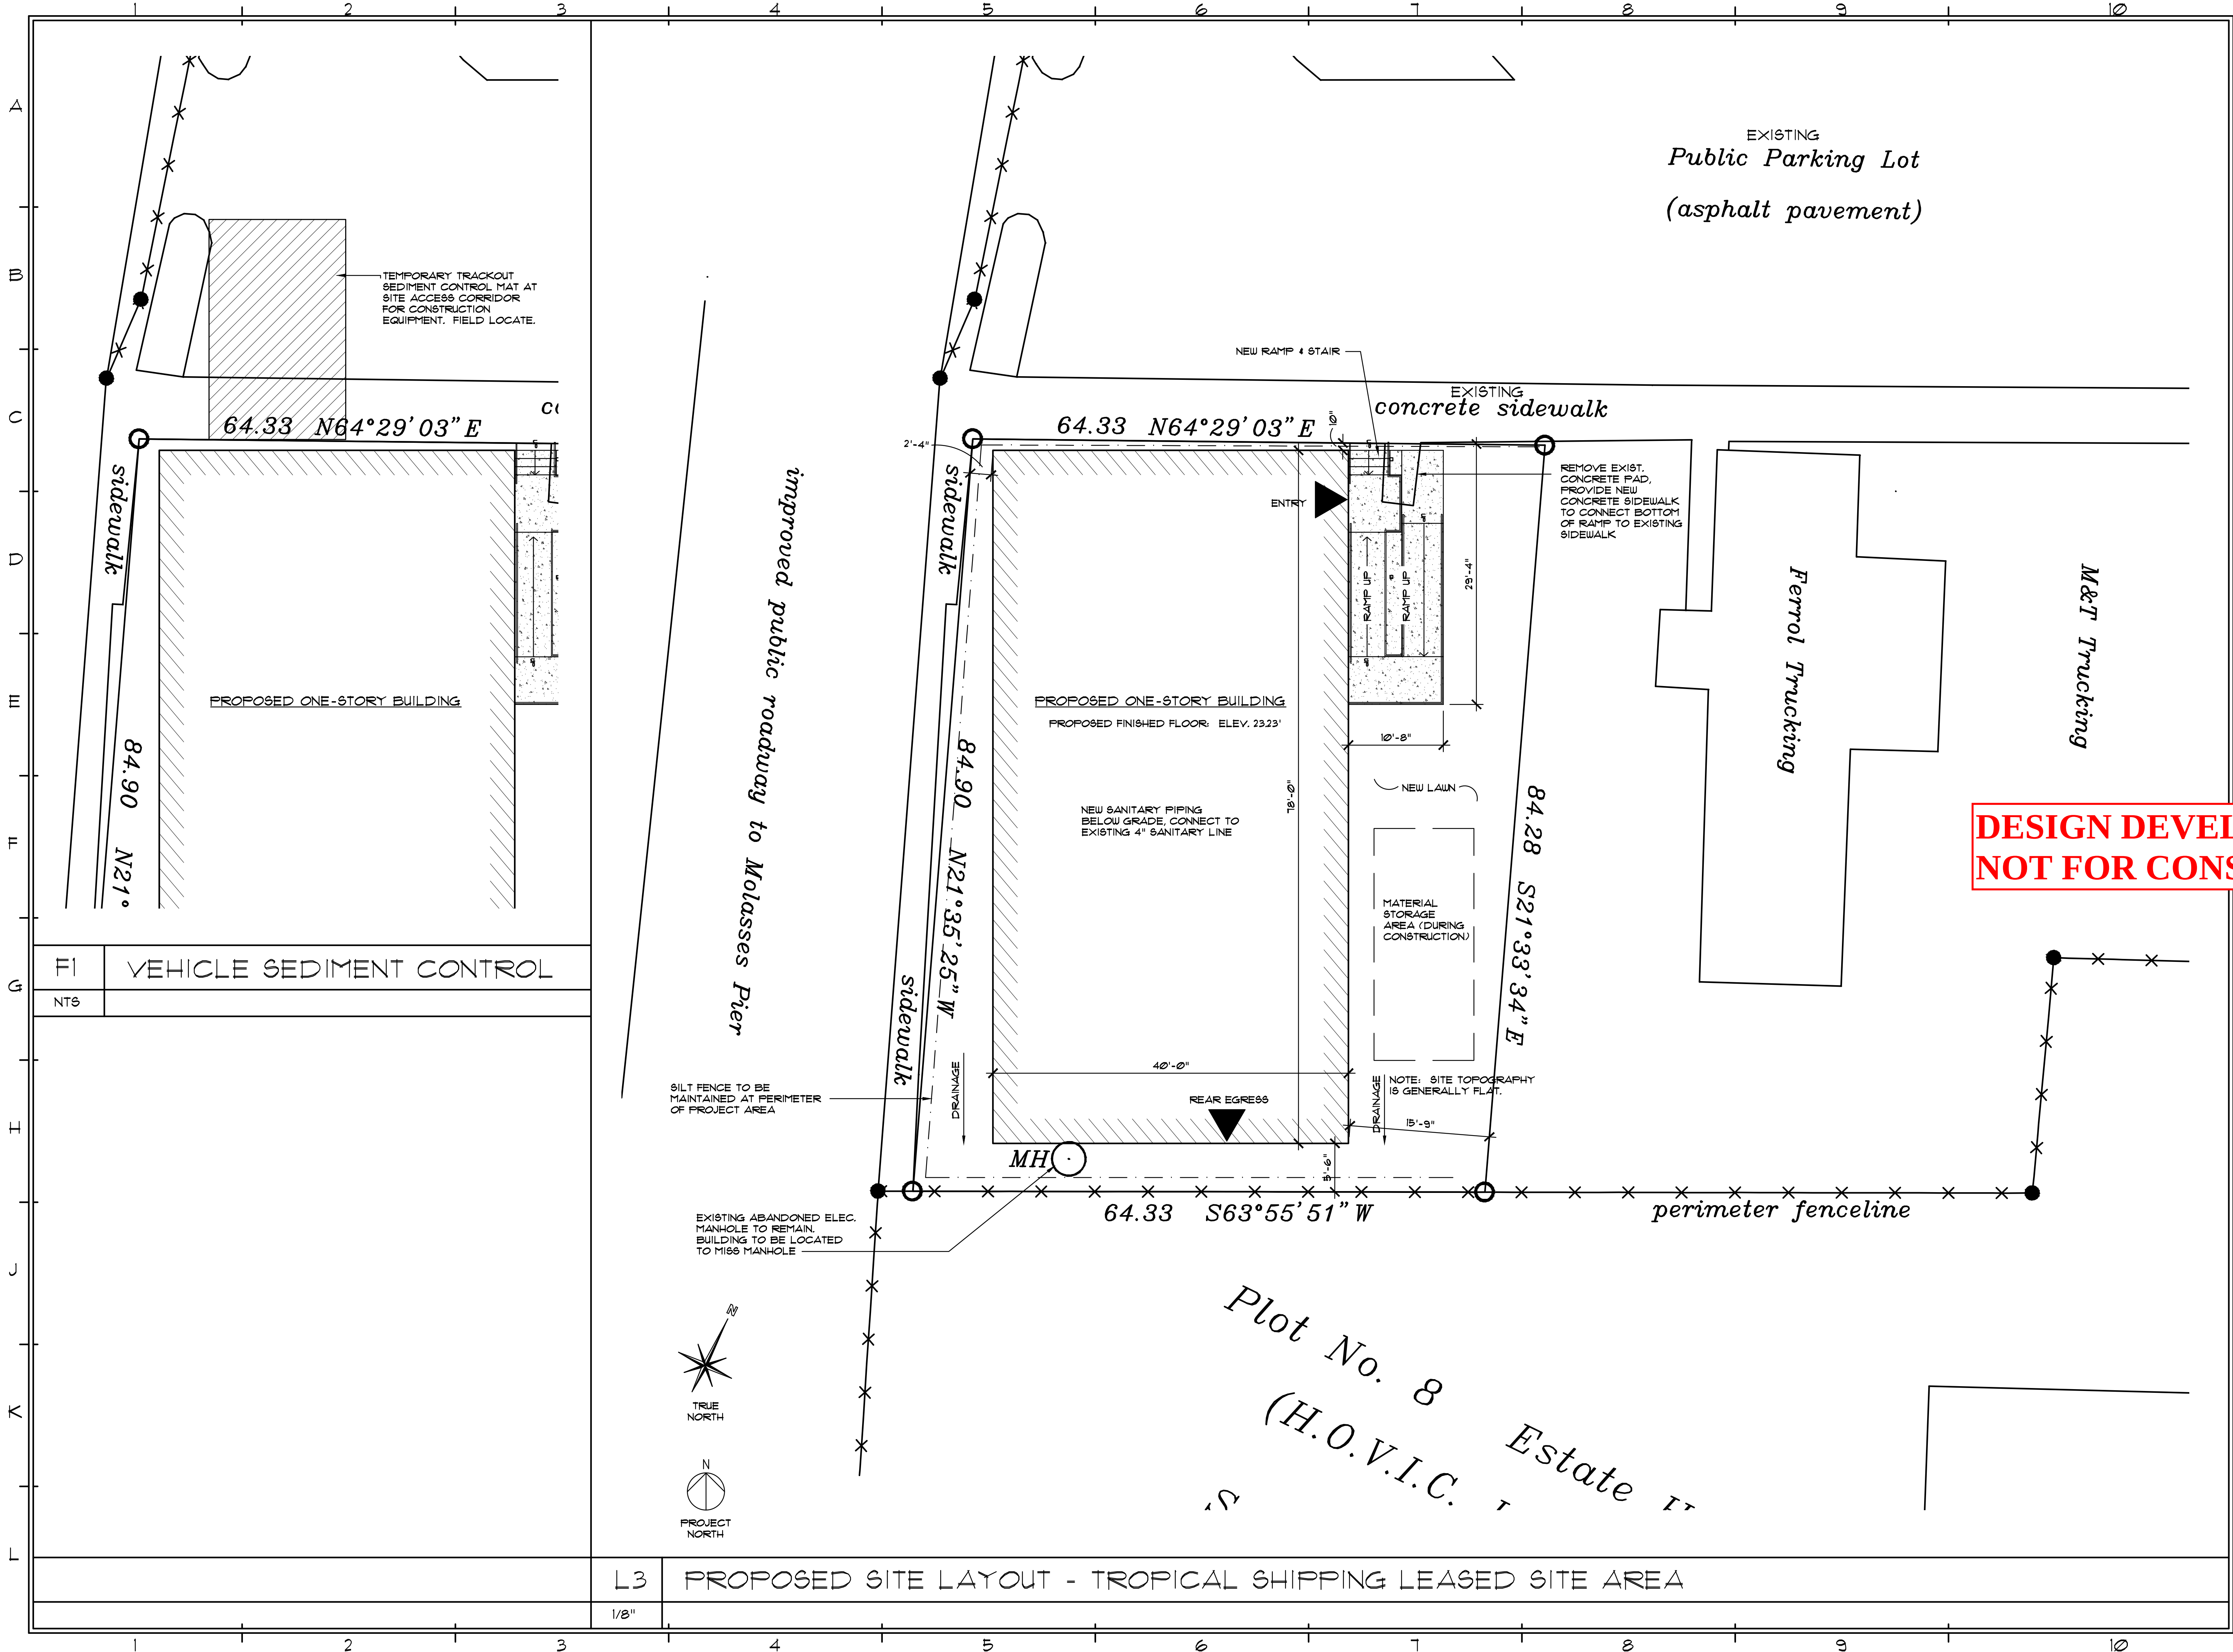

BENTON
CONSTRUCTION, LLC
3000 ORANGE GROVE, CHRISTIANSTED
ST. CROIX, U.S. VIRGIN ISLANDS 00602
PHONE: (340) 718-1222 FAX: (340) 718-4175
WEBSITE: WWW.BCVI.COM

ARCHITECT

SILVERBERG
ASSOCIATES V.I., P.C.
ARCHITECTS
55 COMPANY STREET, SUITE B, CHRISTIANSTED
ST. CROIX, USVI 00602
NU PHONE: (609) 521-8861 NU FAX: (609) 521-8826

MEP ENGINEER

T.J.D.
ENGINEERING ASSOCIATES, INC.
2 Hancock Drive, West Milford, N.J. 07480
Certificate of Authorization 24CA27944000
Phone 973-208-0054
Fax 973-208-0851

STRUCTURAL ENGINEER

HARRISON HAMNETT, P.C.
40 Knowles Street
Pennington, New Jersey 08534
Office (609) 818-1808
Fax (609) 818-1809

OWNER

Tropical
SHIPPING

PROFESSIONAL SEAL:

THIS DRAWING SHALL NOT BE USED FOR CONSTRUCTION UNLESS A PROFESSIONAL'S SEAL AND SIGNATURE ARE ON THE DRAWING

PROJECT TITLE / DESCRIPTION:
TROPICAL SHIPPING
NEW OFFICES

FACILITY LOCATION:
TROPICAL SHIPPING LLC.
(LEASED PLOT)

PLOT NO. 8
EAST HOPE (H.O.V.I.C. LANDS)
QUEEN'S QUARTER, ST. CROIX USVI

DATE:
5-28-24


NO.	REVISION:	DATE:


PROJECT NUMBER:
22254

DRAWING TITLE:
SITE LAYOUT


SHEET NUMBER:
C-2


SHEET OF

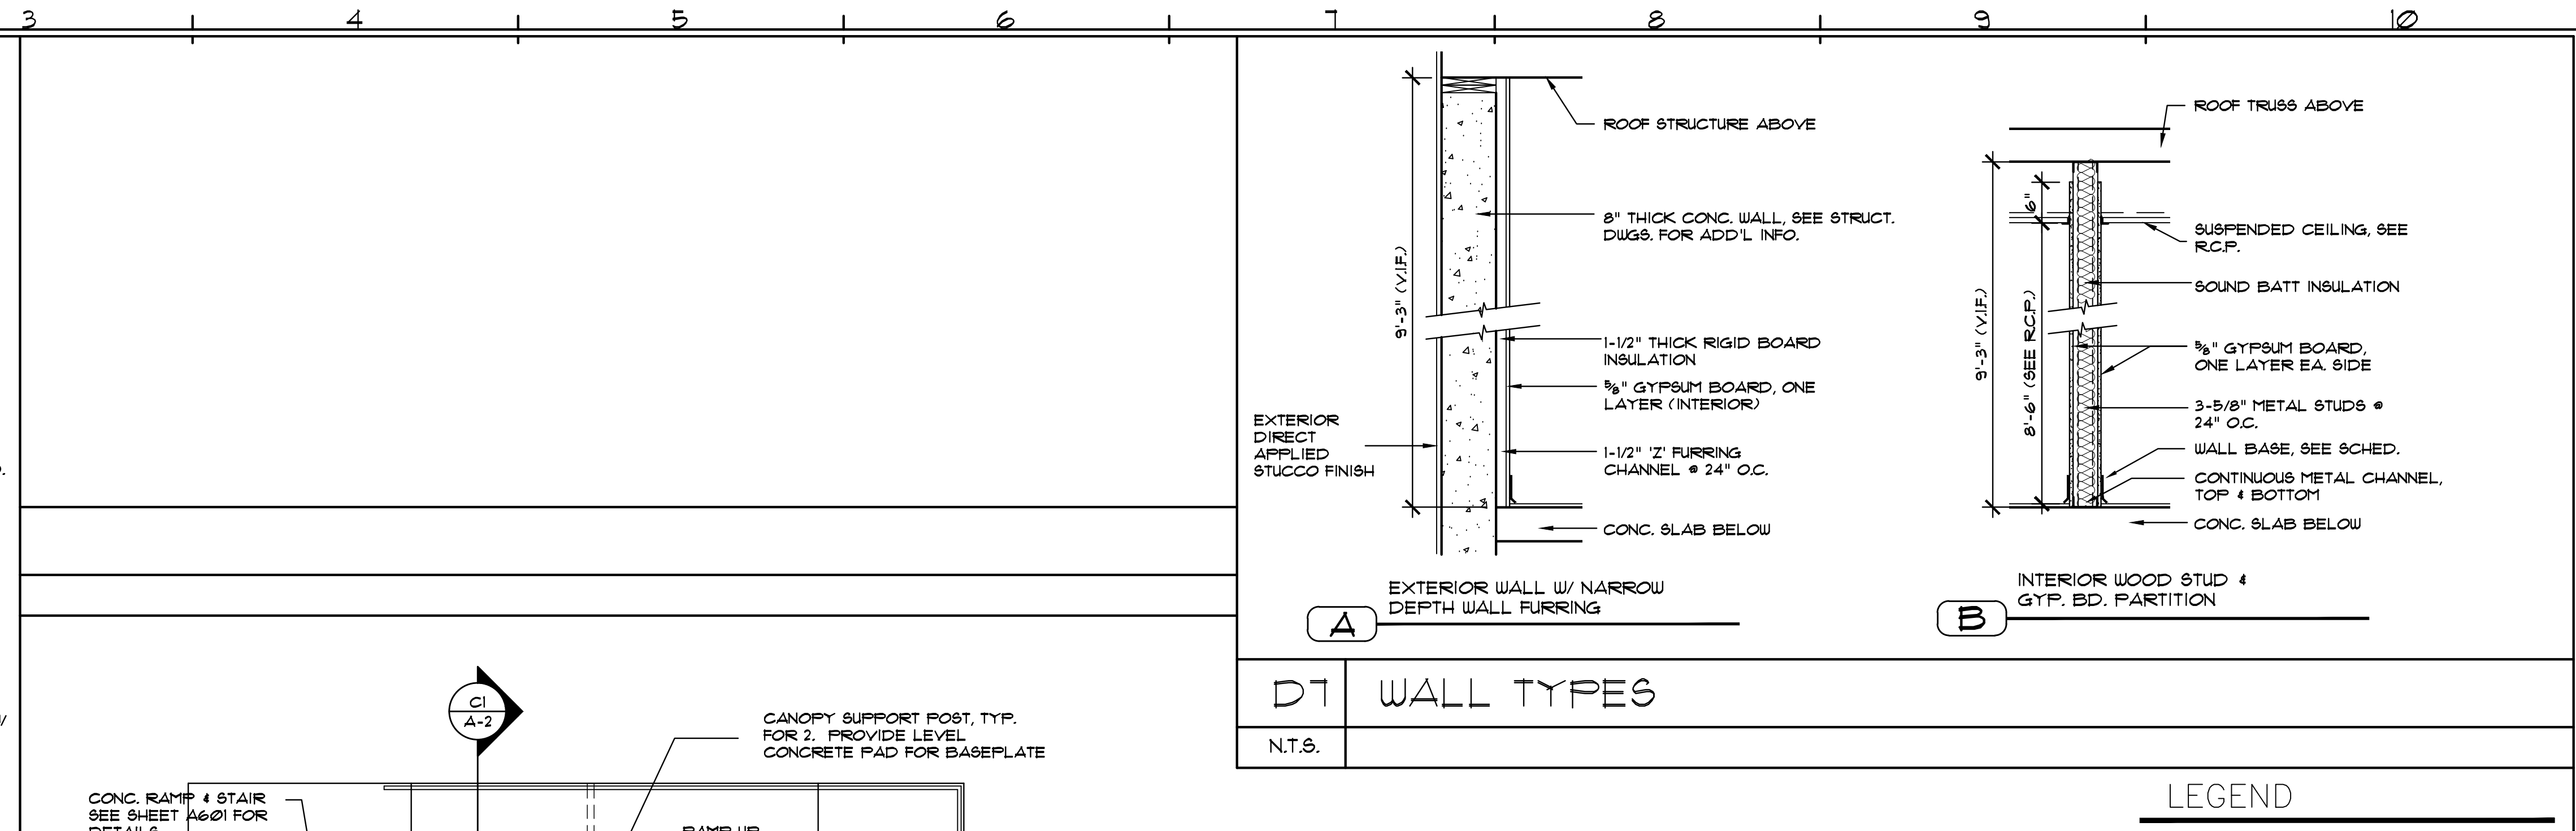


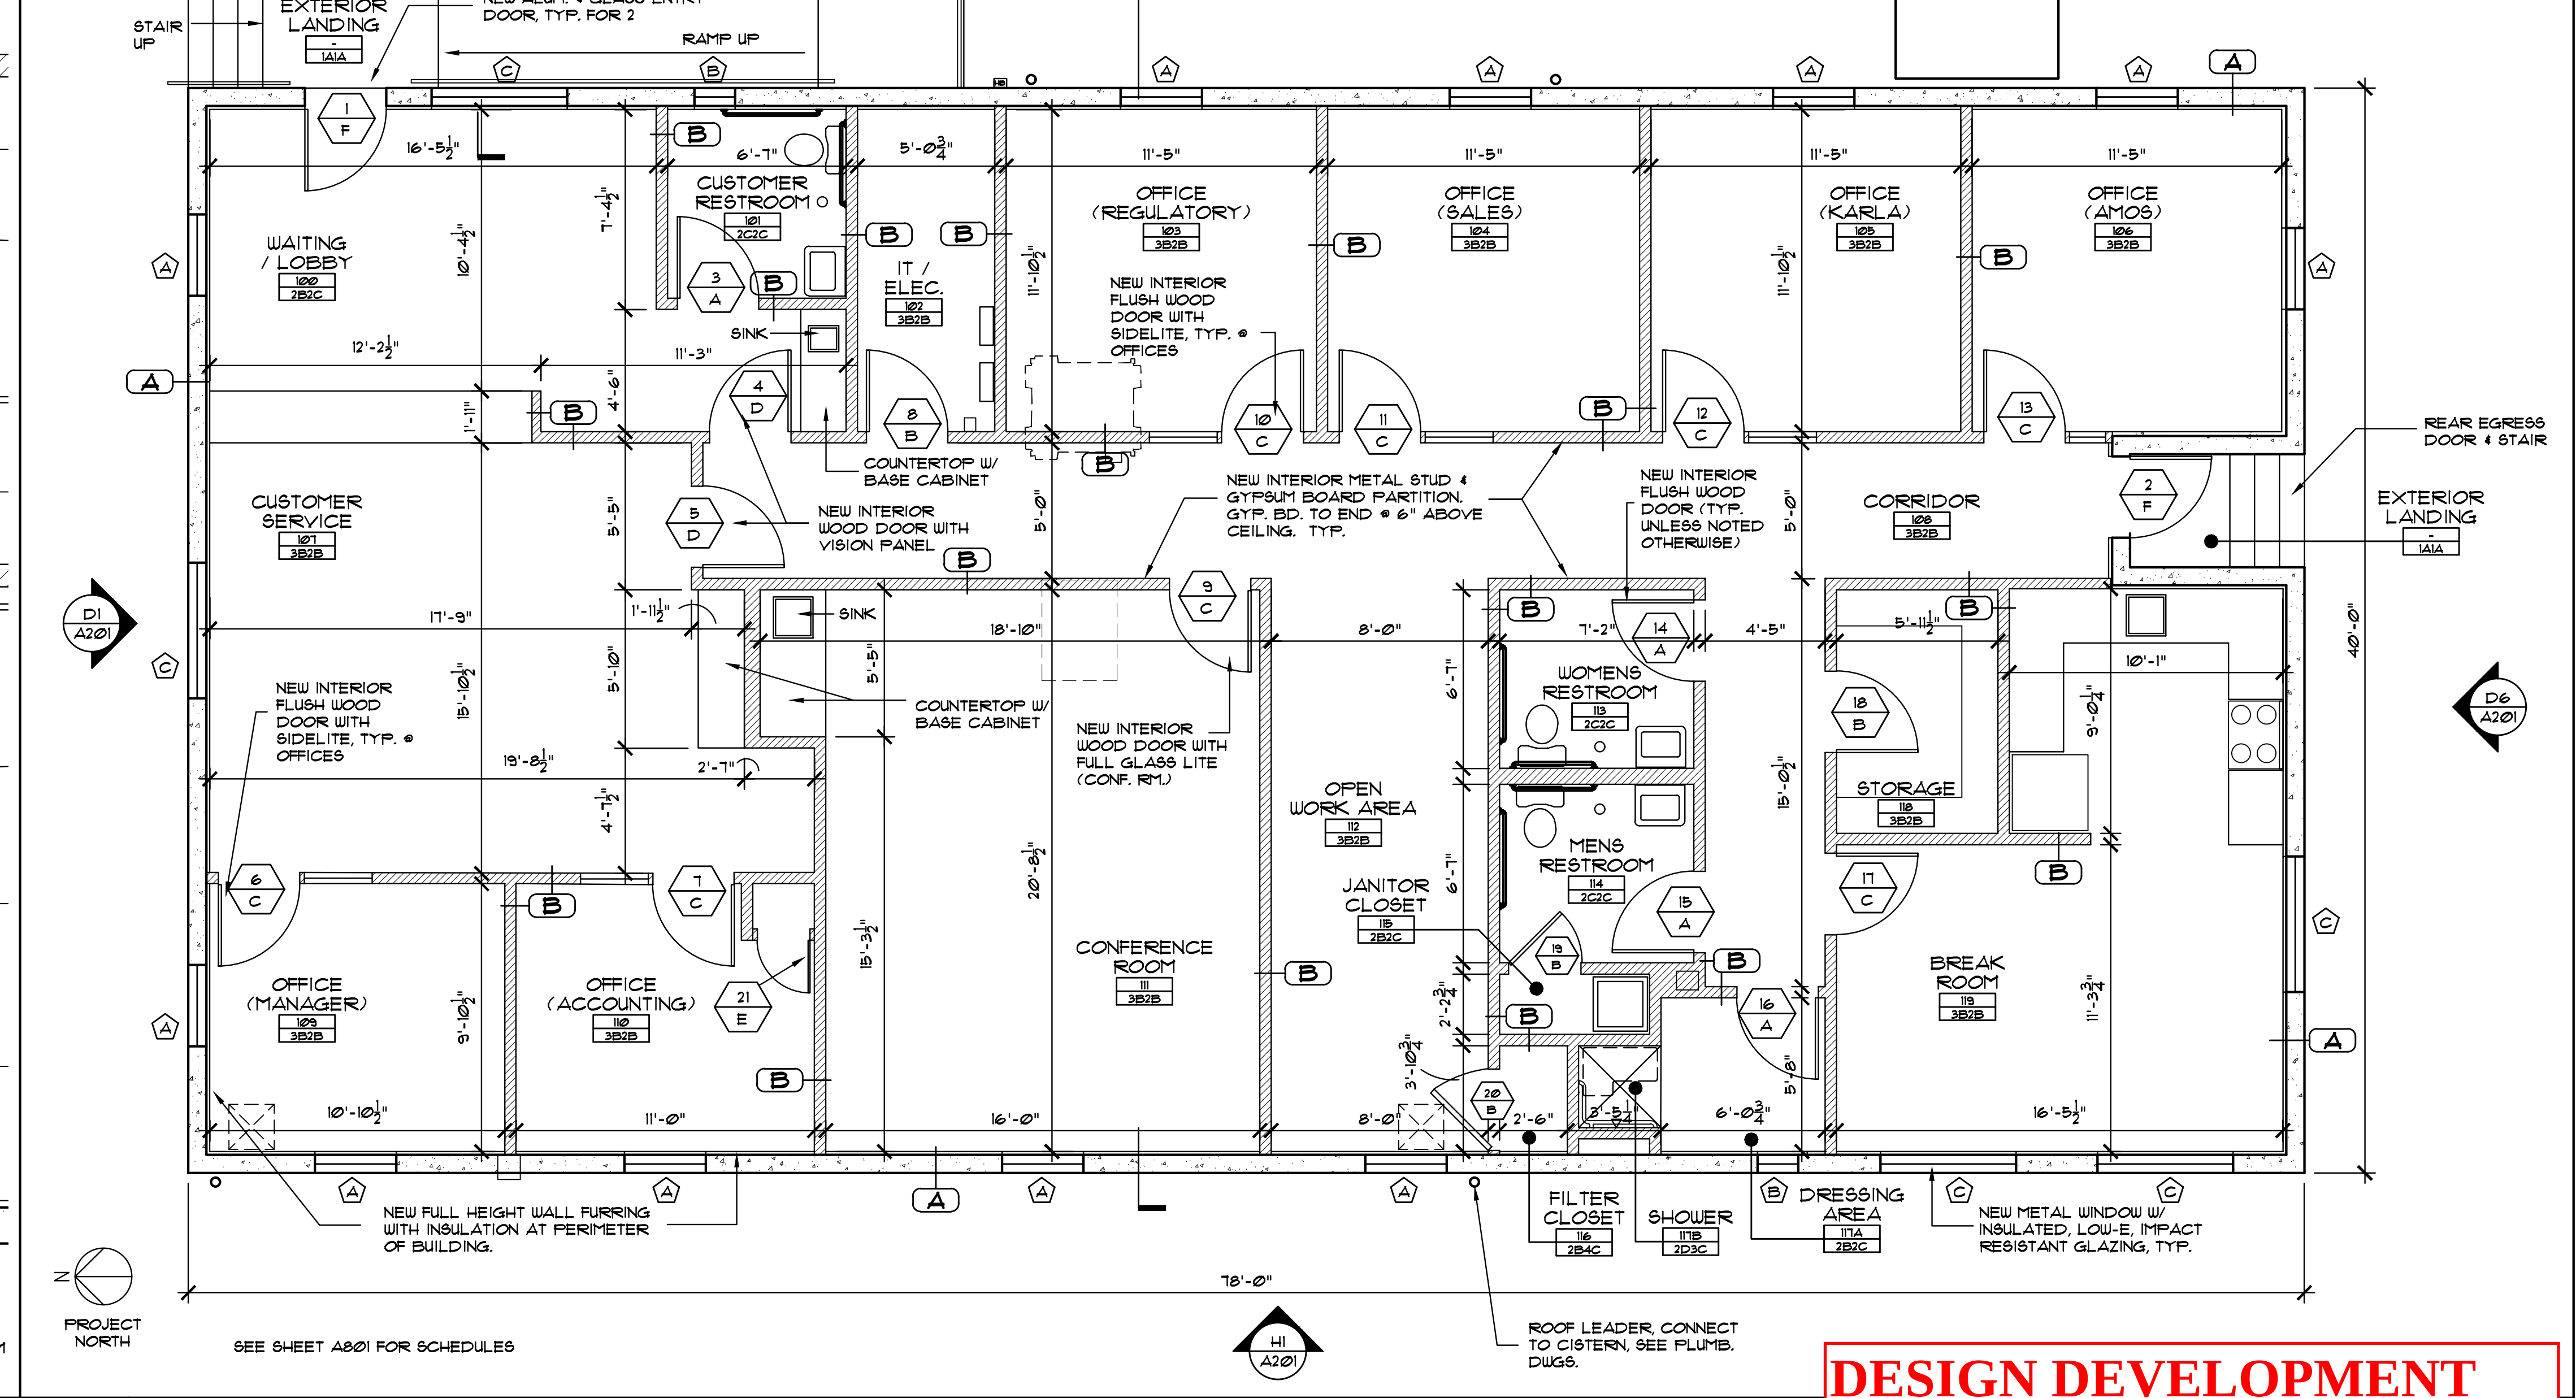

 A horizontal number line with arrows at both ends. There are three tick marks labeled 1, 2, and 3 from left to right.

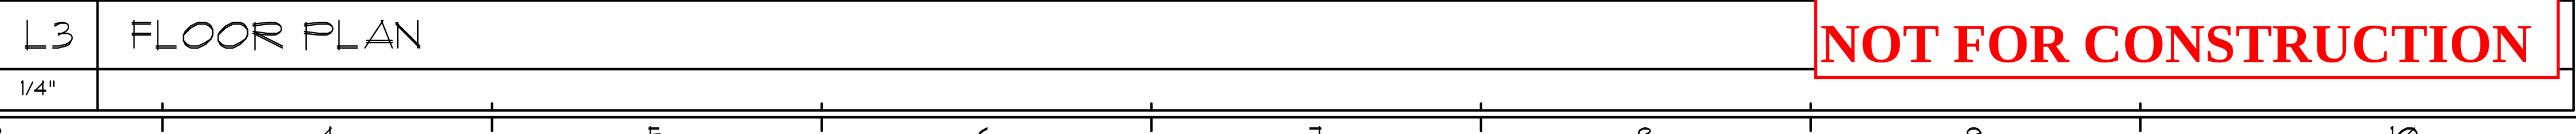

 BENTON CONSTRUCTION, LLC 3000 ORANGE GROVE, CHRISTIANSTEDT, ST. CROIX, U.S. VIRGIN ISLANDS 00602 PHONE: (340) 718-1222 FAX: (340) 718-4775 WEBSITE: WWW.BJCVI.COM		
ARCHITECT		
 SILVERBERG ASSOCIATES VI, P.C. ARCHITECTS 95 COMPANY STREET, SUITE B, CHRISTIANSTEDT, ST. CROIX, USVI 00602 NJ PHONE: (609) 921-067 NJ FAX: (609) 921-8326		
MEP ENGINEER		
 T.J.D. ENGINEERING ASSOCIATES, INC. 2 Hancock Drive, West Milford, N.J. 07480 Certificate of Authorization 24GA27944000 Phone 973-208-0054 Fax 973-208-0851		
STRUCTURAL ENGINEER		
HARRISON HAMNETT, P.C. 40 Knowles Street Pennington, New Jersey 08534 Office (609) 818-1808 Fax (609) 818-1809		
OWNER		
 TROPICAL SHIPPING		
PROFESSIONAL SEAL:		
THIS DRAWING SHALL NOT BE USED FOR CONSTRUCTION UNLESS A PROFESSIONAL'S SEAL AND SIGNATURE ARE ON THE DRAWING		
PROJECT TITLE / DESCRIPTION: TROPICAL SHIPPING NEW OFFICES		
FACILITY LOCATION: TROPICAL SHIPPING LLC. (LEASED PLOT) PLOT NO. 8 EAST SHORE (H.O.V.I.C. LANDS) QUEEN'S QUARTER, ST. CROIX USVI		
DATE: 5-28-24		
NO:	REVISION:	DATE:
PROJECT NUMBER: 22254		
DRAWING TITLE: FLOOR PLAN		
SHEET NUMBER: A101		
SHEET	OF	

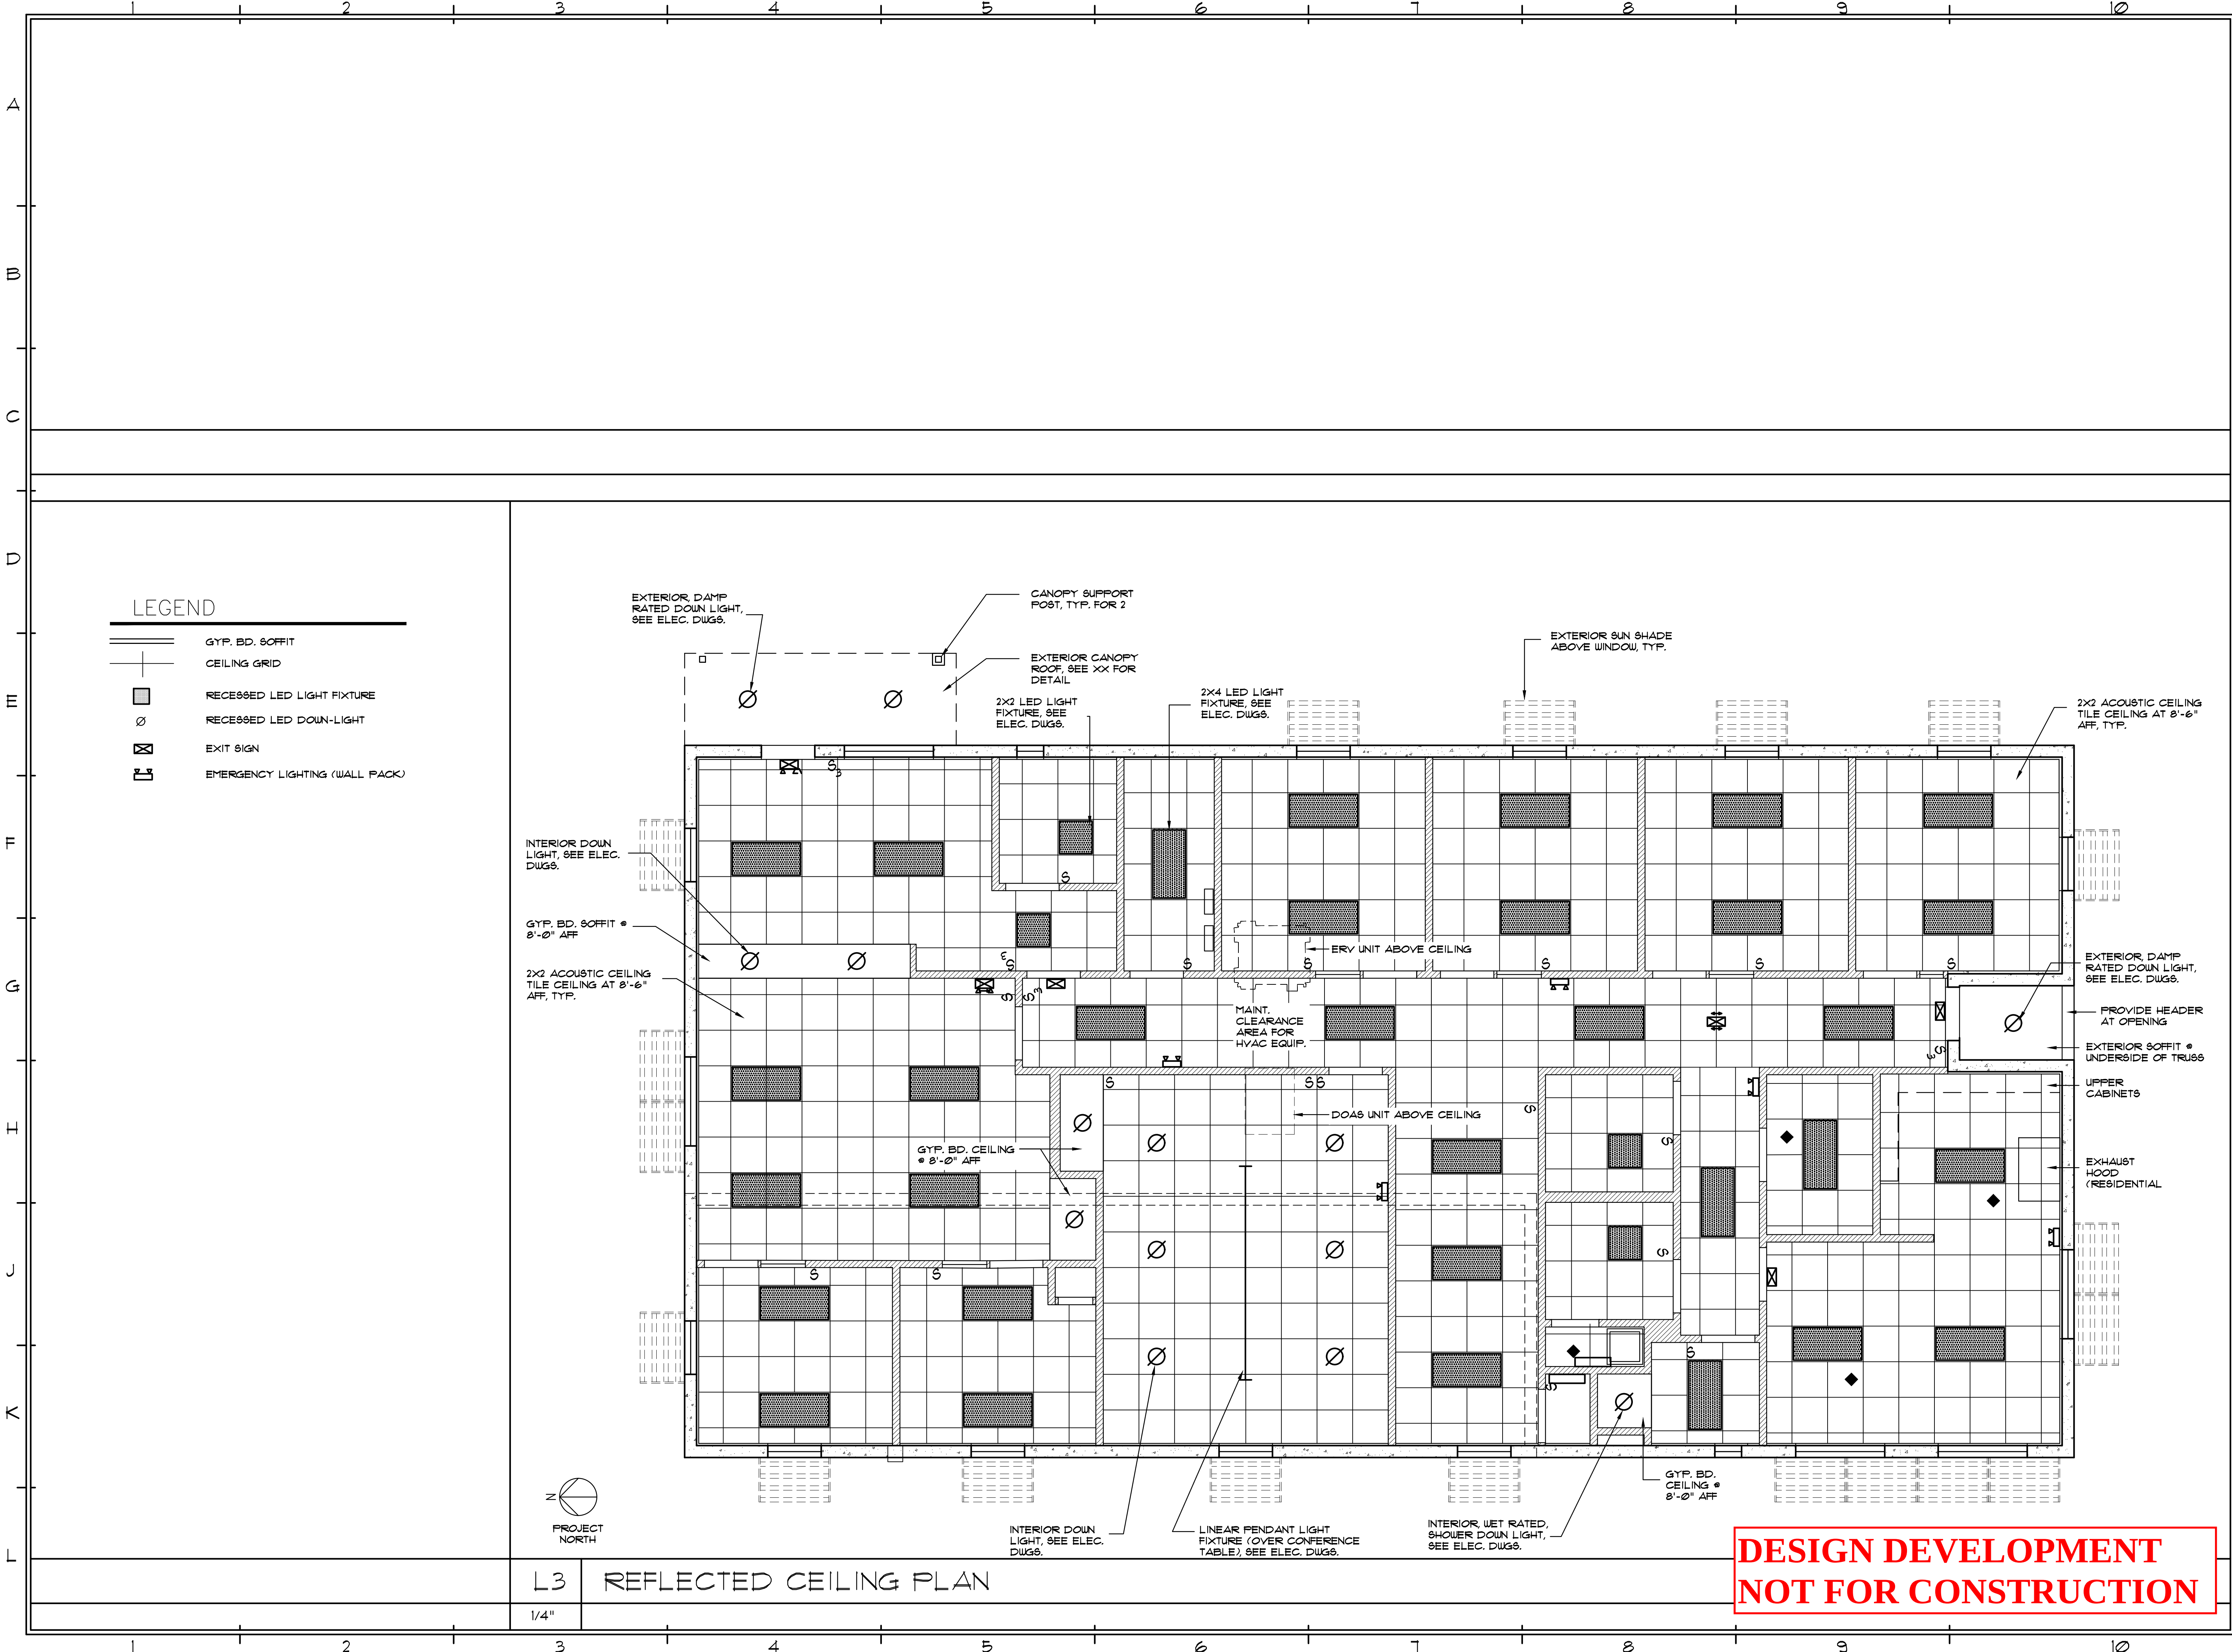

3000 ORANGE GROVE, CHRISTIANSTED
ST. CROIX, U.S. VIRGIN ISLANDS 00602
PHONE: (340) 718-1222 FAX: (340) 718-4179
WEBSITE: WWW.BCV.COM

ARCHITECT

55 COMPANY STREET, SUITE B, CHRISTIANSTED
ST. CROIX, U.S.VI 00602
NU PHONE: (609) 521-8861 NU FAX: (609) 521-8326

MEP ENGINEER

T.J.D. ENGINEERING ASSOCIATES, INC.
2 Hancock Drive, West Milford, N.J. 07480
Certificate of Authorization 24CA27944000
Phone 973-208-0054
Fax 973-208-0851

STRUCTURAL ENGINEER

HARRISON HAMNETT, P.C.
40 Knowles Street
Pennington, New Jersey 08534
Office (609) 818-1808
Fax (609) 818-1809

OWNER

PROFESSIONAL SEAL:

THIS DRAWING SHALL NOT BE USED FOR
CONSTRUCTION UNLESS A PROFESSIONAL'S
SEAL AND SIGNATURE ARE ON THE DRAWING

PROJECT TITLE / DESCRIPTION:
**TROPICAL SHIPPING
NEW OFFICES**

FACILITY LOCATION:
TROPICAL SHIPPING LLC,
(LEASED PLOT)
PLOT NO. 8
EAST HOPE (H.O.V.I.C. LANDS)
QUEEN'S QUARTER, ST. CROIX USVI

DATE:
5-28-24


NO.	REVISION:	DATE:

PROJECT NUMBER:
22254

DRAWING TITLE:
**REFLECTED
CEILING PLAN**

SHEET NUMBER:
A102

SHEET	OF

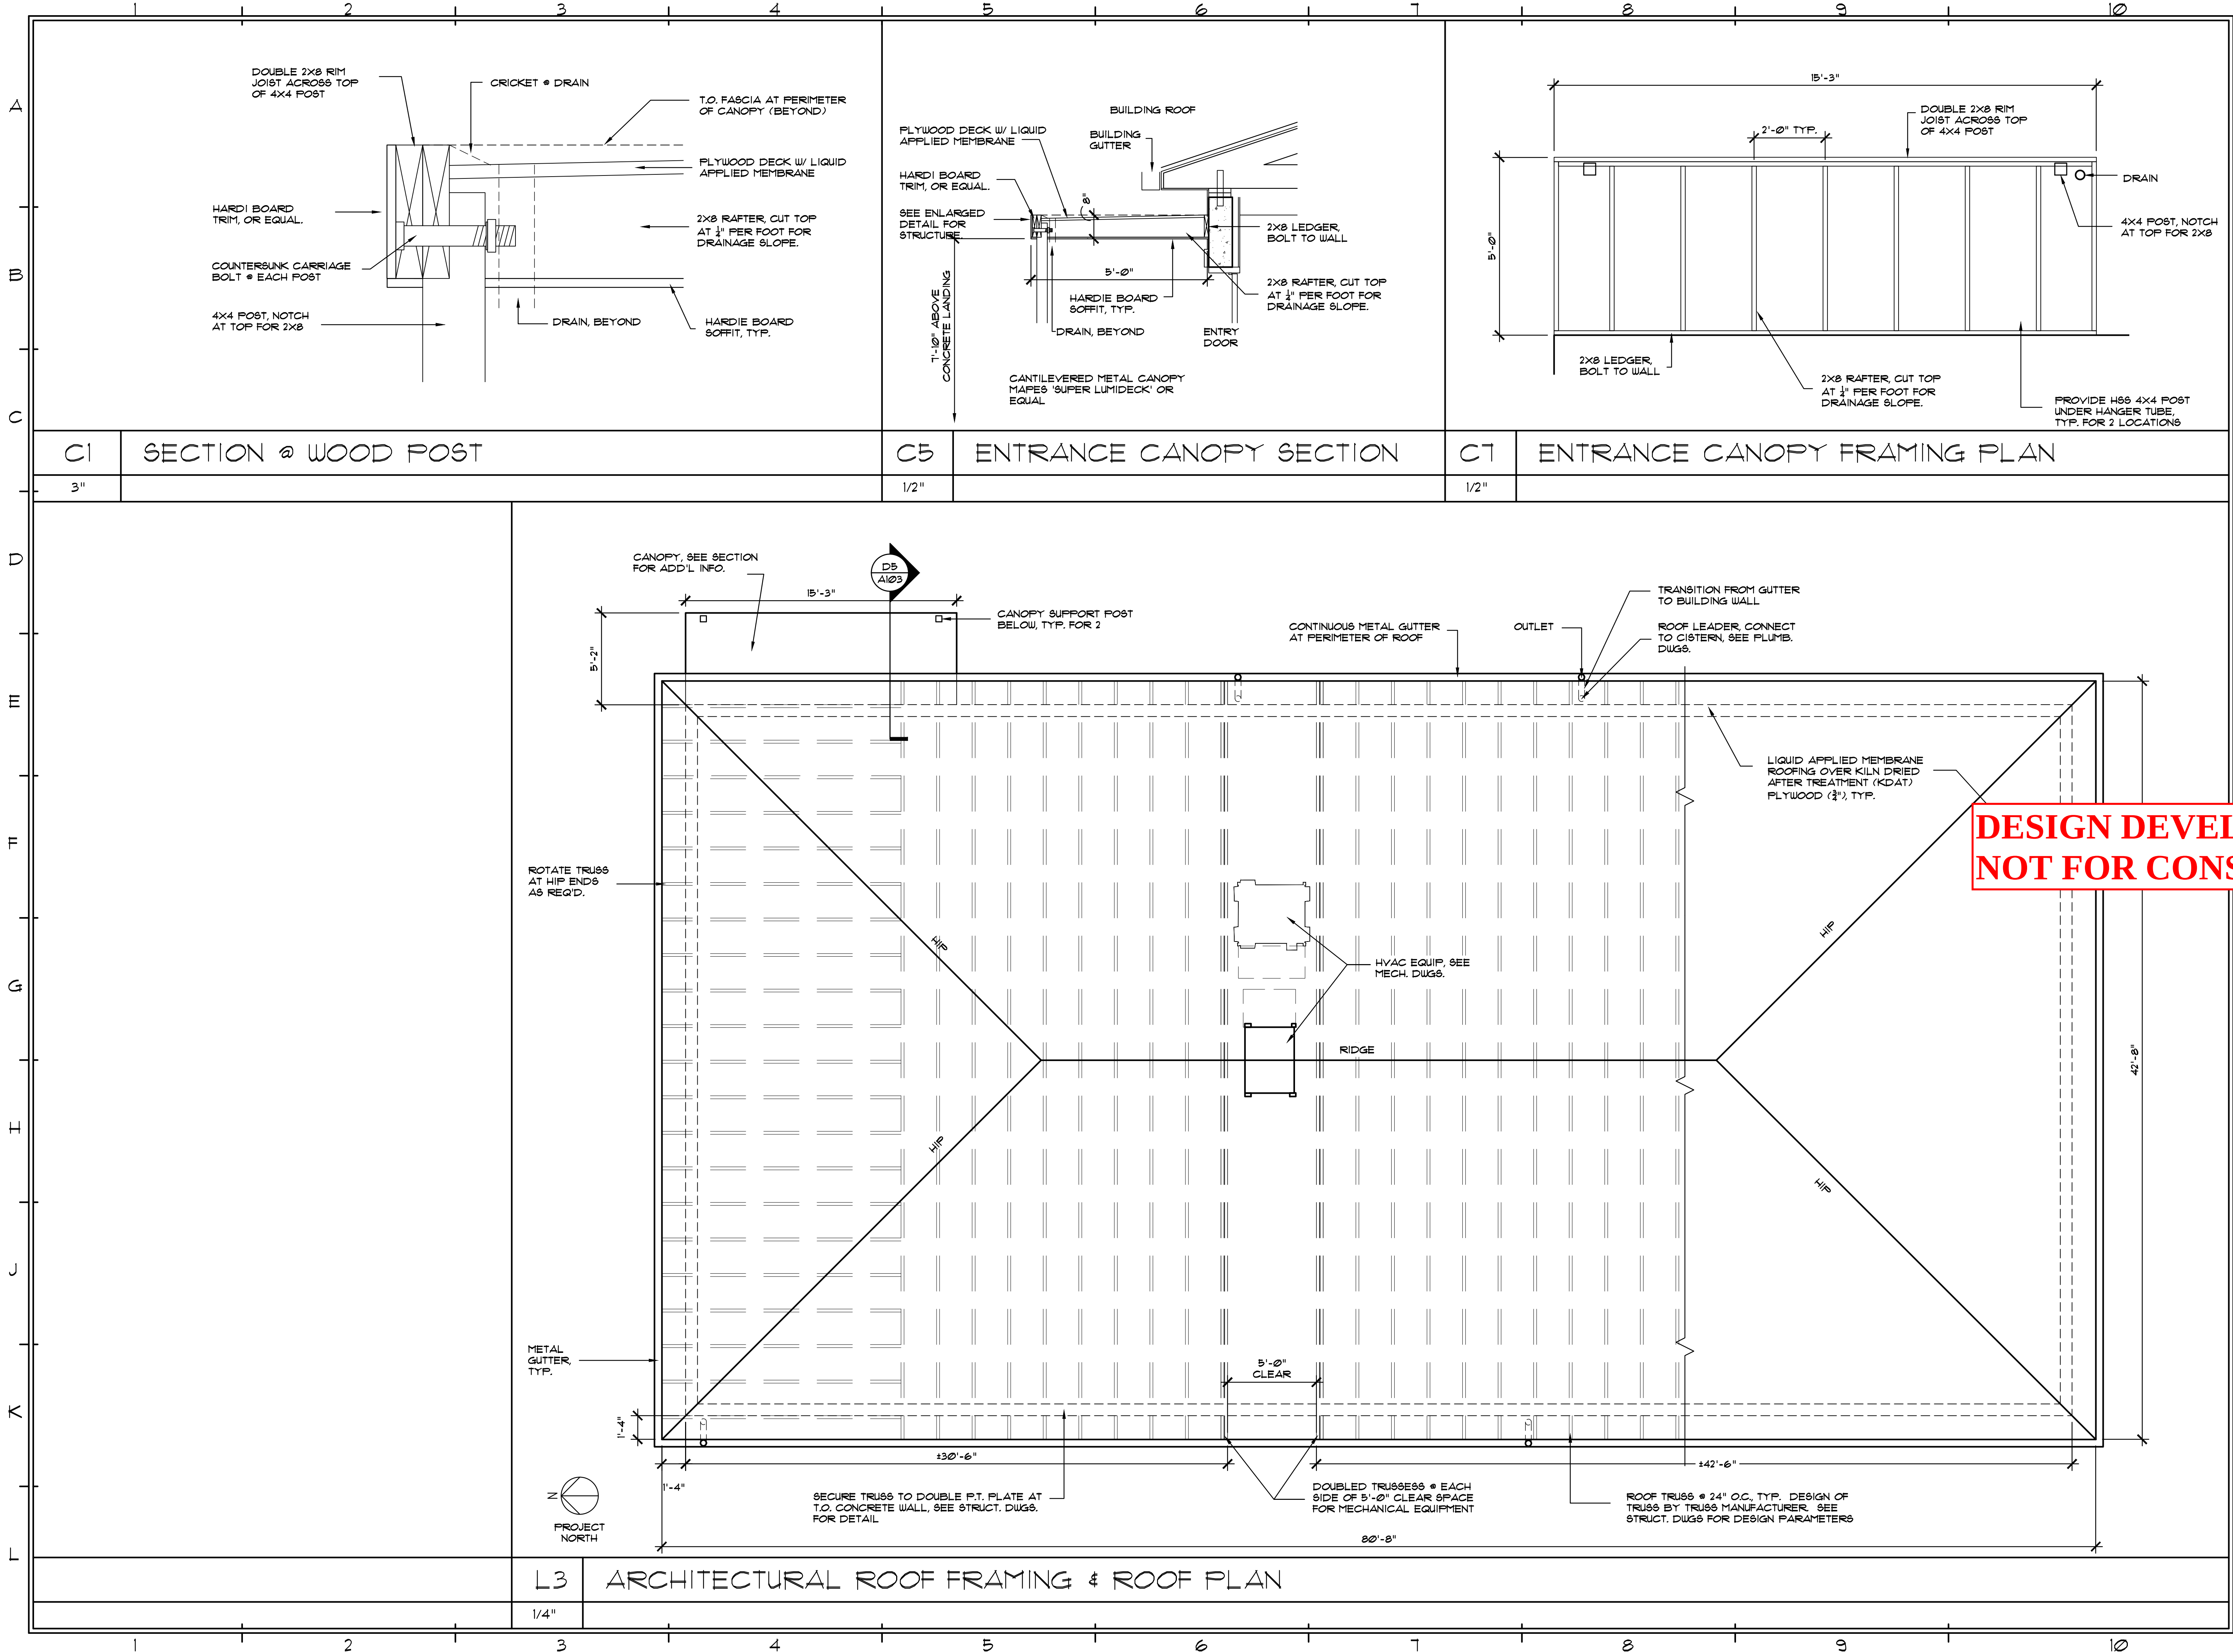

BENTON
CONSTRUCTION, LLC
3000 ORANGE GROVE, CHRISTIANSTED
ST. CROIX, U.S. VIRGIN ISLANDS 00602
PHONE: (340) 718-1222 FAX: (340) 718-4178
WEBSITE: WWW.BCVI.COM

ARCHITECT

SILVERBERG
ASSOCIATES V.I., P.C.
ARCHITECTS
55 COMPANY STREET, SUITE B, CHRISTIANSTED
ST. CROIX, U.S.V.I. 00602
NU PHONE: (609) 521-8861 NU FAX: (609) 521-8826

MEP ENGINEER

T.J.D. ENGINEERING ASSOCIATES, INC.
2 Hancock Drive, West Milford, N.J. 07480
Certificate of Authorization 24CA27944000
Phone 973-208-0054
Fax 973-208-0851

STRUCTURAL ENGINEER

HARRISON HAMNETT, P.C.
40 Knowles Street
Pennington, New Jersey 08534
Office (609) 818-1808
Fax (609) 818-1809

OWNER

Tropical
SHIPPING

PROFESSIONAL SEAL:

THIS DRAWING SHALL NOT BE USED FOR CONSTRUCTION UNLESS A PROFESSIONAL'S SEAL AND SIGNATURE ARE ON THE DRAWING

PROJECT TITLE / DESCRIPTION:
TROPICAL SHIPPING
NEW OFFICES

FACILITY LOCATION:
TROPICAL SHIPPING LLC,
(LEASED PLOT)
PLOT NO. 8
EAST HOPE (H.O.V.I.C. LANDS)
QUEEN'S QUARTER, ST. CROIX USVI

DATE:
5-28-24


NO.	REVISION:	DATE:

PROJECT NUMBER:
22254

DRAWING TITLE:
ROOF PLAN
& DETAILS


SHEET NUMBER:
A103

SHEET OF

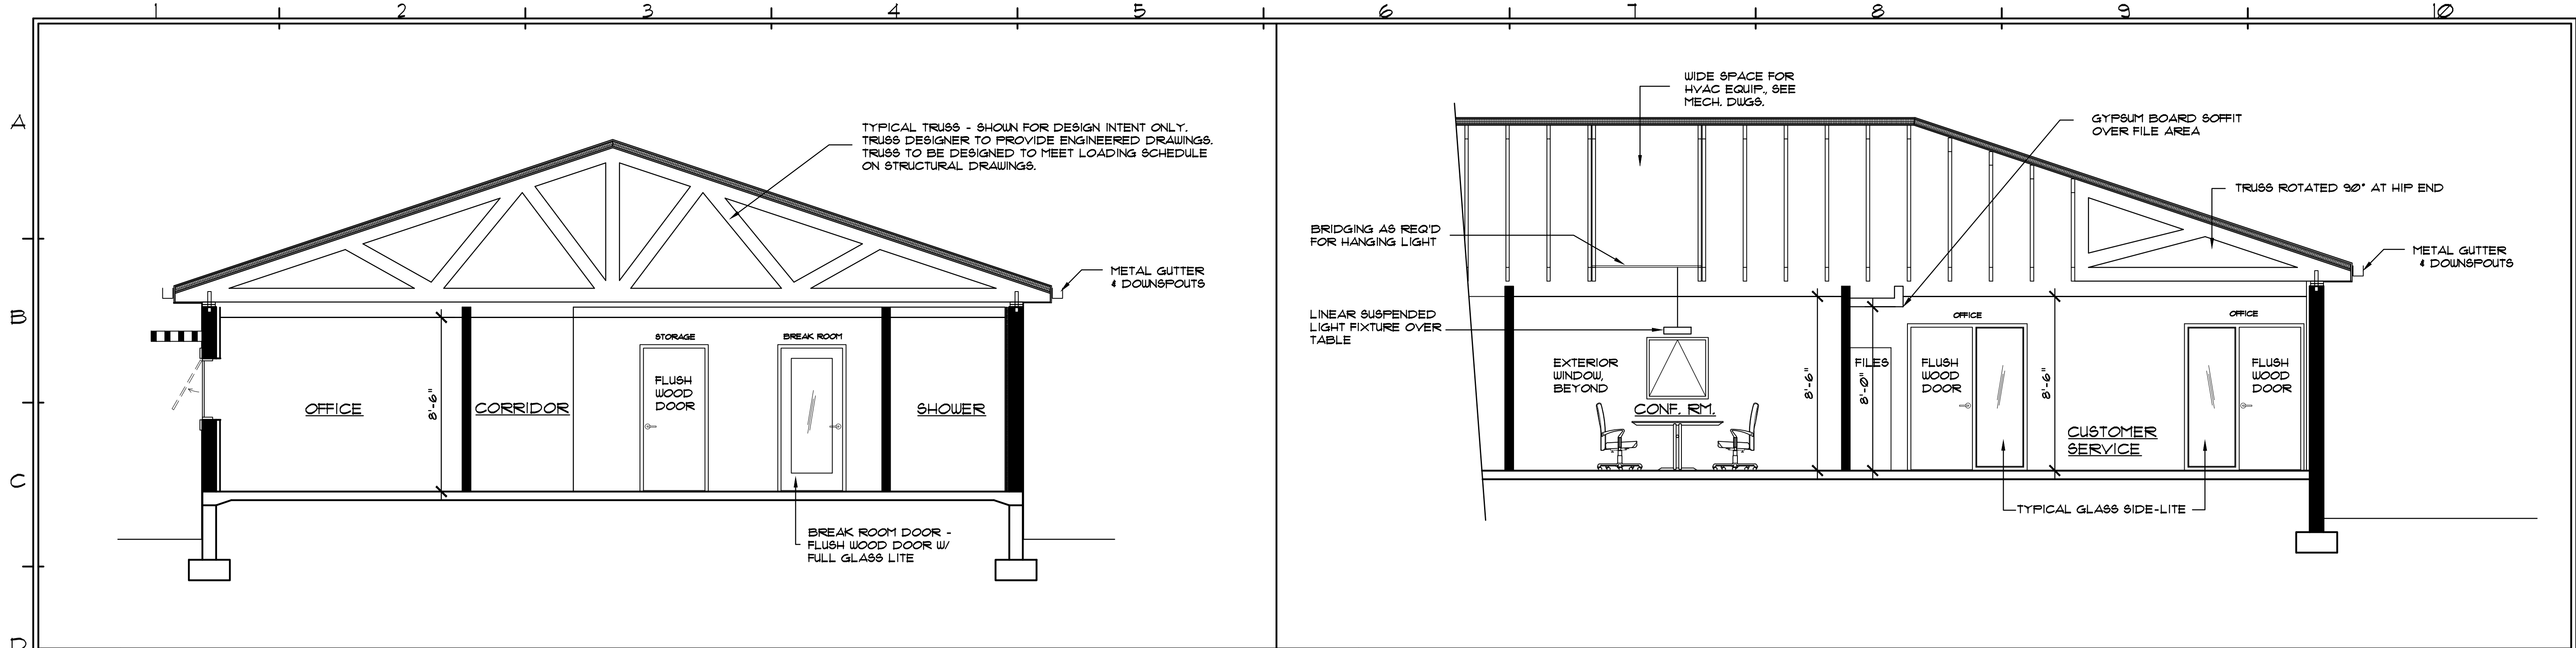


D1 SECTION / INTERIOR ELEVATION AT CONF. ROOM & CUST. SVC.

D6 SECTION / INTERIOR ELEVATION AT CONF. ROOM & CUST. SVC.

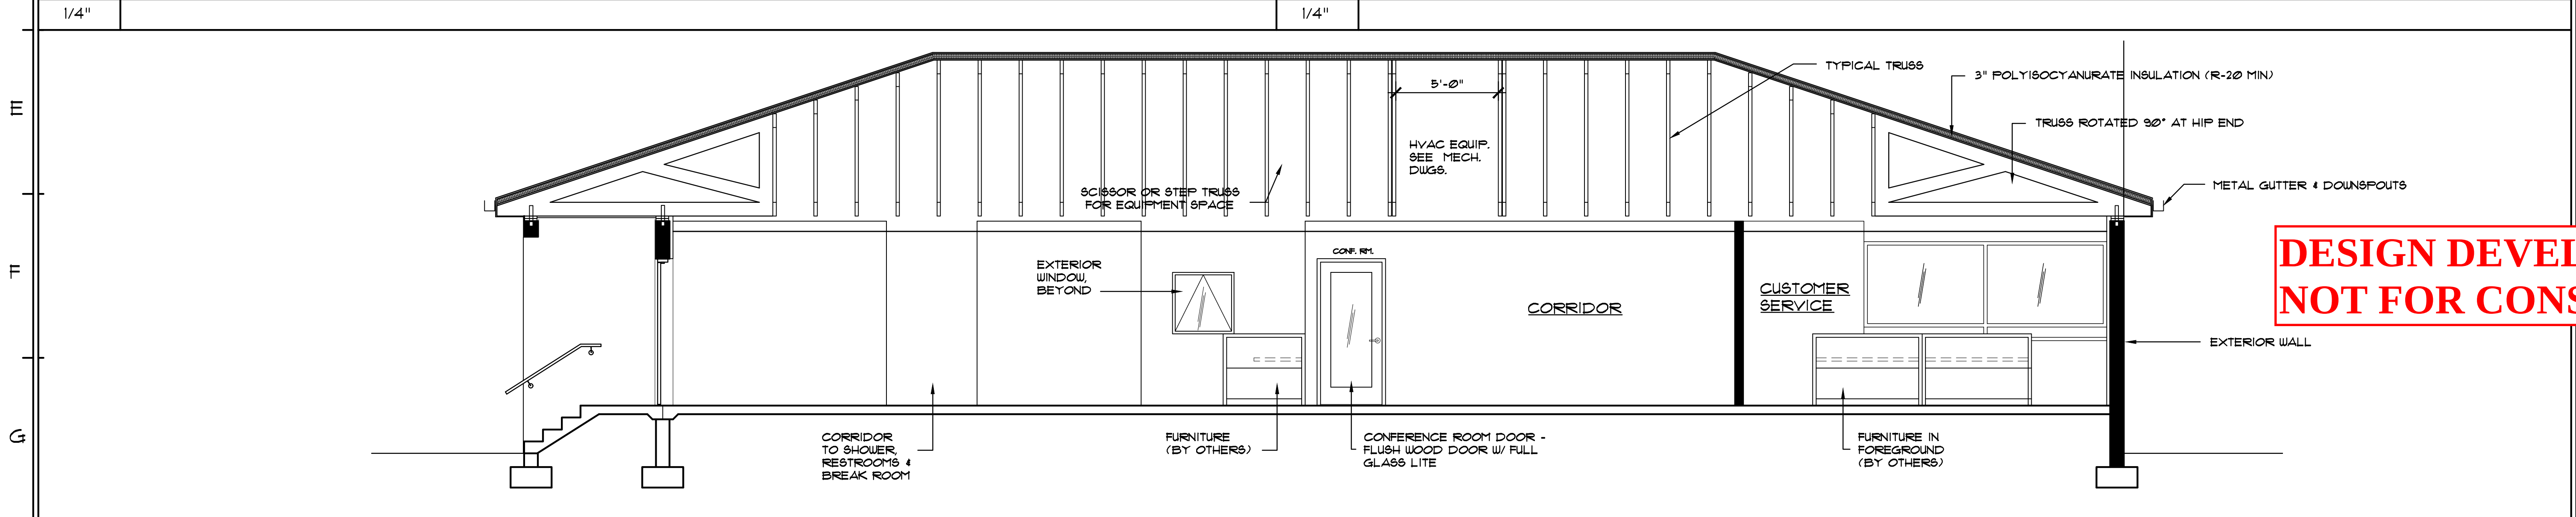

H1 SECTION / INTERIOR ELEVATION AT CORRIDOR (FACING SOUTH)

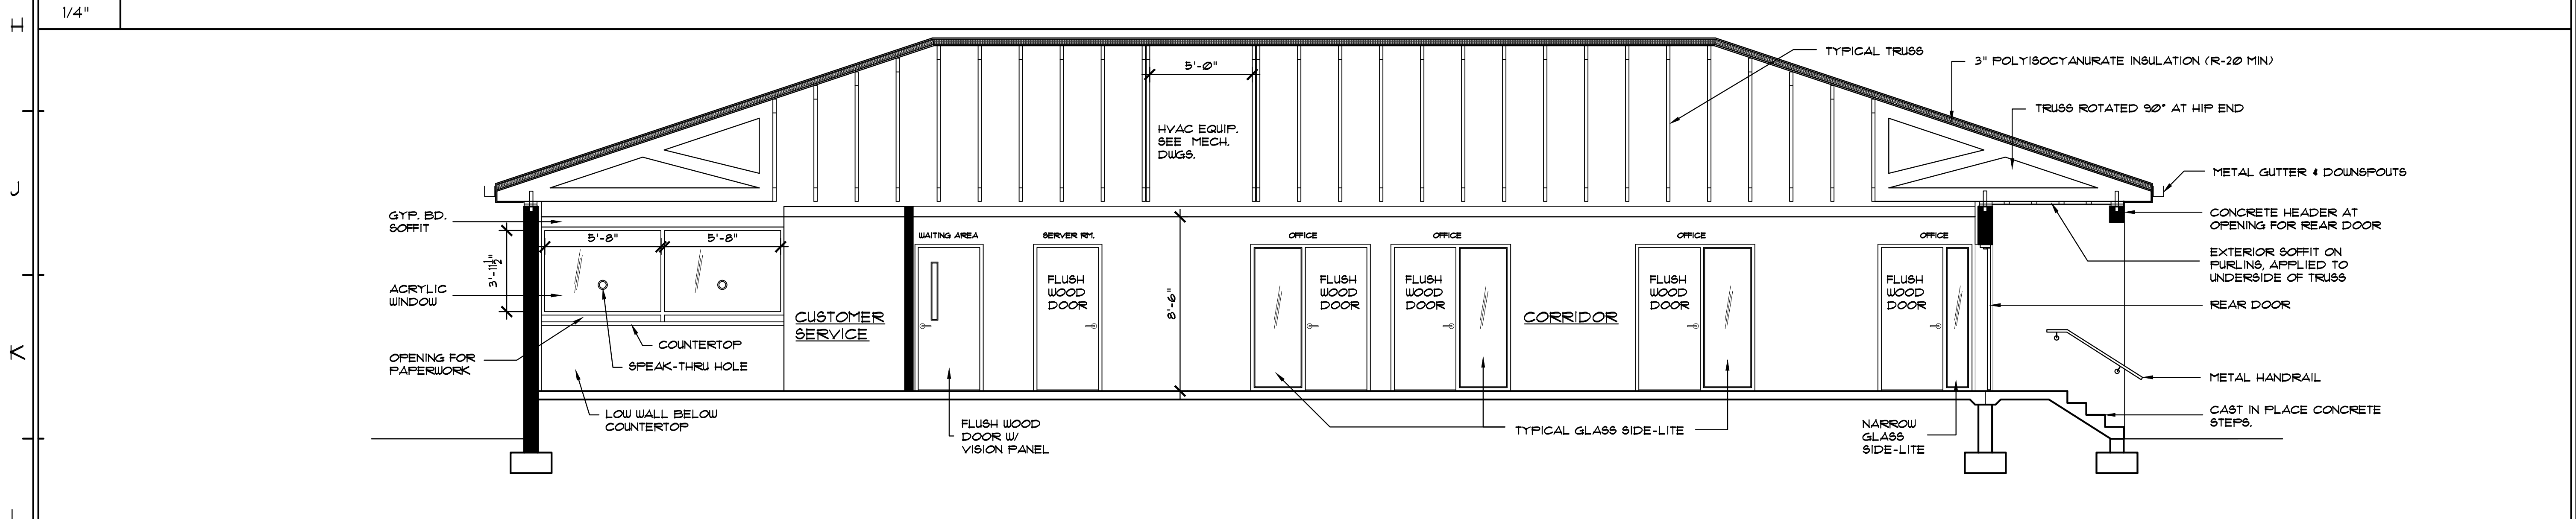

L1 SECTION / INTERIOR ELEVATION AT CORRIDOR (FACING NORTH)

BENTON
CONSTRUCTION, LLC
3000 ORANGE GROVE, CHRISTIANSTED
ST. CROIX, U.S. VIRGIN ISLANDS 00602
PHONE: (340) 718-1222 FAX: (340) 718-4175
WEBSITE: WWW.BCV.COM

ARCHITECT

SILVERBERG
ASSOCIATES V.I., P.C.
ARCHITECTS
55 COMPANY STREET, SUITE B, CHRISTIANSTED
ST. CROIX, U.S.V.I. 00602
U.S. PHONE: (609) 521-1861 U.S. FAX: (609) 521-8326

MEP ENGINEER

T.J.D. ENGINEERING ASSOCIATES, INC.
2 Hancock Drive, West Milford, N.J. 07480
Certificate of Authorization 24CA27944000
Phone 973-208-0054
Fax 973-208-0851

STRUCTURAL ENGINEER

HARRISON HAMNETT, P.C.
40 Knowles Street
Pennington, New Jersey 08534
Office (609) 818-1808
Fax (609) 818-1809

OWNER

Tropical
SHIPPING

PROFESSIONAL SEAL:

THIS DRAWING SHALL NOT BE USED FOR CONSTRUCTION UNLESS A PROFESSIONAL'S SEAL AND SIGNATURE ARE ON THE DRAWING

PROJECT TITLE / DESCRIPTION:
TROPICAL SHIPPING
NEW OFFICES

FACILITY LOCATION:
TROPICAL SHIPPING LLC,
(LEASED PLOT)
PLOT NO. 8
EAST HOPE (H.O.V.I.C. LANDS)
QUEEN'S QUARTER, ST. CROIX USVI

DATE:
5-28-24



NO.	REVISION:	DATE:

PROJECT NUMBER:
22254

DRAWING TITLE:
INTERIOR
ELEVATIONS

SHEET NUMBER:
A202

SHEET OF

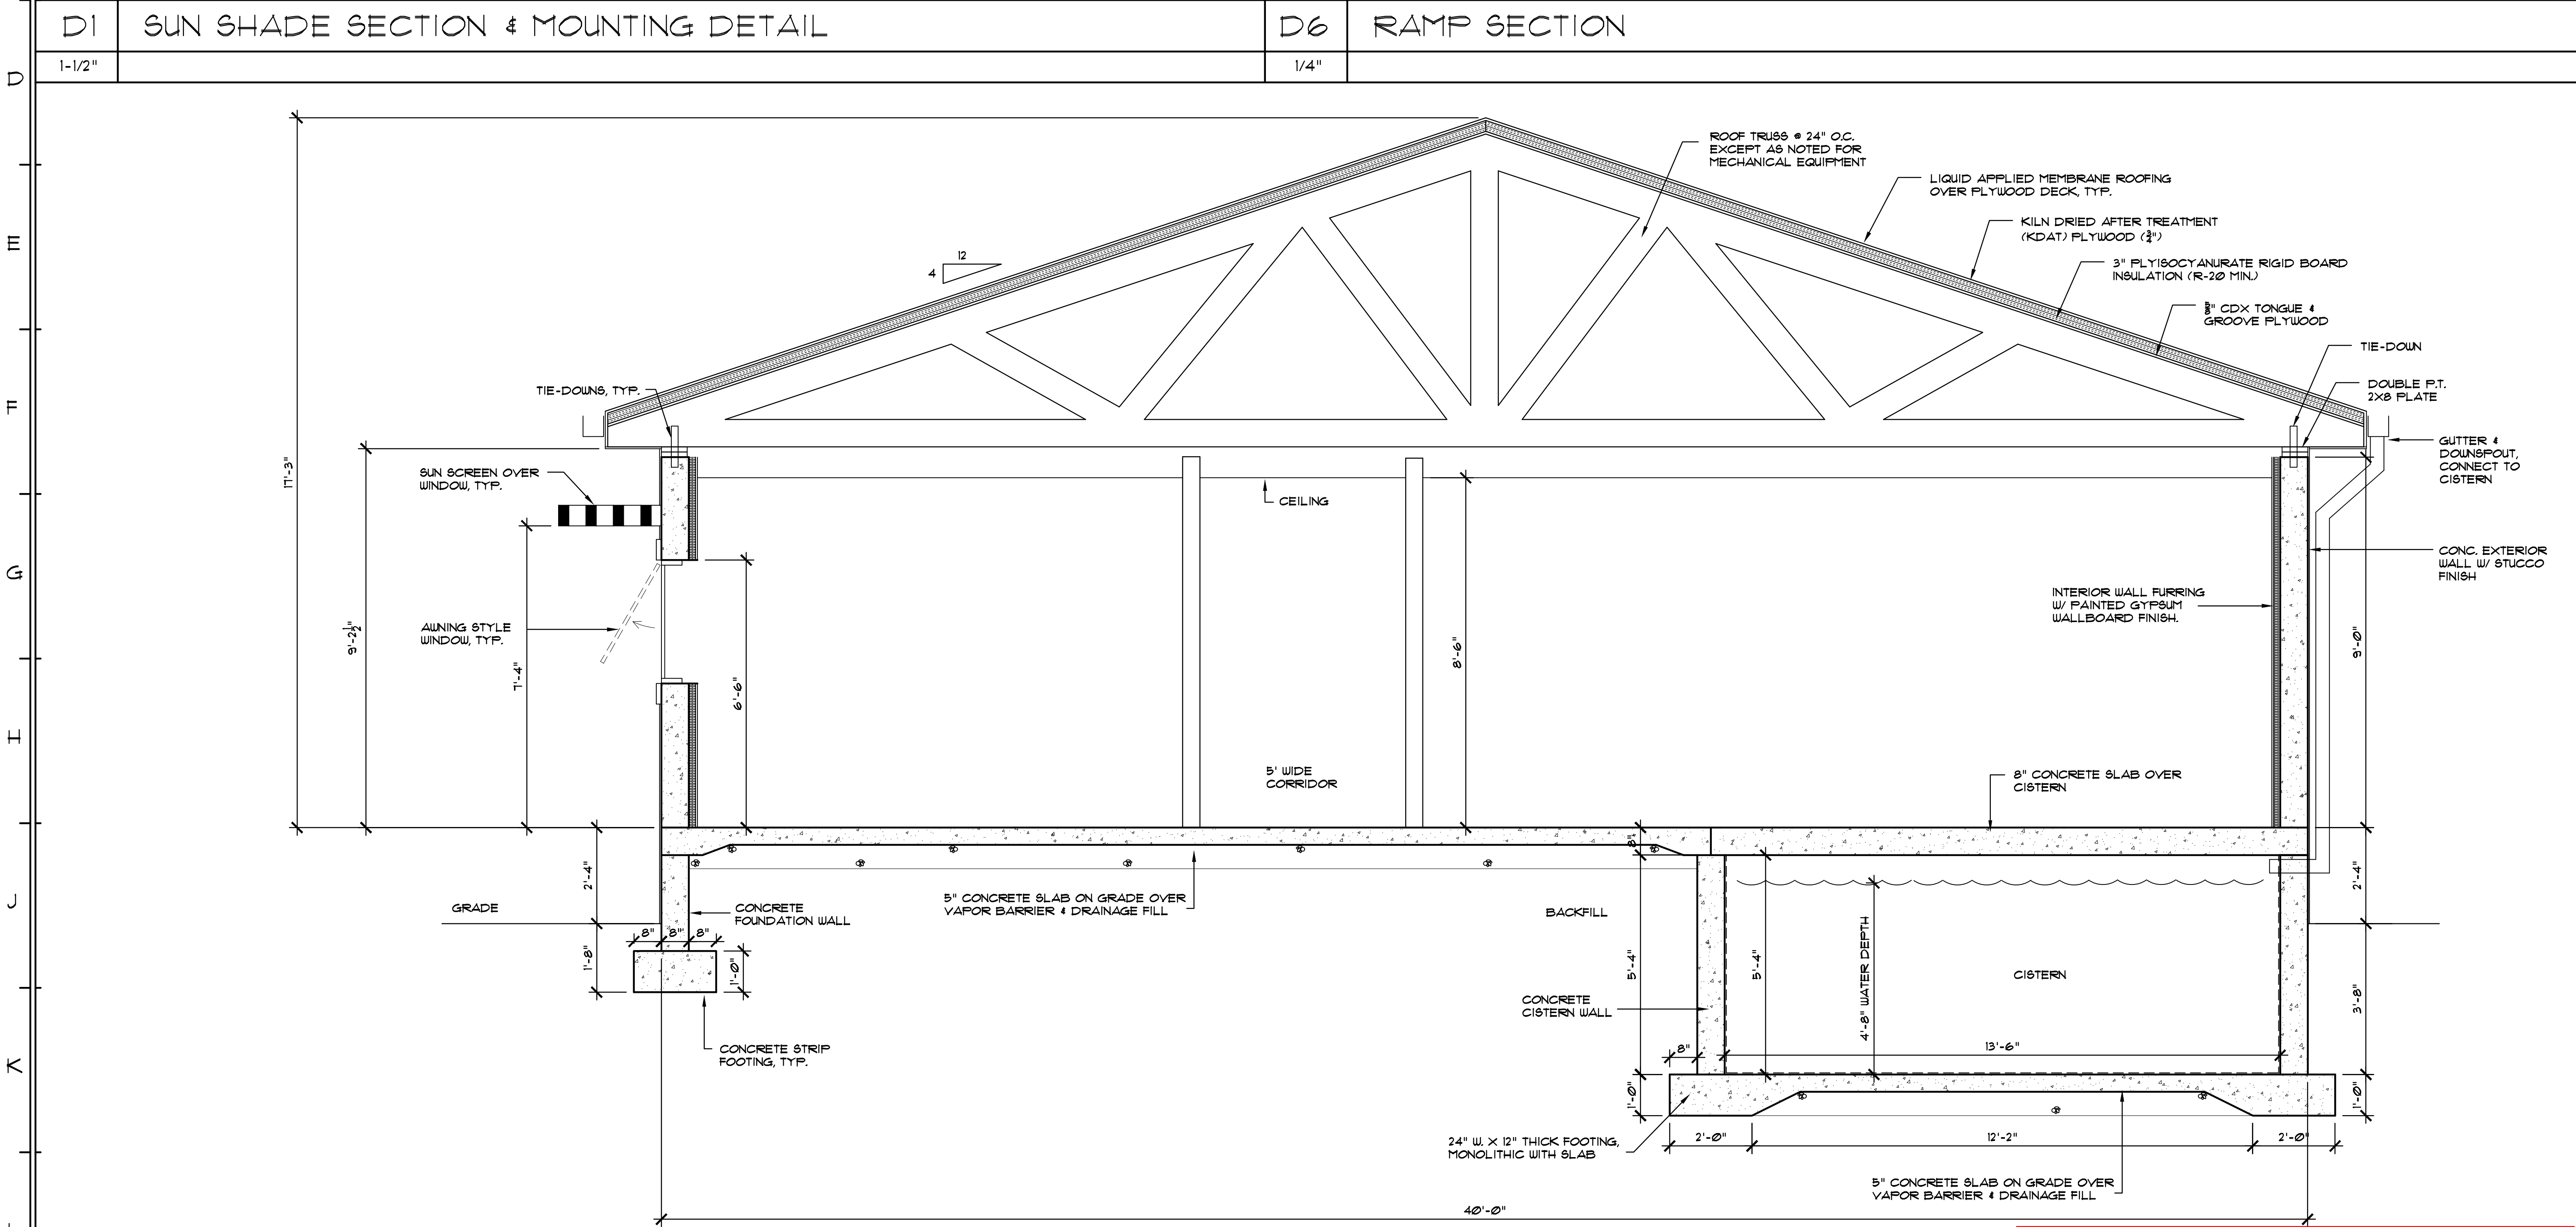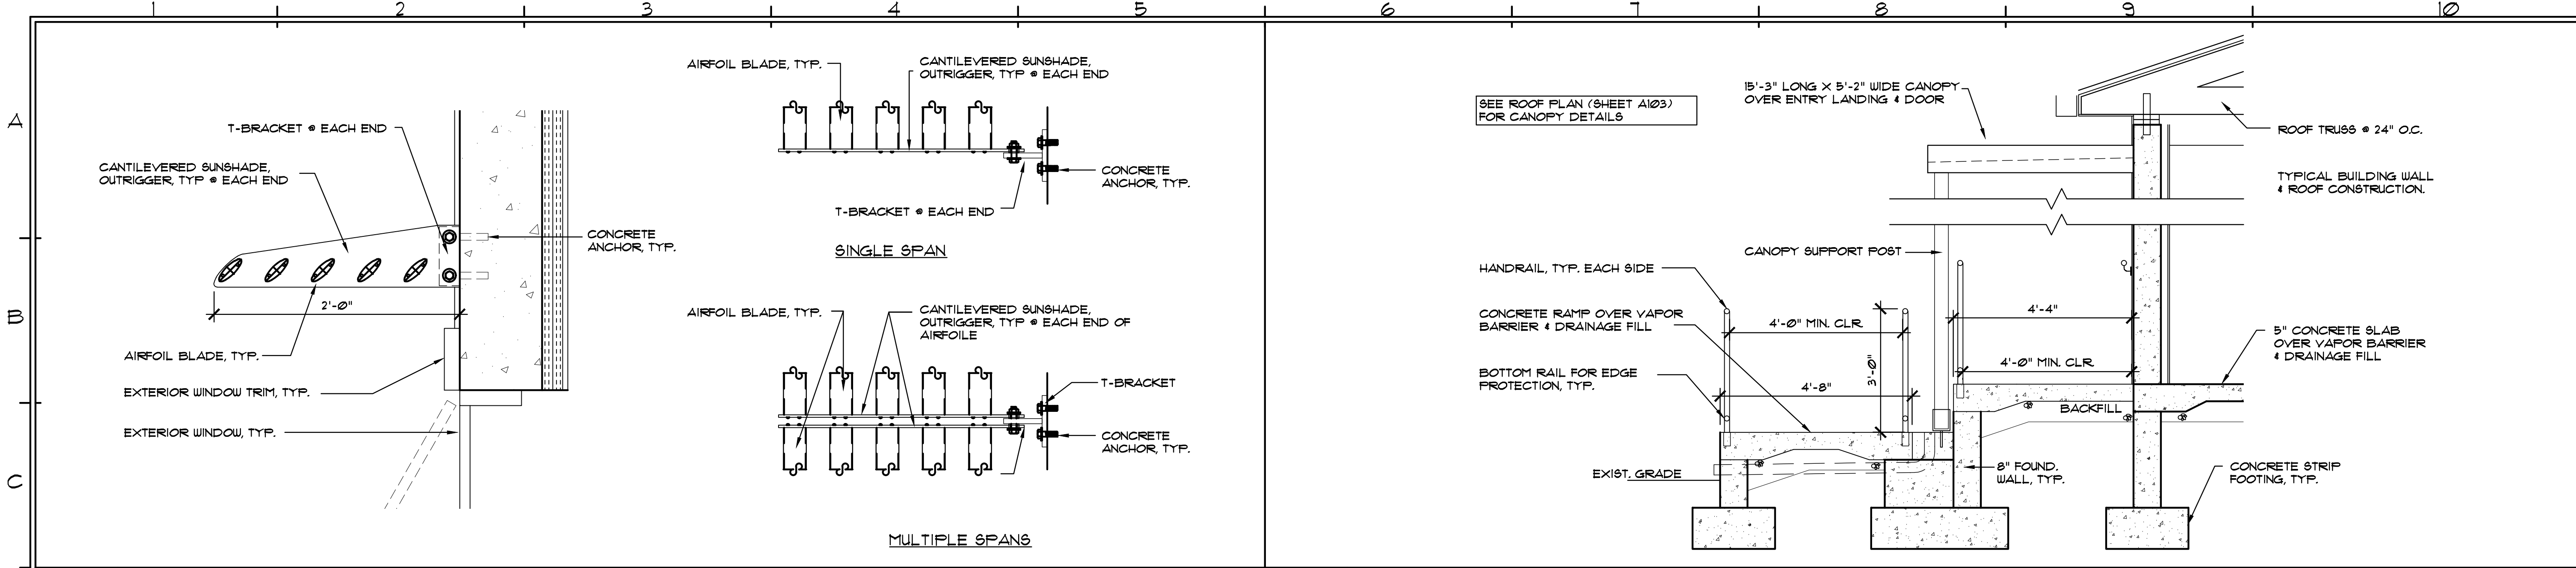

**DESIGN DEVELOPMENT
NOT FOR CONSTRUCTION**

BENTON
CONSTRUCTION, LLC
3000 ORANGE GROVE, CHRISTIANSTED
ST. CROIX, VI. VIRGIN ISLANDS 00602
PHONE: (340) 718-1222 FAX: (340) 718-4175
WEBSITE: WWW.BCV.COM

ARCHITECT

SILVERBERG
ASSOCIATES V.I., P.C.
ARCHITECTS
55 COMPANY STREET, SUITE B, CHRISTIANSTED
ST. CROIX, VI. 00602
VI PHONE: (609) 521-1861 VI FAX: (609) 521-8326

MEP ENGINEER

T.J.D. ENGINEERING ASSOCIATES, INC.
2 Hancock Drive, West Milford, N.J. 07480
Certificate of Authorization 24CA27944000
Phone 973-208-0054
Fax 973-208-0851

STRUCTURAL ENGINEER

HARRISON HAMNETT, P.C.
40 Knowles Street
Pennington, New Jersey 08534
Office (609) 818-1808
Fax (609) 818-1809

OWNER

PROFESSIONAL SEAL:

THIS DRAWING SHALL NOT BE USED FOR
CONSTRUCTION UNLESS A PROFESSIONAL'S
SEAL AND SIGNATURE ARE ON THE DRAWING

PROJECT TITLE / DESCRIPTION:
**TROPICAL SHIPPING
NEW OFFICES**

FACILITY LOCATION:
TROPICAL SHIPPING LLC.
(LEASED PLOT)
PLOT NO. 8
EAST HOPE (H.O.V.I.C. LANDS)
QUEEN'S QUARTER, ST. CROIX USVI

DATE:
5-28-24


NO.	REVISION:	DATE:

PROJECT NUMBER:
22254

DRAWING TITLE:
**BUILDING
SECTION**

SHEET NUMBER:
A301


SHEET	OF

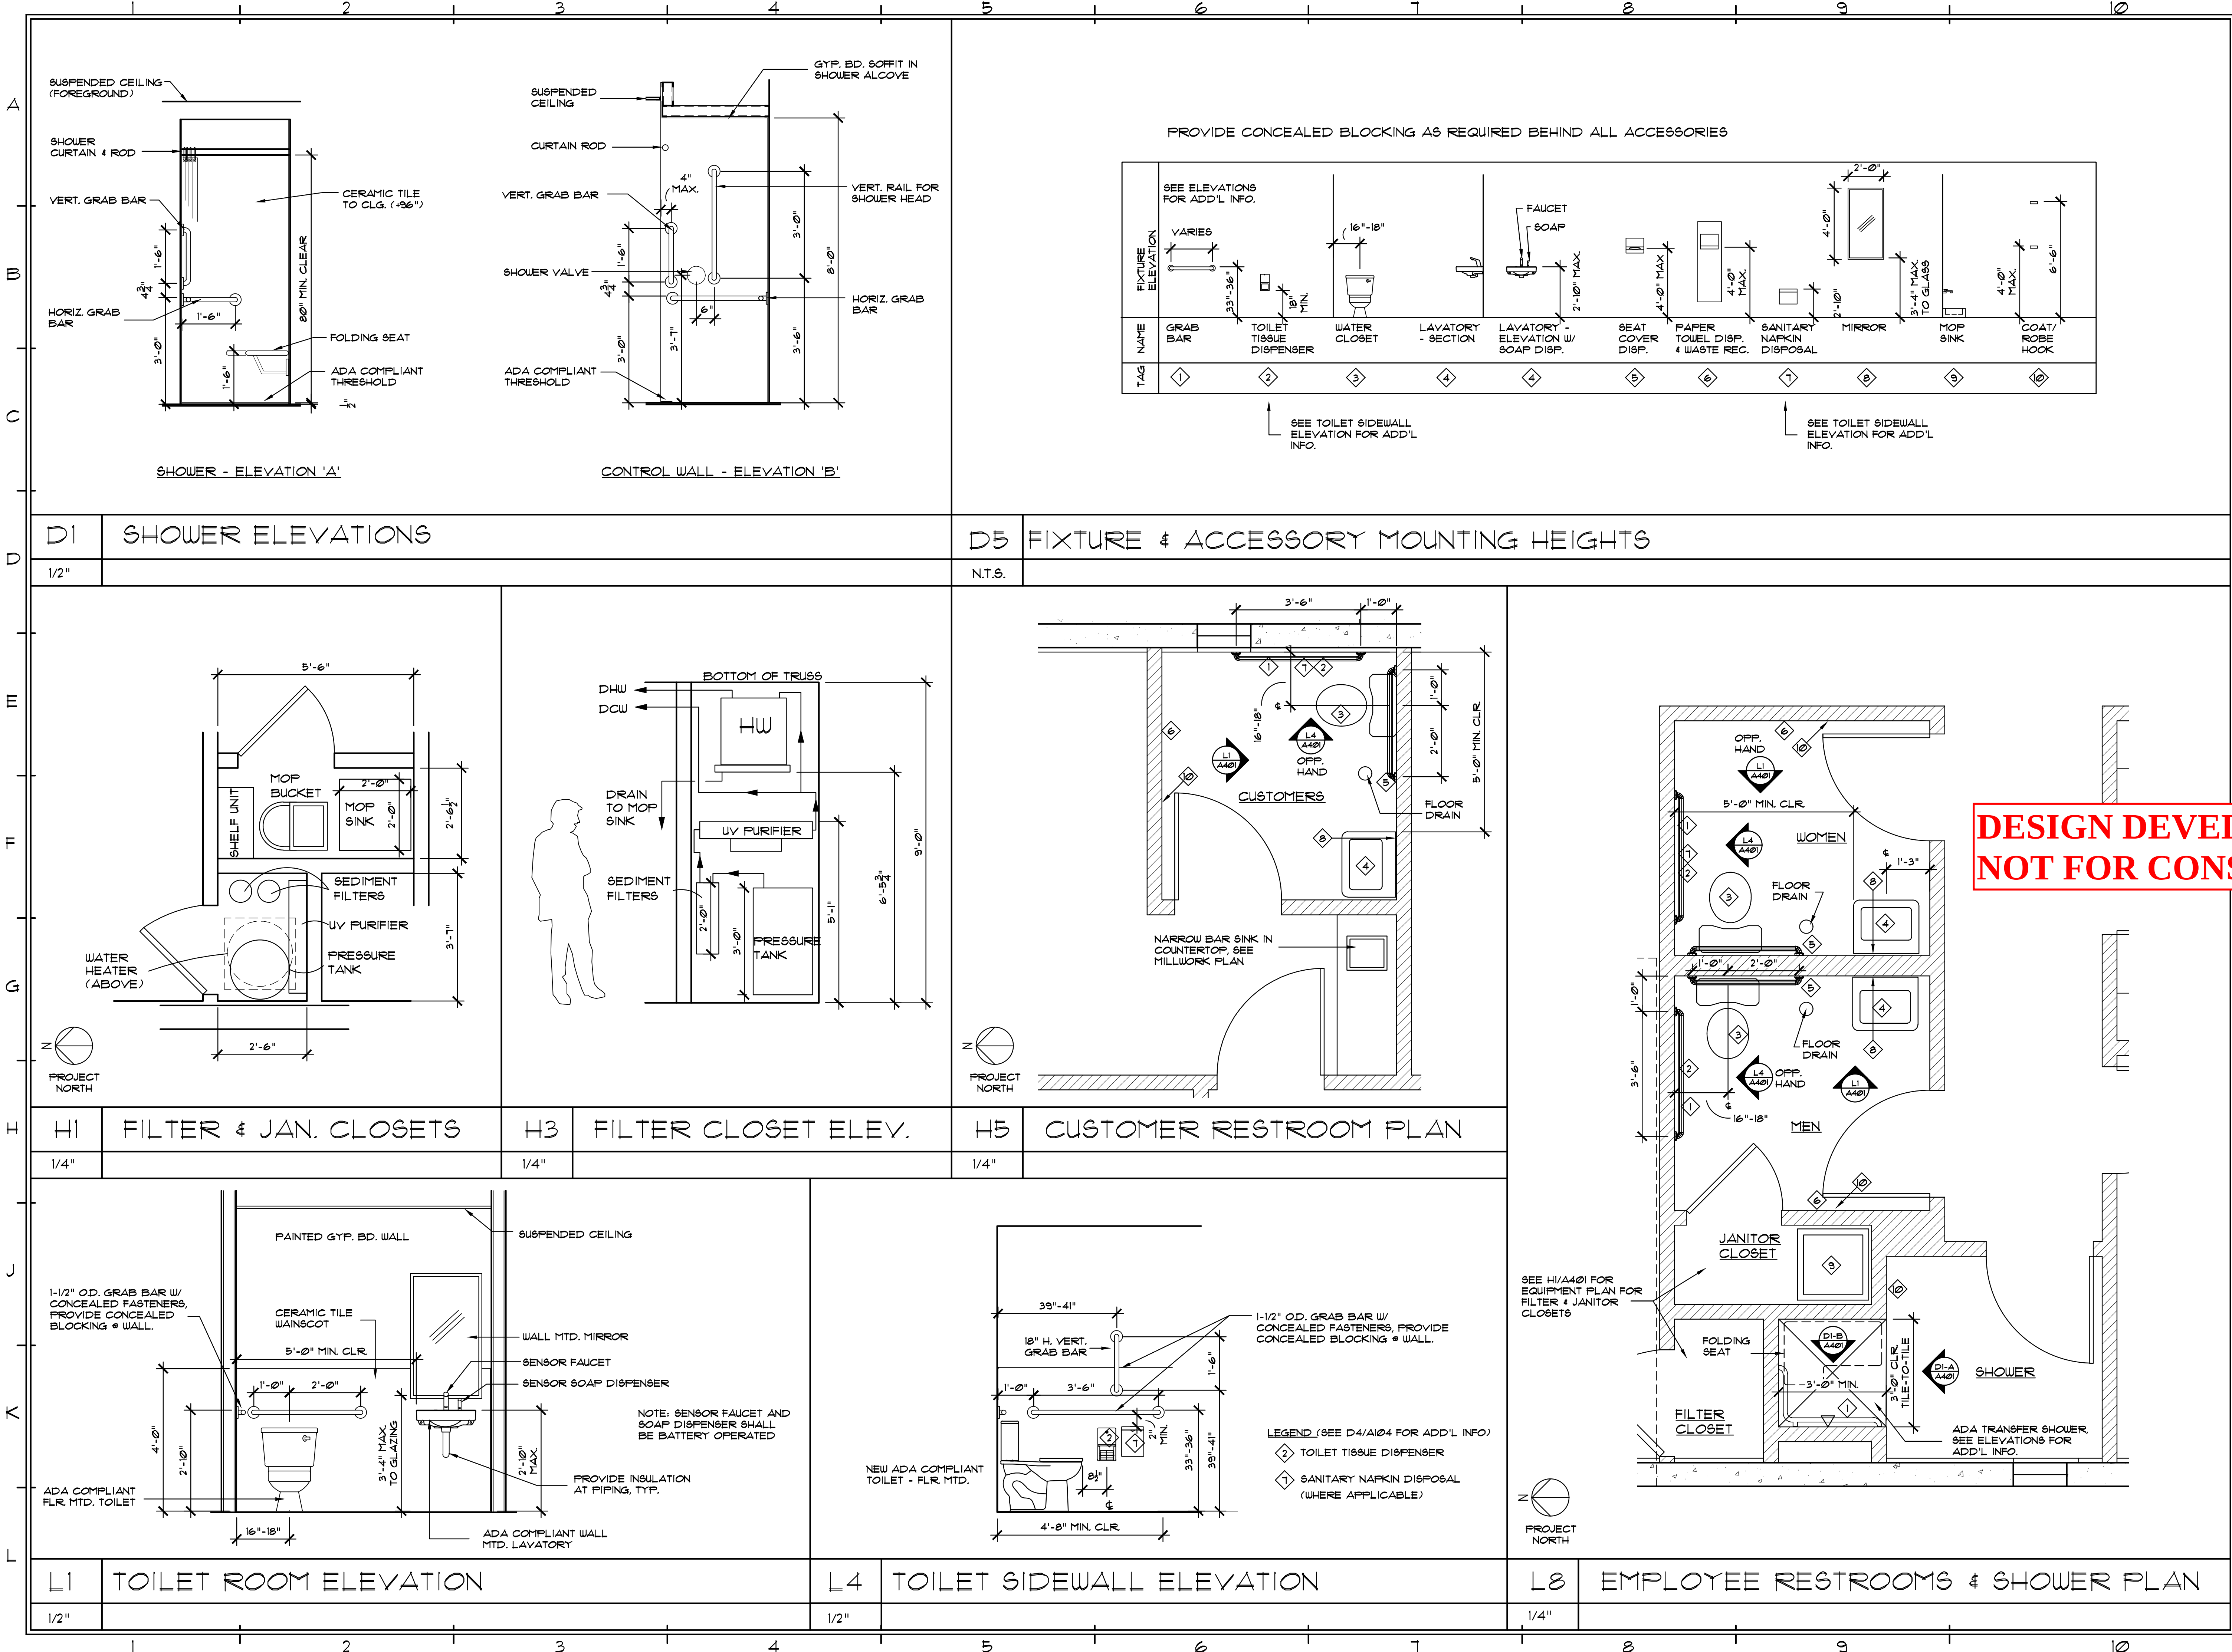




BENTON
CONSTRUCTION, LLC
3000 ORANGE GROVE, CHRISTIANSTEDT
ST. CROIX, VI. 00802
PHONE: (340) 718-1222 FAX: (340) 718-4175
WEBSITE: WWW.BCV.COM

ARCHITECT

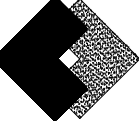

SILVERBERG
ASSOCIATES V.I., P.C.
ARCHITECTS
55 COMPANY STREET, SUITE B, CHRISTIANSTEDT
ST. CROIX, VI. 00802
PHONE: (609) 521-8861 FAX: (609) 521-8826

MEP ENGINEER

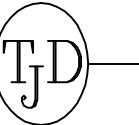

T.J.D. ENGINEERING ASSOCIATES, INC.
2 HANCOCK DRIVE, WEST MILFORD, N.J. 07480
Certificate of Authorization 240A27944000
Phone 973-208-0054
Fax 973-208-0851

STRUCTURAL ENGINEER

HARRISON HAMNETT, P.C.
40 Knowles Street
Pennington, New Jersey 08534
Office (609) 818-1808
Fax (609) 818-1809

OWNER



PROFESSIONAL SEAL:

THIS DRAWING SHALL NOT BE USED FOR CONSTRUCTION UNLESS A PROFESSIONAL'S SEAL AND SIGNATURE ARE ON THE DRAWING

PROJECT TITLE / DESCRIPTION:
**TROPICAL SHIPPING
NEW OFFICES**

FACILITY LOCATION:
TROPICAL SHIPPING LLC,
(LEASED PLOT)

PLOT NO. 8
EAST HOPE (H.O.V.I.C. LANDS)
QUEEN'S QUARTER, ST. CROIX USVI

DATE:
5-28-24


NO.	REVISION	DATE

PROJECT NUMBER:
22254

DRAWING TITLE:
**TOILET FIXTURES
& ACCESSORIES**


SHEET NUMBER:
A401

SHEET OF

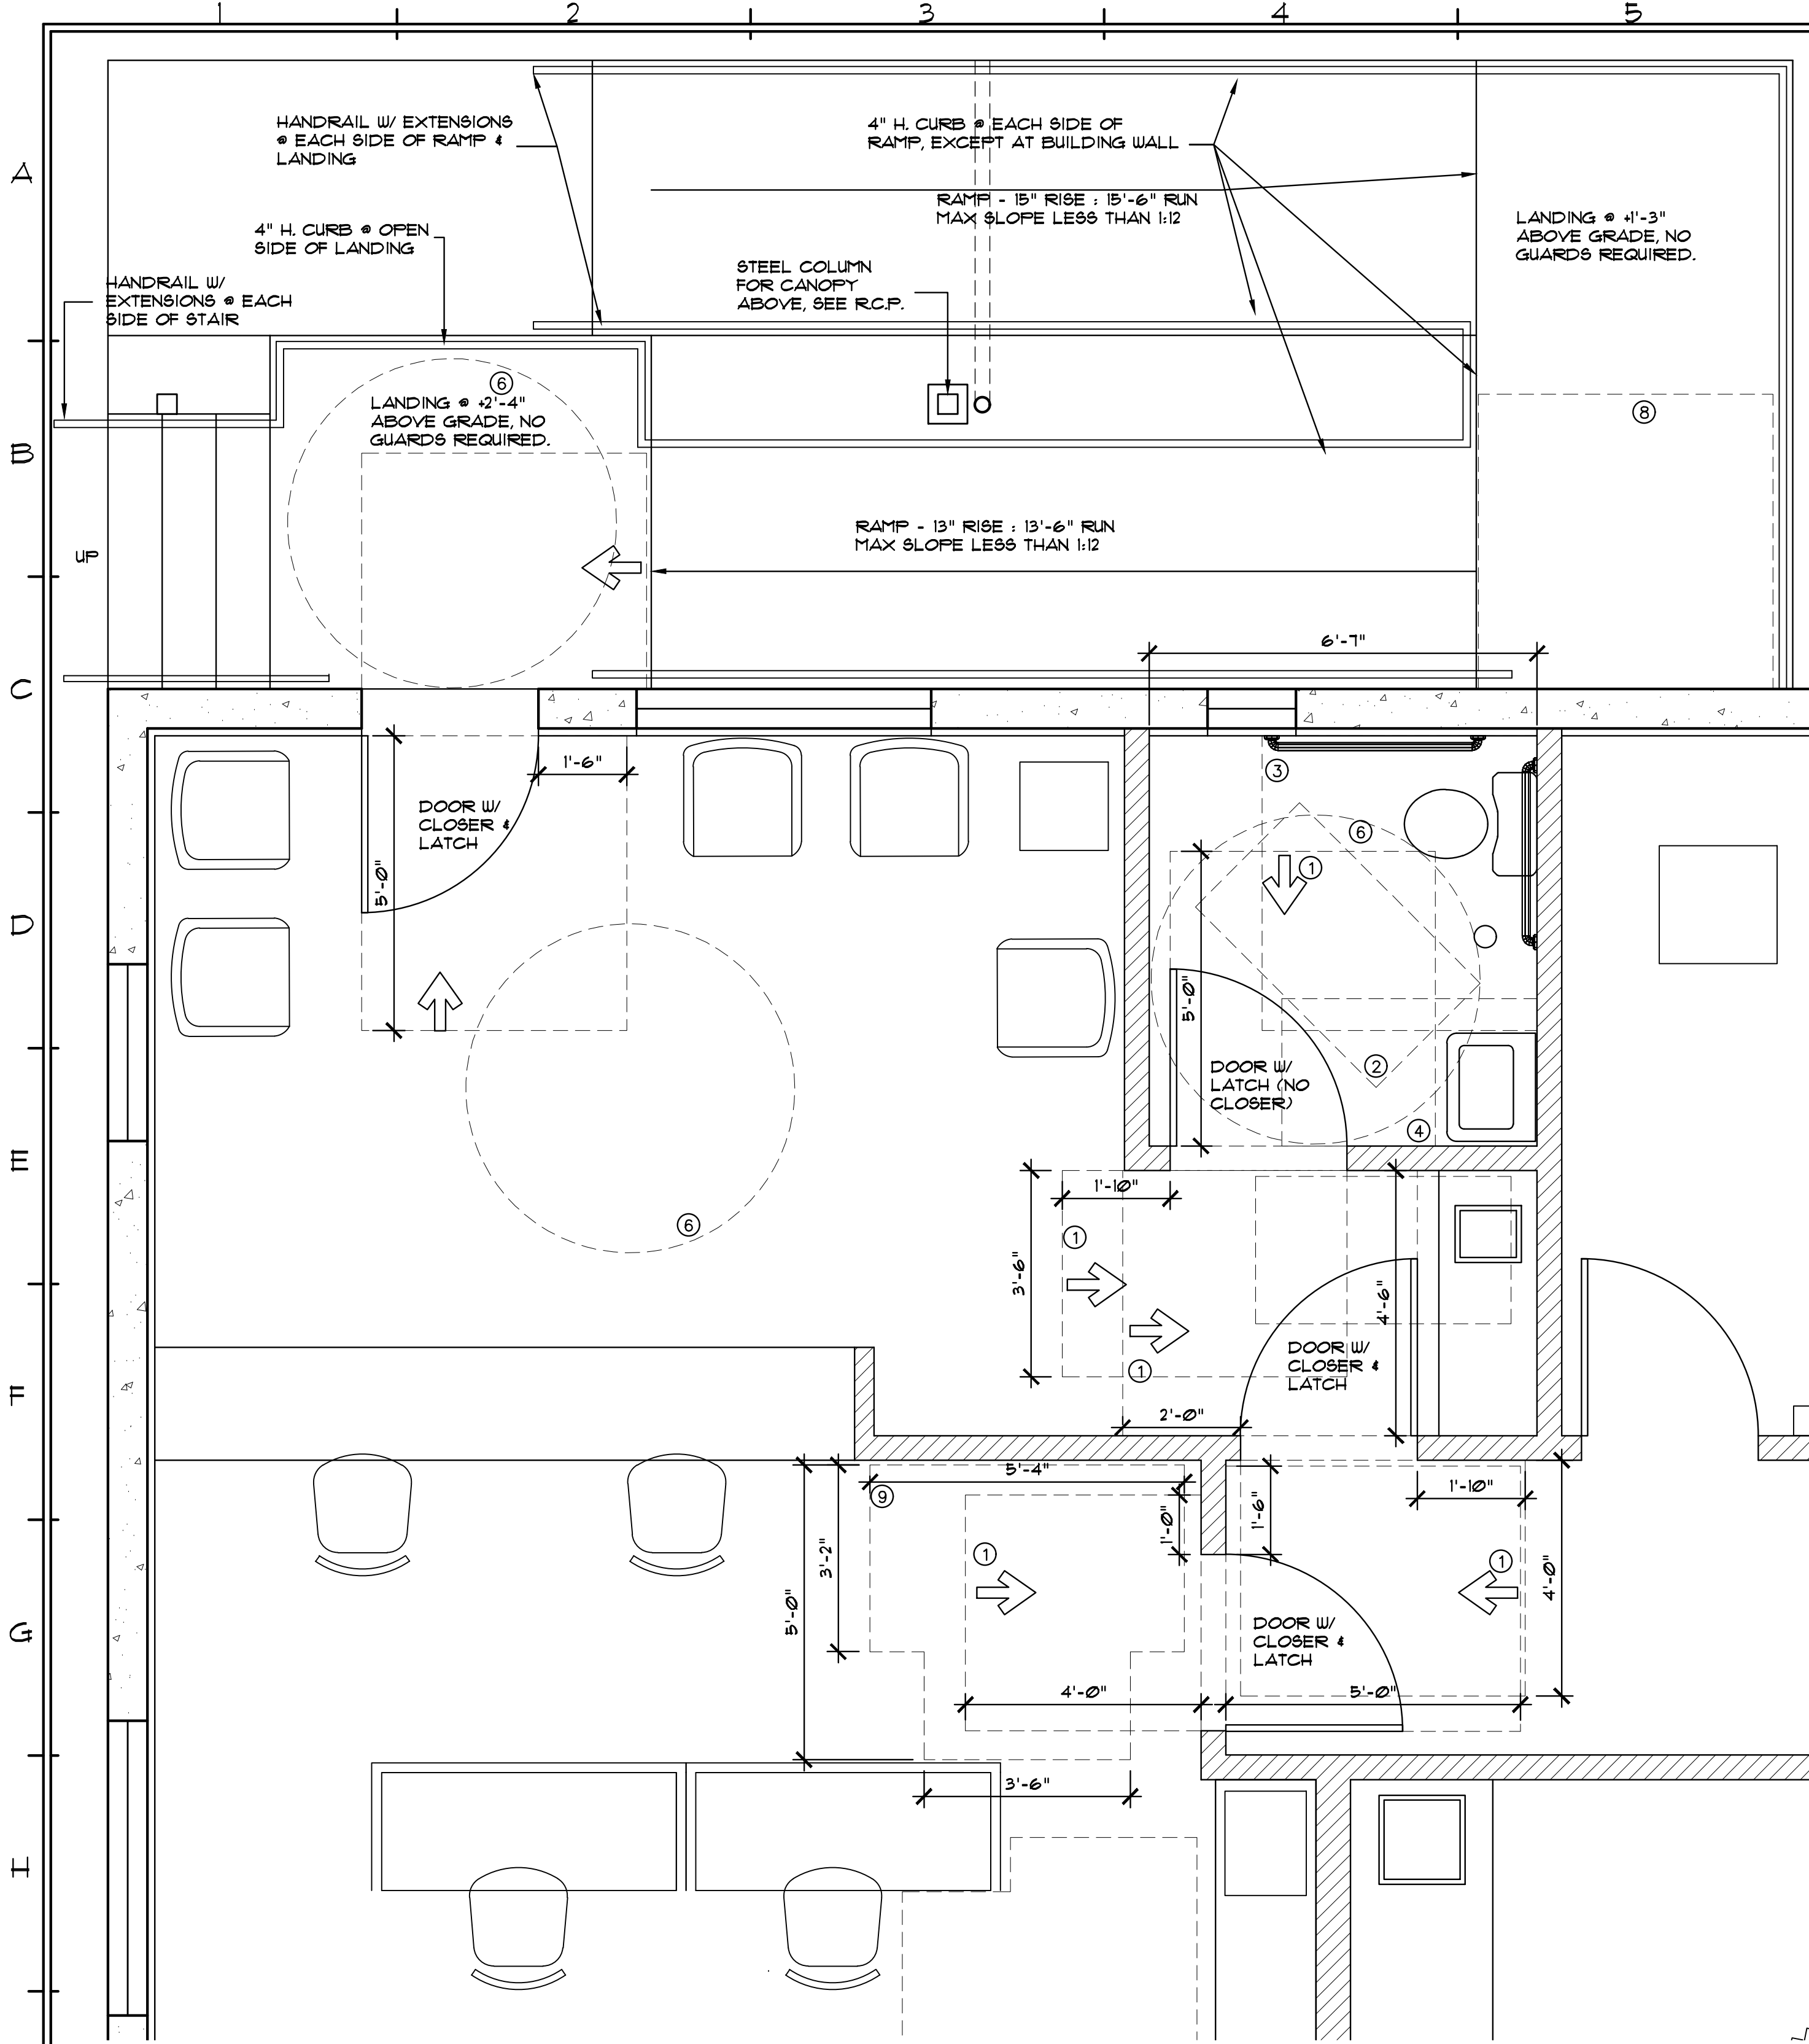

J1 ADA CLEARANCES - LOBBY & CUSTOMER RESTROOM

1/4"

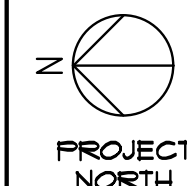

L5 ADA CLEARANCES - RESTROOMS, SHOWER & BREAK ROOM



1/4"

CLEARANCE NOTES

- 1 CLEAR FLOOR AREA * DOOR, SEE PLAN FOR DIMENSIONS
- 2 30" x 52" CLEAR FLOOR AREA (OUTSIDE OF DOOR SWING)
- 3 60" W. x 56" D. CLEAR FLOOR AREA * TOILET
- 4 30" x 52" CLEAR FLOOR AREA * LAVATORY
- 5 30" x 52" CLEAR FLOOR AREA * KITCHEN SINK, WORKSURFACE OR APPLIANCE
- 6 61" DIAM. TURNING CIRCLE
- 7 36" x 52" CLEAR FLOOR AREA * TRANSFER SHOWER
- 8 60" x 60" CLEAR FLOOR AREA * RAMP LANDING WITH TURN
- 9 64" x 60" T-SHAPED TURNING SPACE - NEW BUILDINGS - OPTION 2

C9 ADA CLEARANCE KEYNOTES


**DESIGN DEVELOPMENT
NOT FOR CONSTRUCTION**

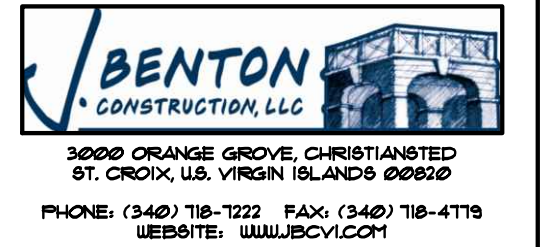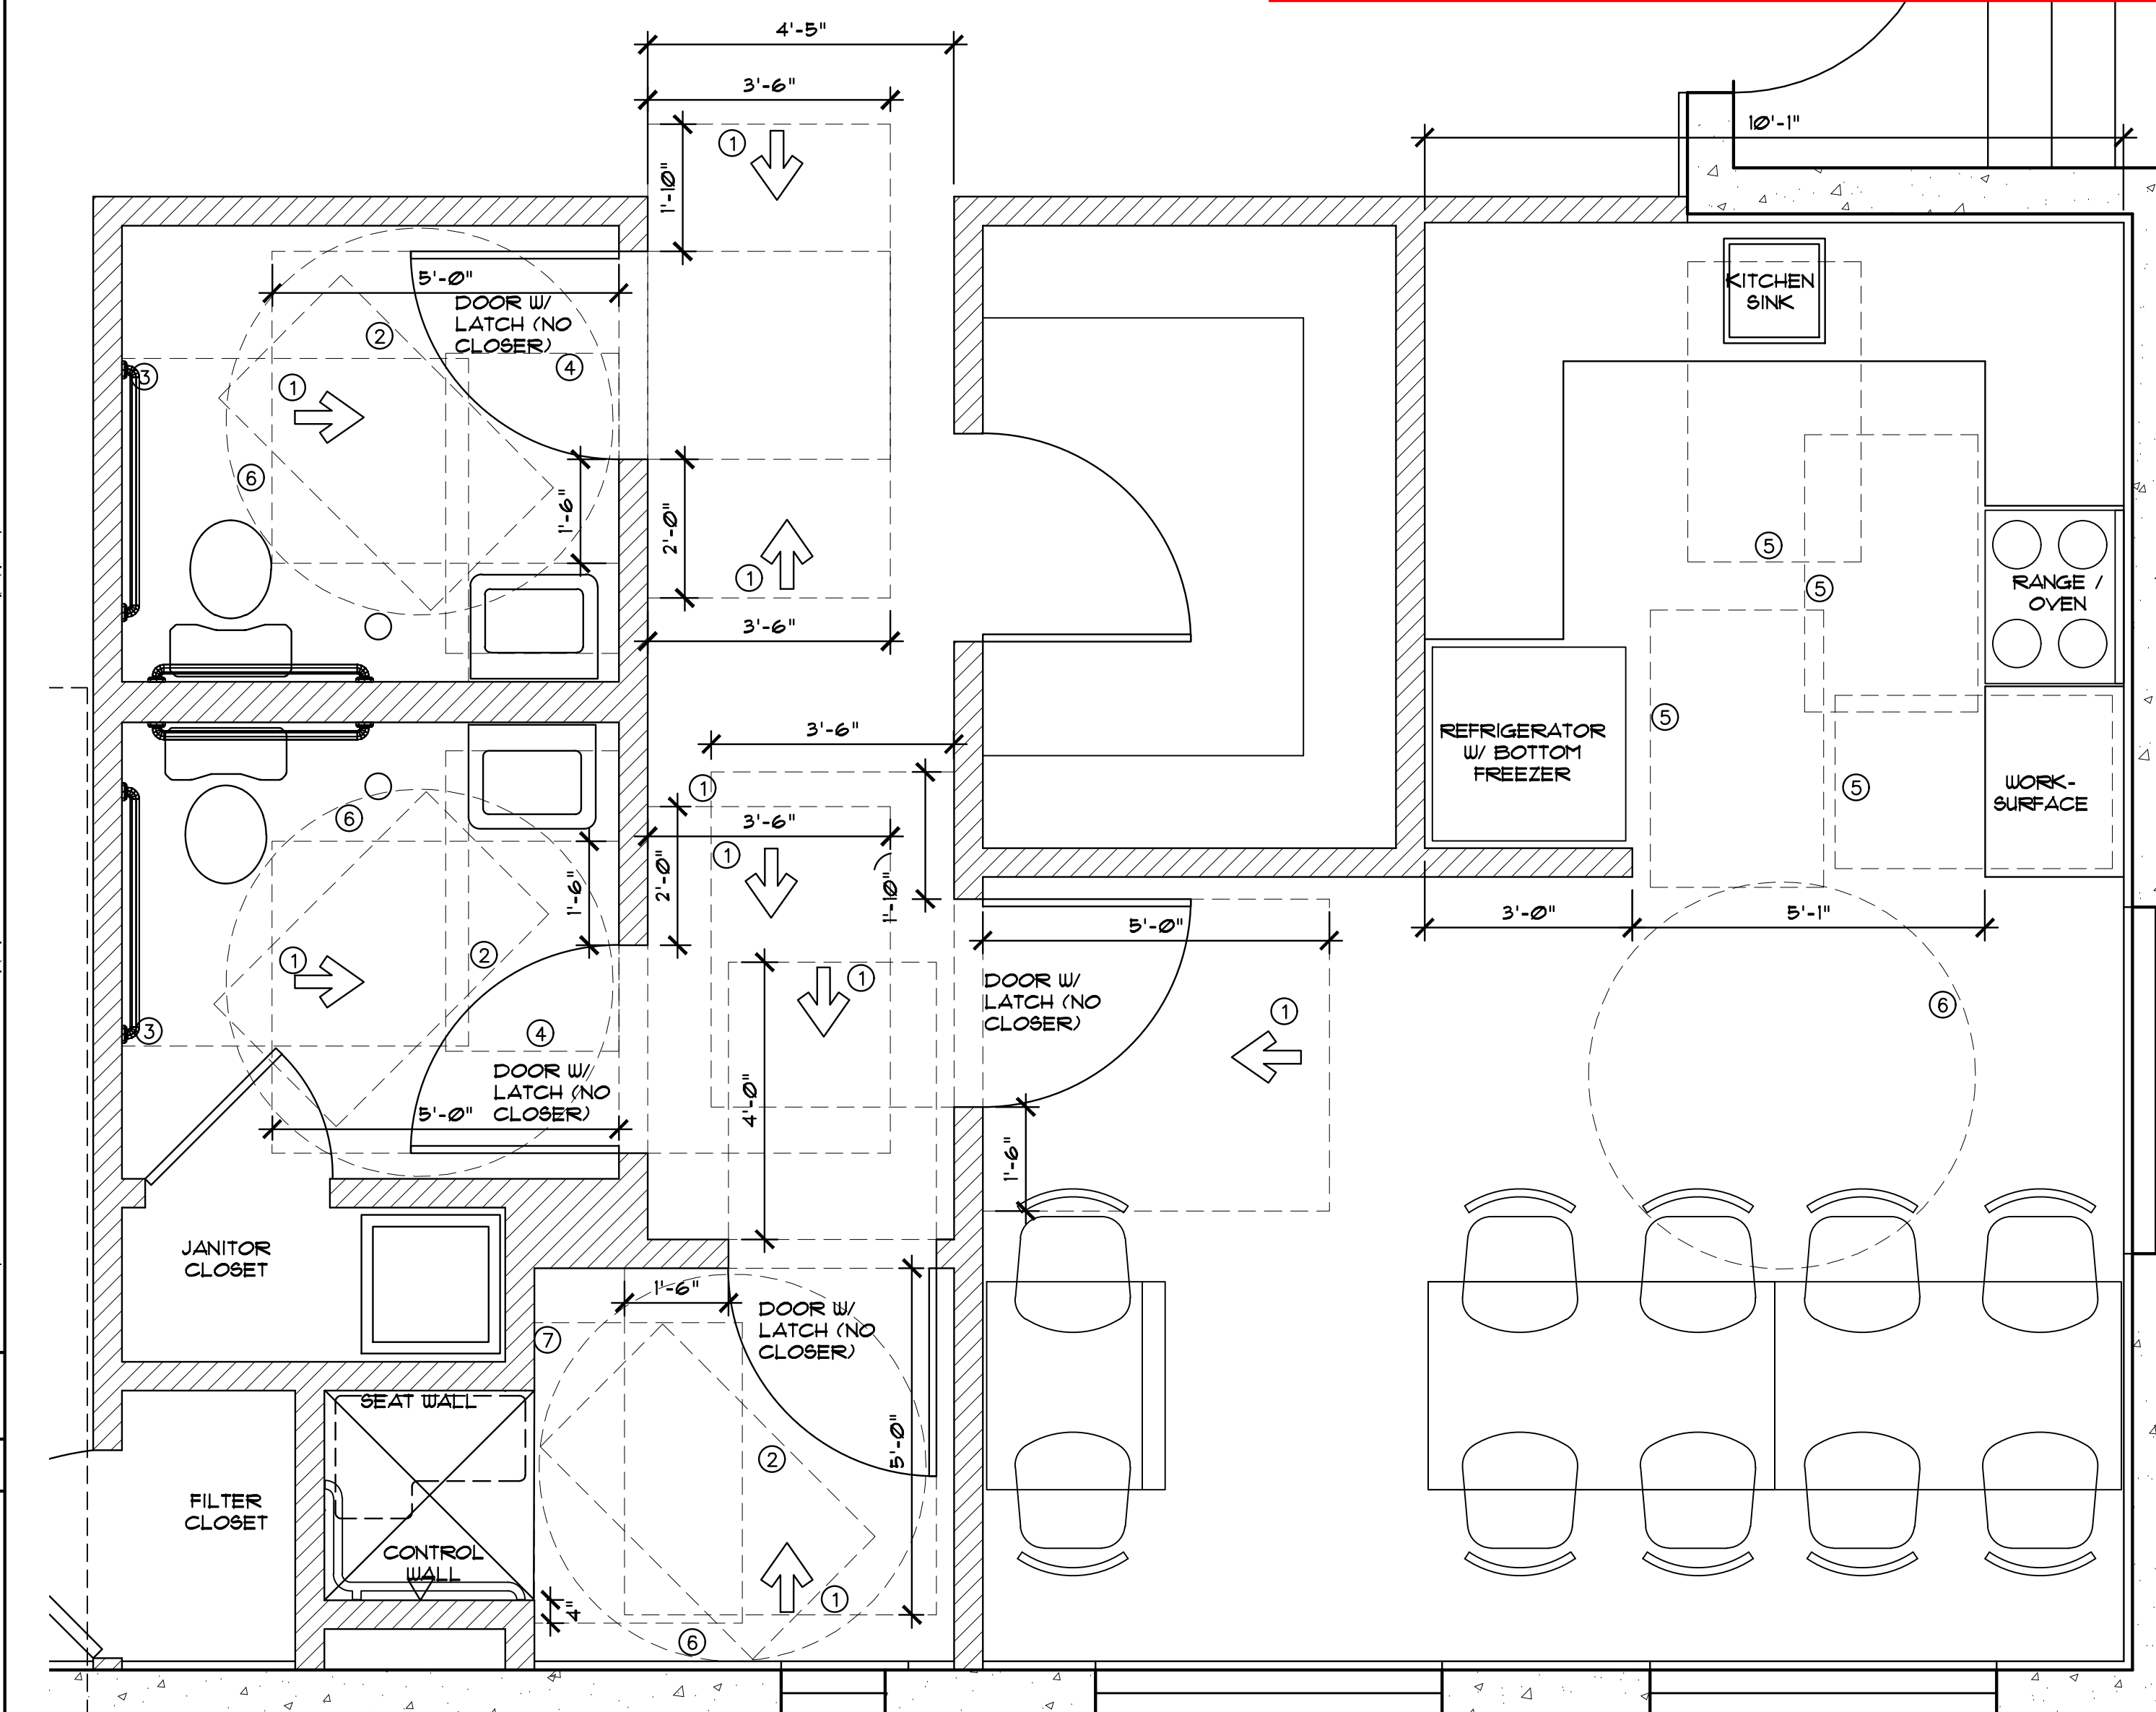


ARCHITECT



MEP ENGINEER

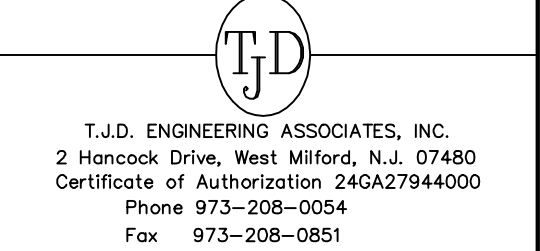

STRUCTURAL ENGINEER

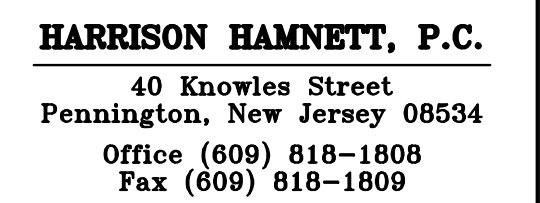

OWNER



PROFESSIONAL SEAL:

THIS DRAWING SHALL NOT BE USED FOR CONSTRUCTION UNLESS A PROFESSIONAL'S SEAL AND SIGNATURE ARE ON THE DRAWING

PROJECT TITLE / DESCRIPTION:
TROPICAL SHIPPING
NEW OFFICES

FACILITY LOCATION:
TROPICAL SHIPPING LLC,
(LEASED PLOT)
PLOT NO. 8
EAST HOPE (H.O.V.I.C. LANDS)
QUEEN'S QUARTER, ST. CROIX USVI

DATE:
5-28-24


NO.	REVISION:	DATE:

PROJECT NUMBER:
22254

DRAWING TITLE:
ADA CLEARANCE
PLANS

SHEET NUMBER:
A402

SHEET OF

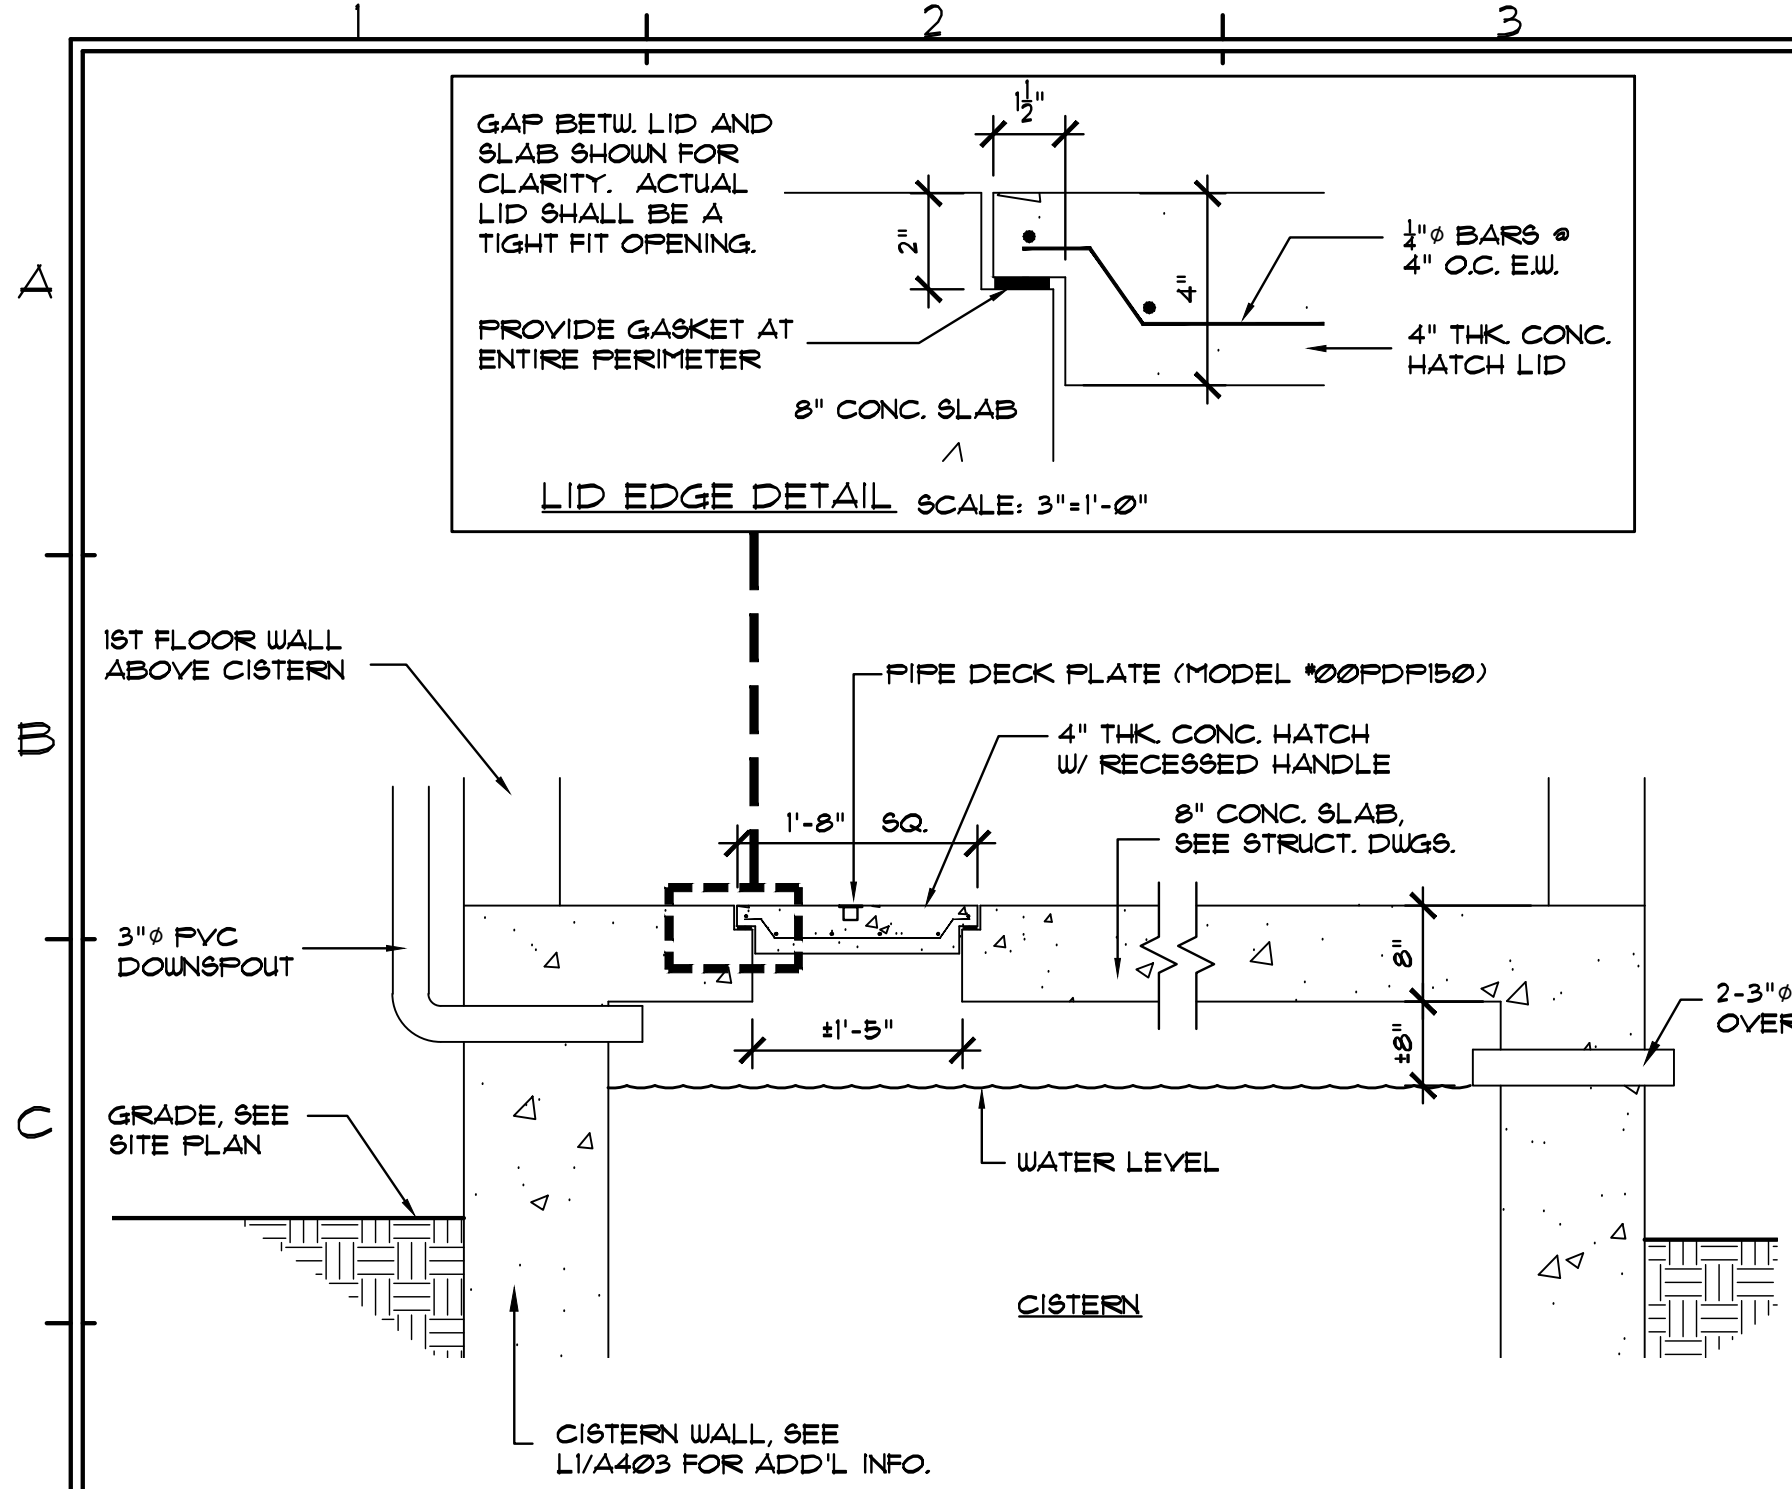


D1 CISTERN MANHOLE DETAIL

N.T.S.




G1 CISTERN FILL PORT DETAIL

N.T.S.

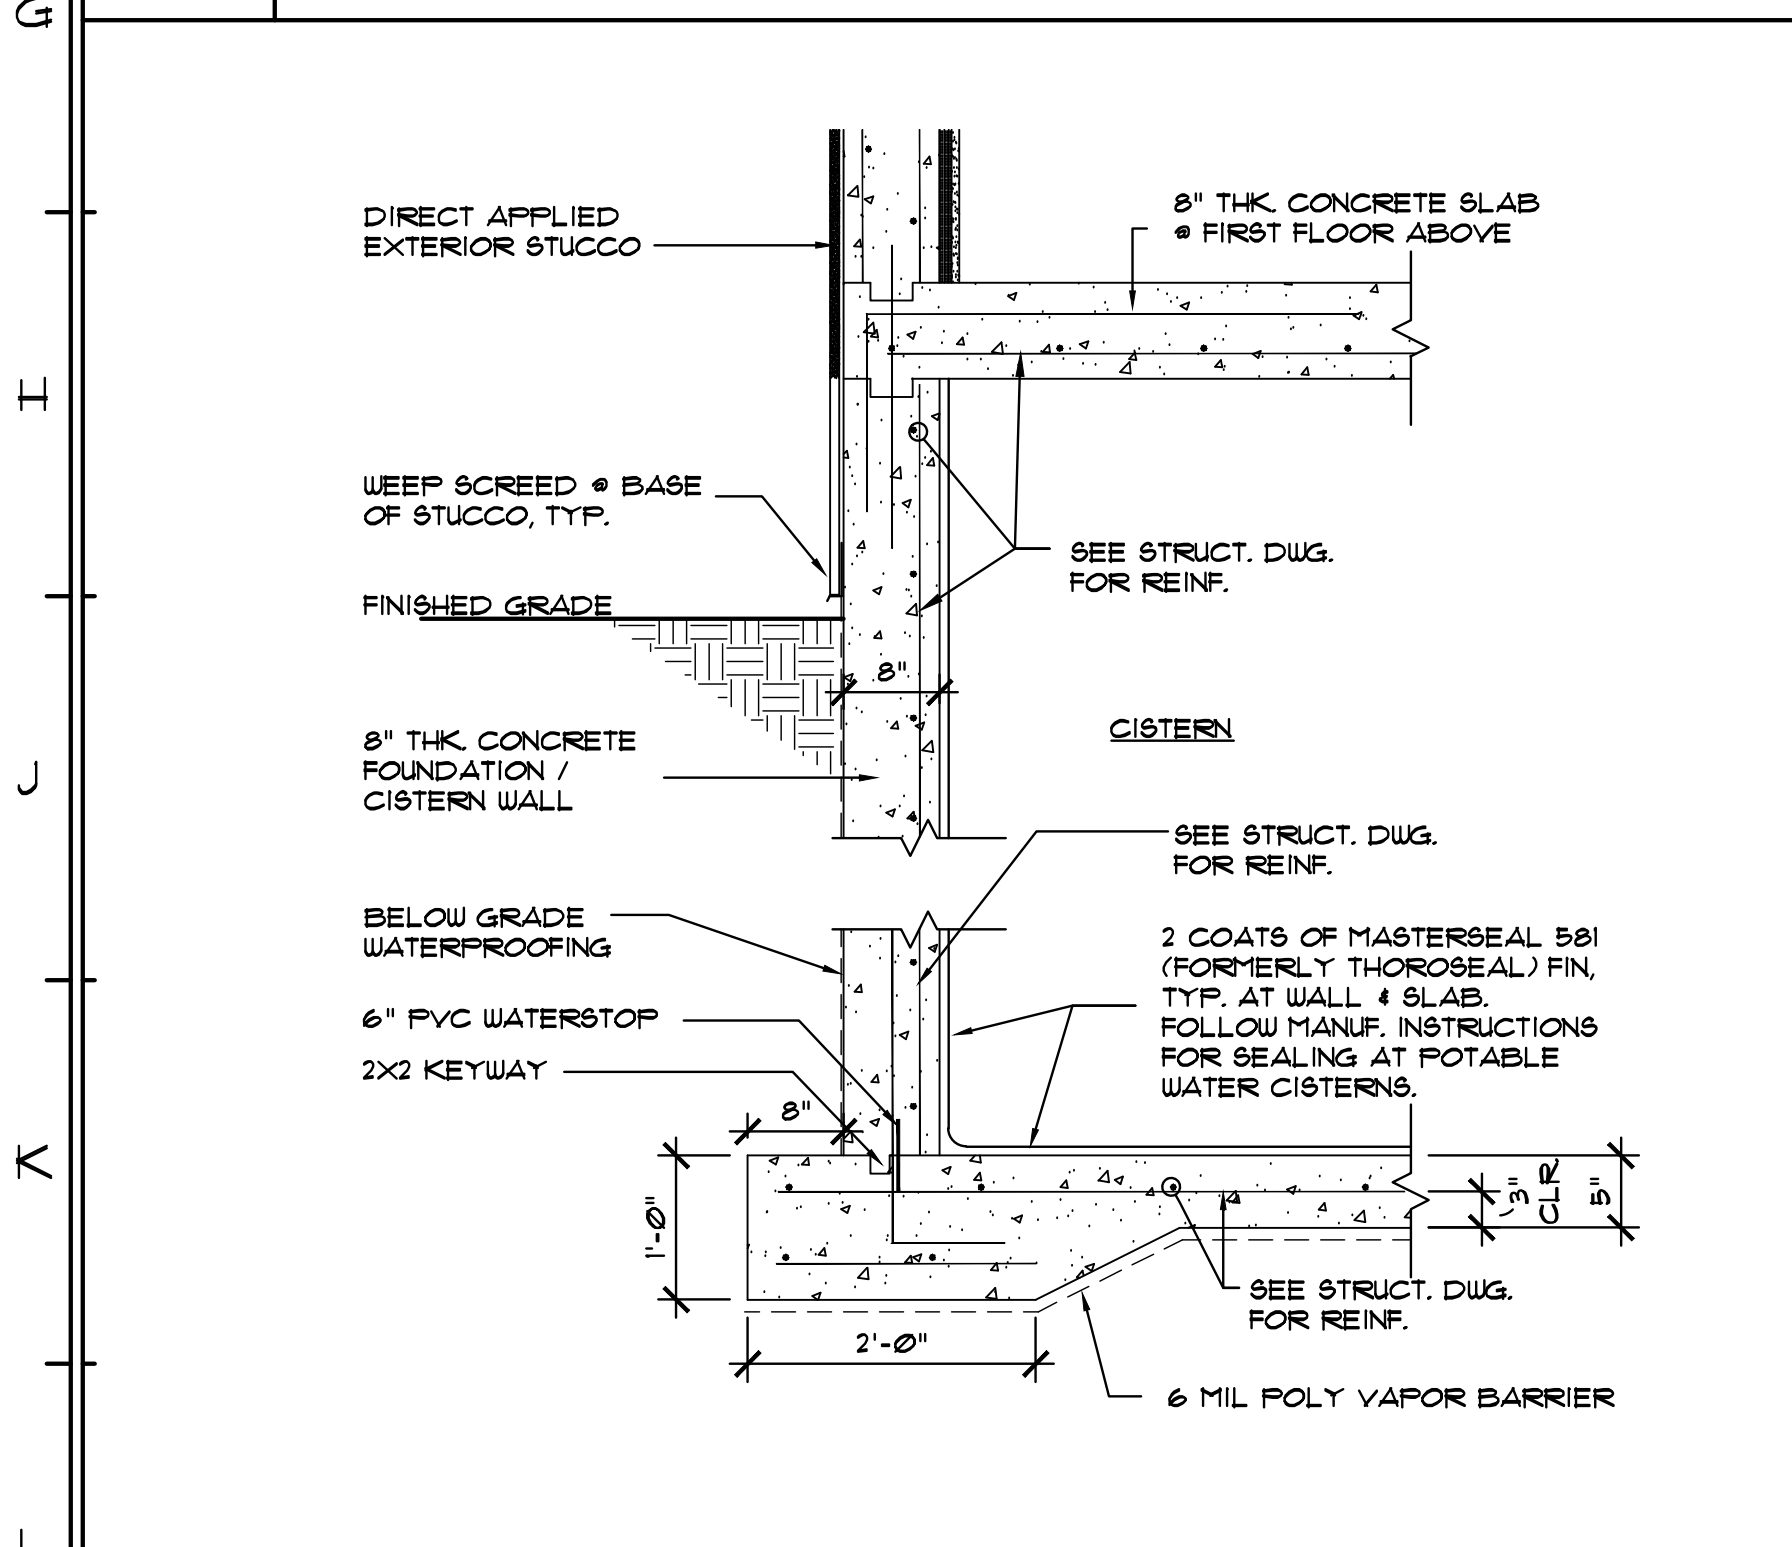


L1 CISTERN WALL DETAIL

3/4"

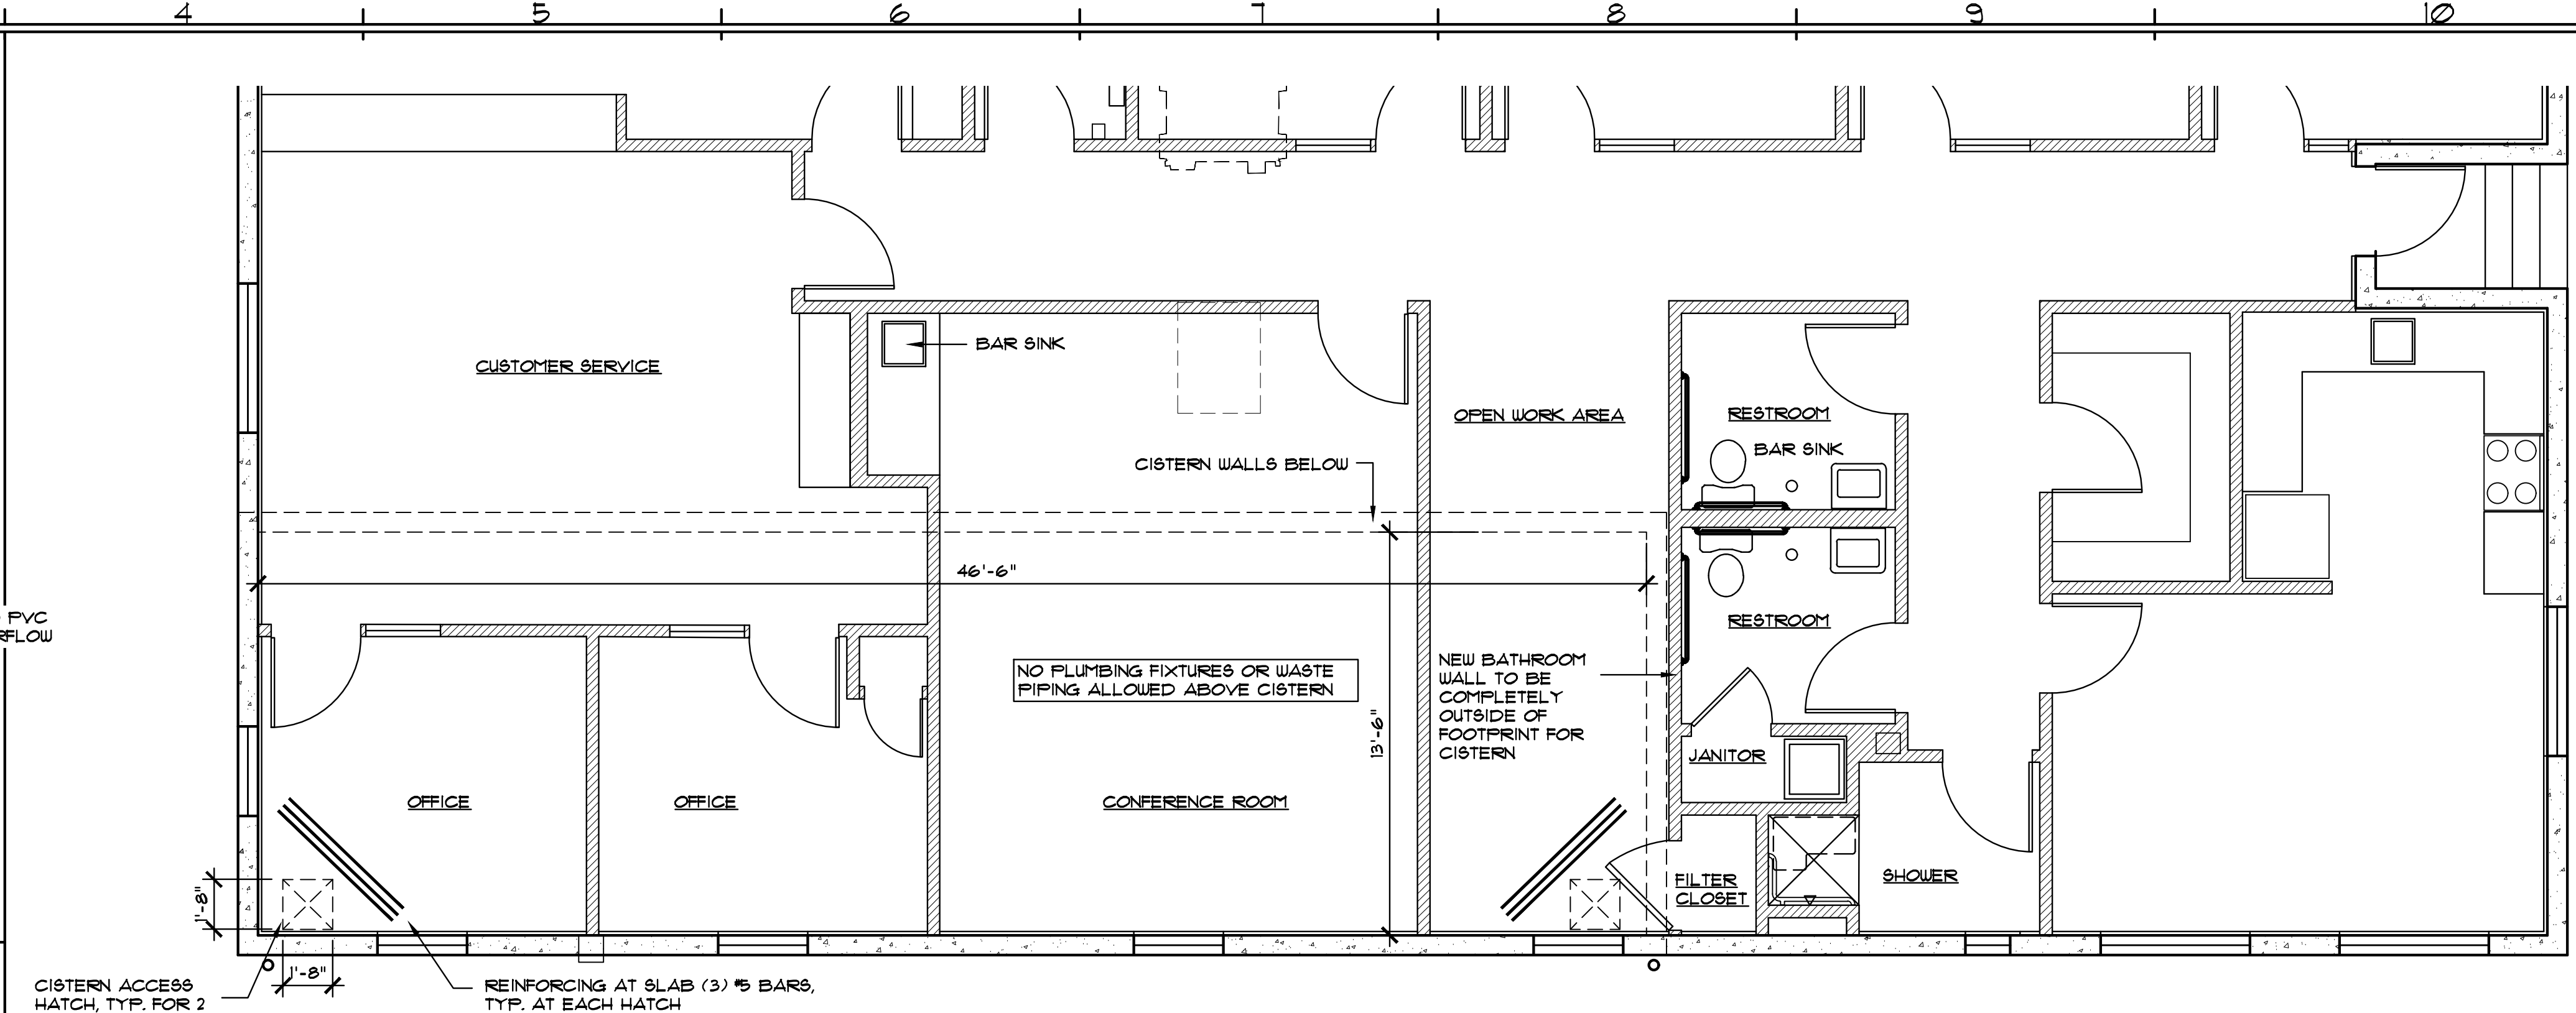

E4 PARTIAL FIRST FLOOR PLAN

1/4"

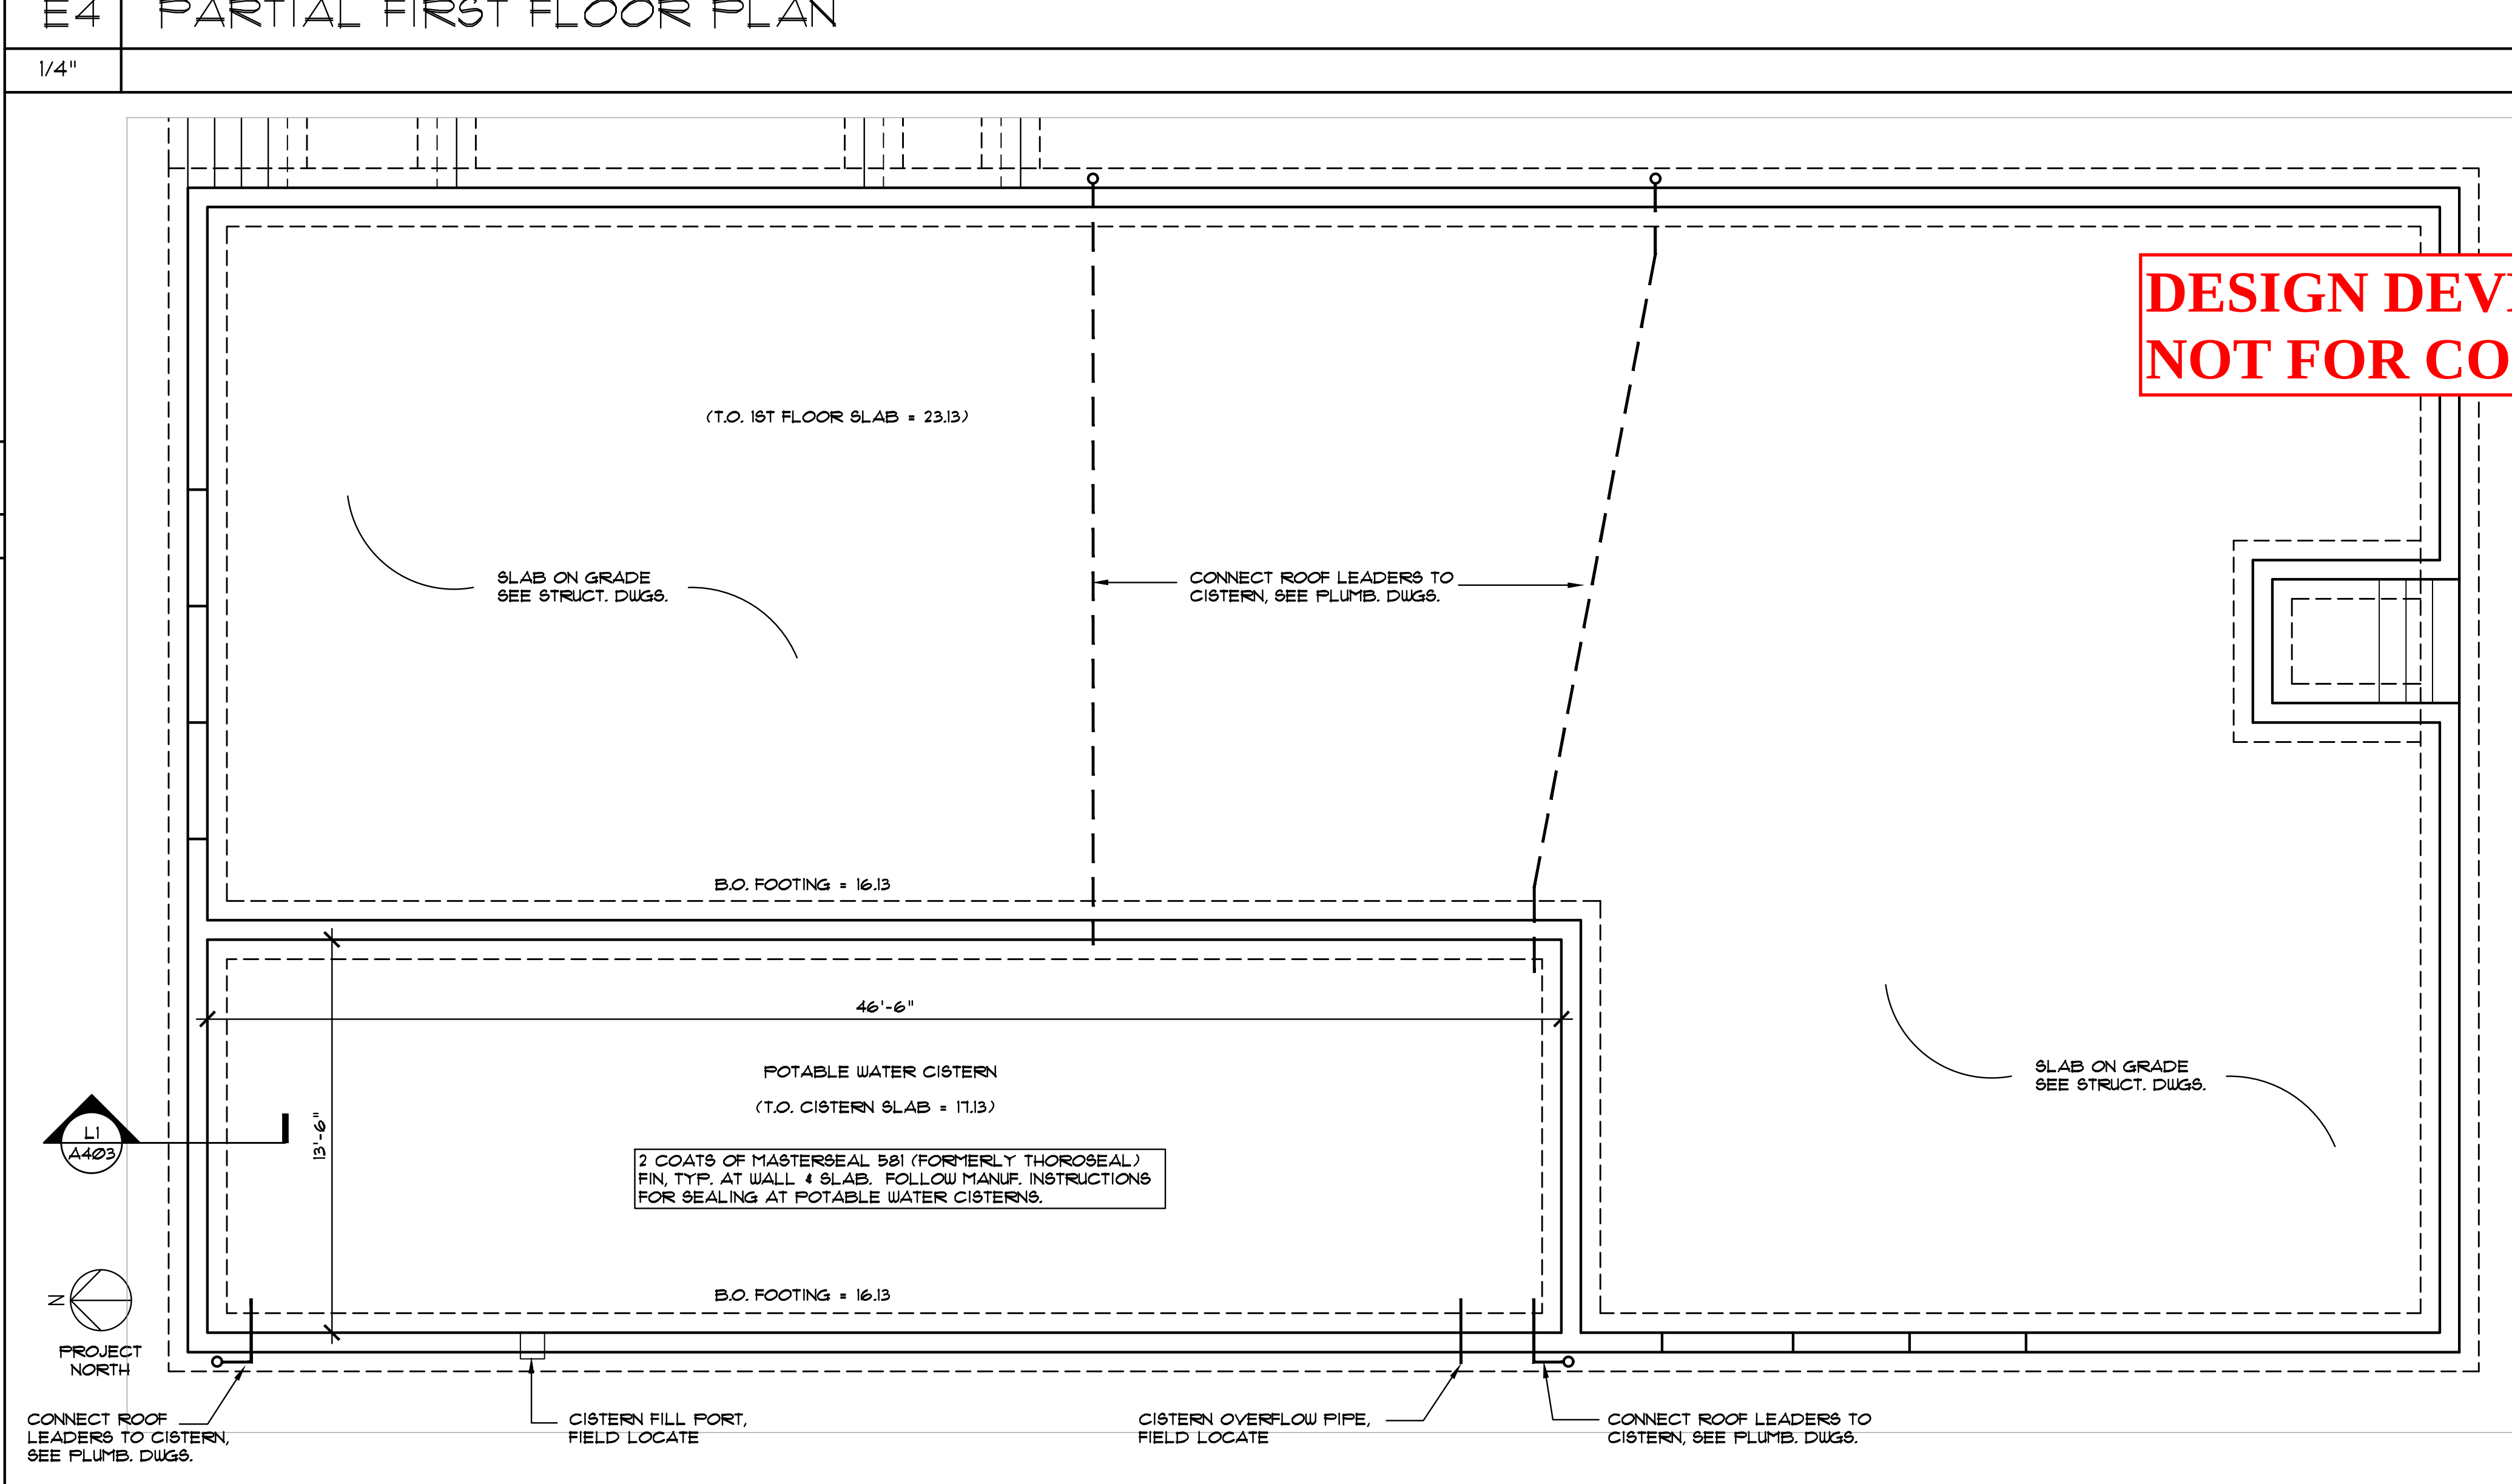

L4 FLOOR PLAN

1/4"




ARCHITECT



MEP ENGINEER



STRUCTURAL ENGINEER

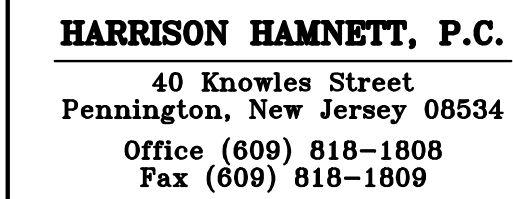

OWNER



PROFESSIONAL SEAL:

DESIGN DEVELOPMENT
NOT FOR CONSTRUCTION

THIS DRAWING SHALL NOT BE USED FOR CONSTRUCTION UNLESS A PROFESSIONAL'S SEAL AND SIGNATURE ARE ON THE DRAWING

PROJECT TITLE / DESCRIPTION:
TROPICAL SHIPPING
NEW OFFICES

FACILITY LOCATION:
TROPICAL SHIPPING LLC.
(LEASED PLOT)
PLOT NO. 8
EAST HOPE (H.O.V.I.C. LANDS)
QUEEN'S QUARTER, ST. CROIX USVI

DATE:
5-28-24

NO.	REVISION:	DATE:



PROJECT NUMBER:
22254

DRAWING TITLE:
CISTERN PLAN
& DETAILS

SHEET NUMBER:

A403

SHEET OF

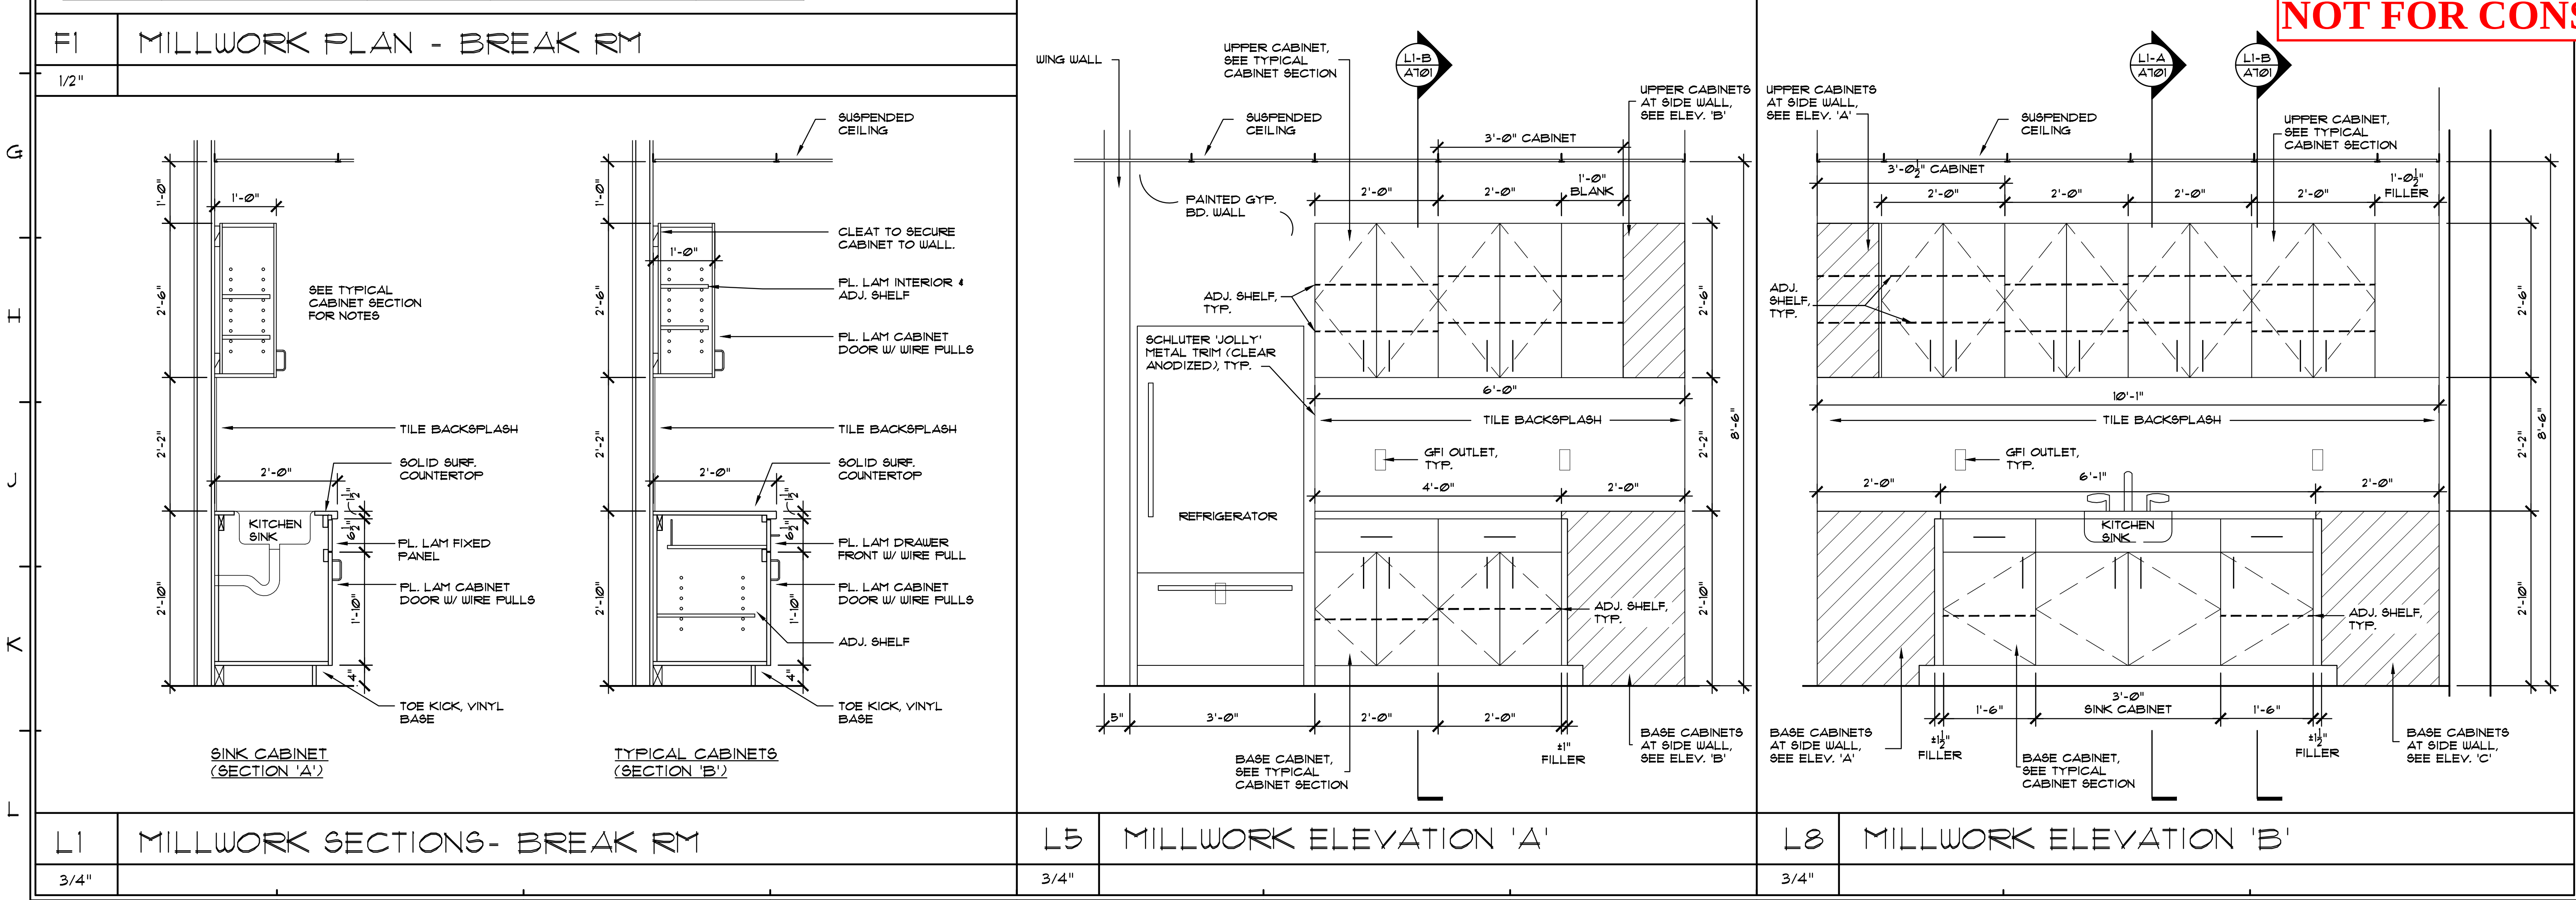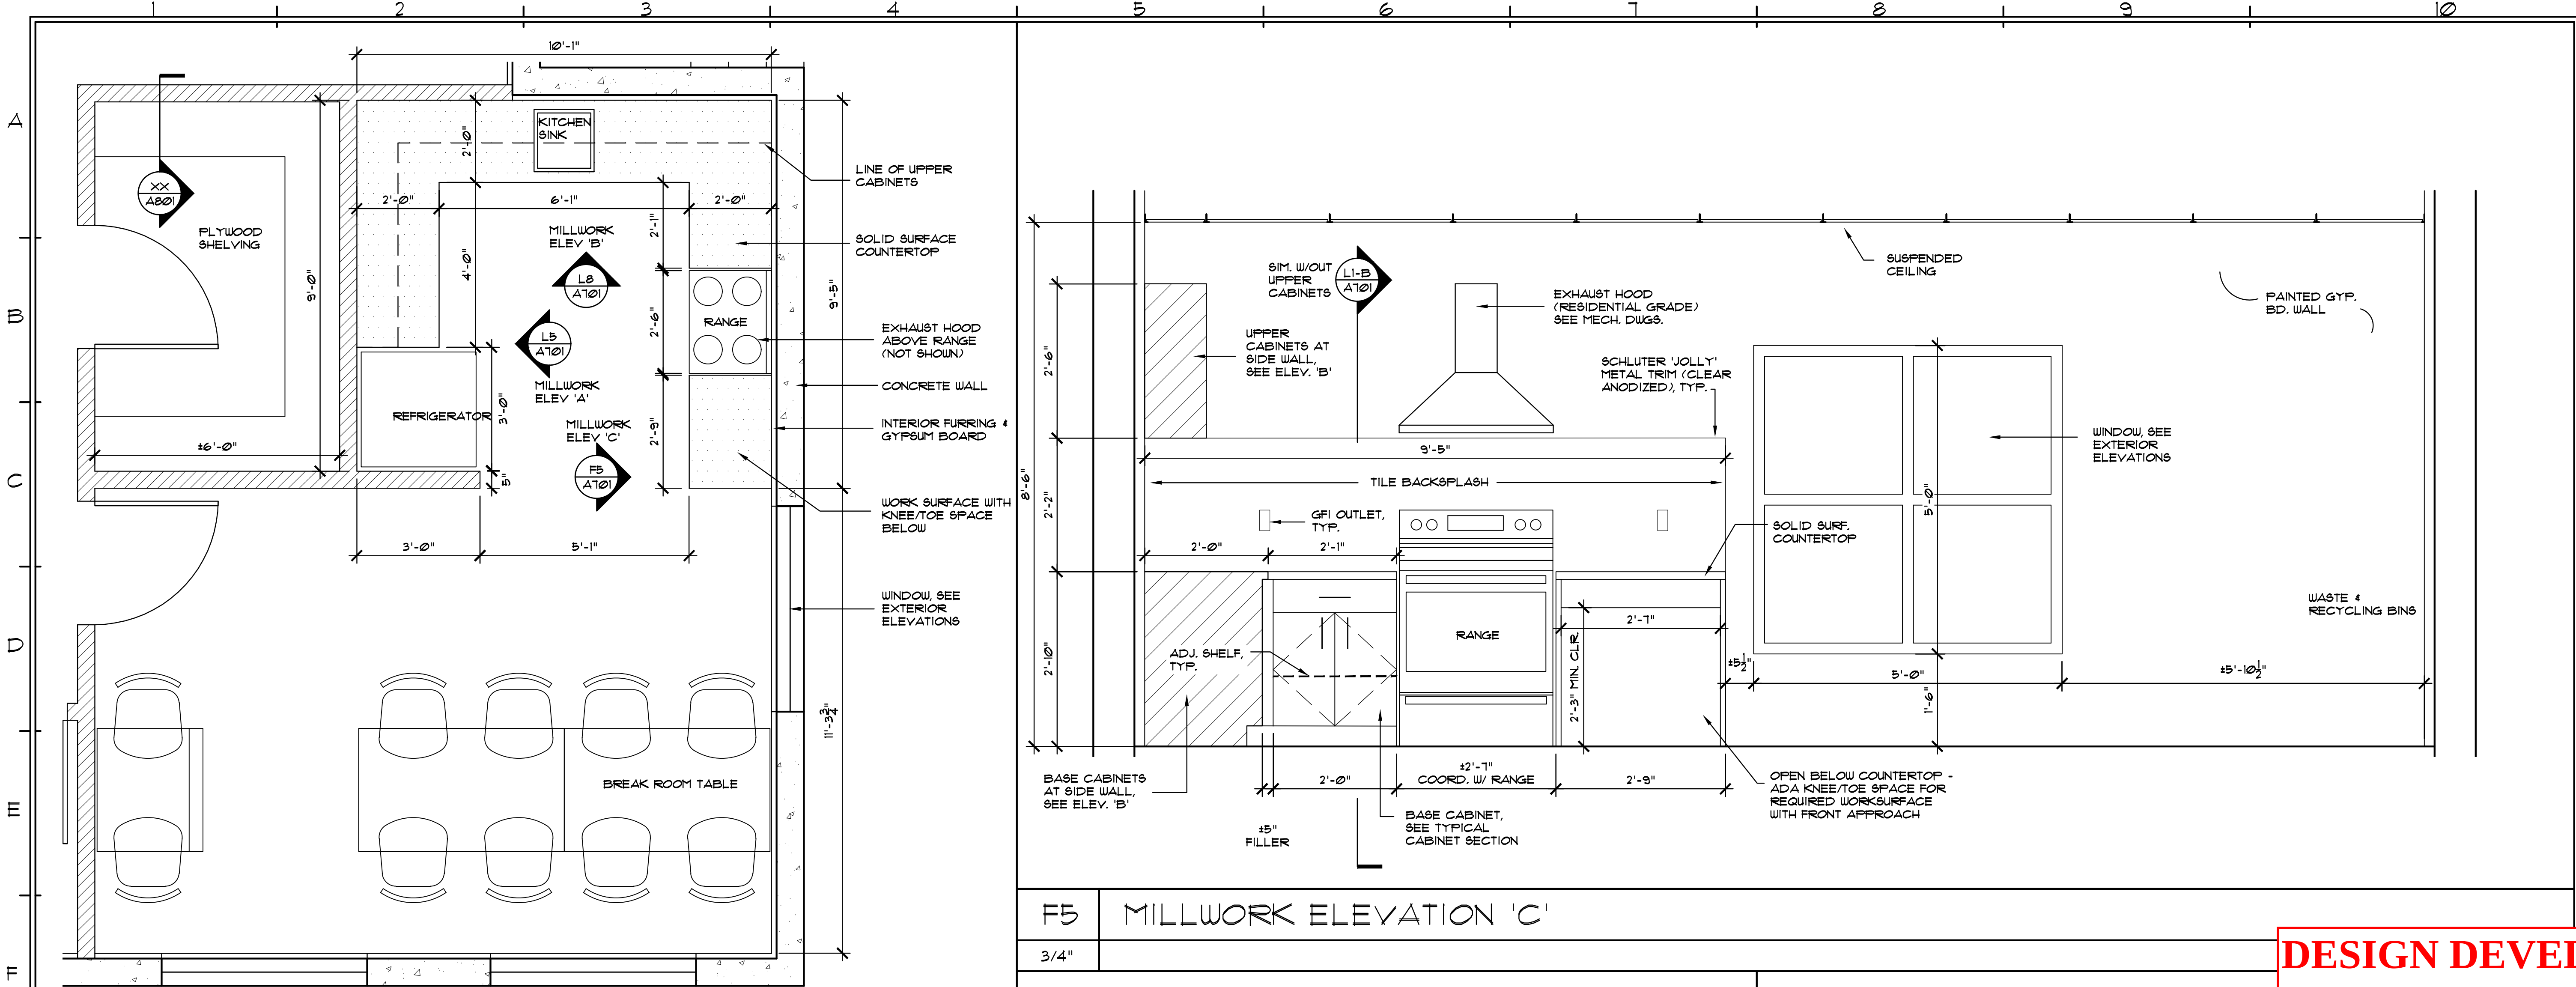

3000 ORANGE GROVE, CHRISTIANSTED
ST. CROIX, U.S. VIRGIN ISLANDS 00602
PHONE: (340) 718-1222 FAX: (340) 718-4175
WEBSITE: WWW.BCV.COM

ARCHITECT

55 COMPANY STREET, SUITE B, CHRISTIANSTED
ST. CROIX, U.S.V.I. 00602
NU PHONE: (609) 521-1861 NU FAX: (609) 521-8326

MEP ENGINEER

T.J.D. ENGINEERING ASSOCIATES, INC.
2 Hancock Drive, West Milford, N.J. 07480
Certificate of Authorization 24CA27944000
Phone 973-208-0054
Fax 973-208-0851

STRUCTURAL ENGINEER

HARRISON HAMNETT, P.C.
40 Knowles Street
Pennington, New Jersey 08534
Office (609) 818-1808
Fax (609) 818-1809

OWNER

PROFESSIONAL SEAL:

THIS DRAWING SHALL NOT BE USED FOR
CONSTRUCTION UNLESS A PROFESSIONAL'S
SEAL AND SIGNATURE ARE ON THE DRAWING

PROJECT TITLE / DESCRIPTION:
TROPICAL SHIPPING
NEW OFFICES

FACILITY LOCATION:
TROPICAL SHIPPING LLC.
(LEASED PLOT)

PLOT NO. 8
EAST HOPE (H.O.V.I.C. LANDS)
QUEEN'S QUARTER, ST. CROIX USVI

DATE:
5-28-24


NO. REVISION: DATE:

PROJECT NUMBER:
22254


DRAWING TITLE:
BREAK ROOM
MILLWORK

SHEET NUMBER:
A701

SHEET OF

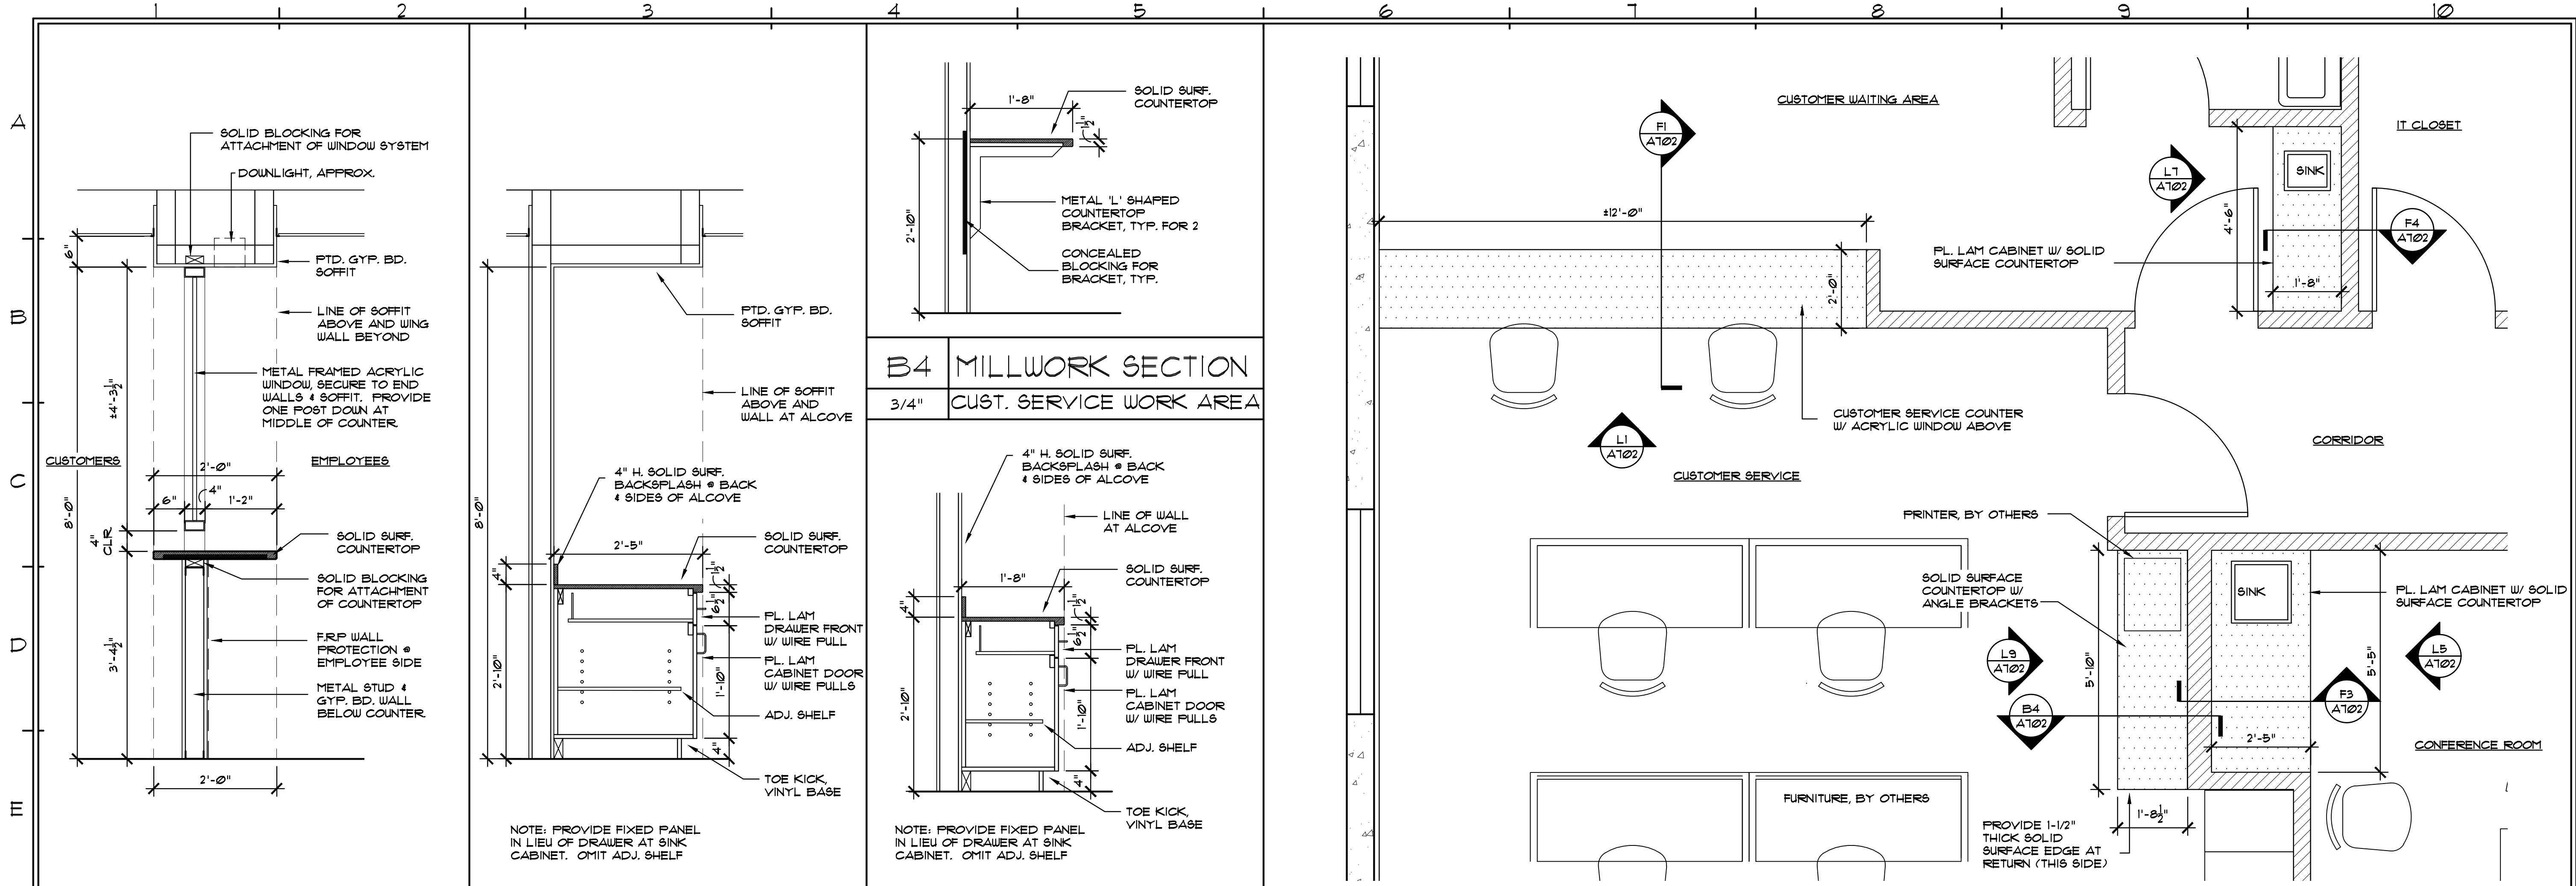

F1	MILLWORK SECTION	F3	MILLWORK SECTION	F4	MILLWORK SECTION	F6	MILLWORK PLAN - CUSTOMER SERVICE, WAITING & CONFERENCE RM.
3/4"	CUSTOMER SERVICE COUNTER	3/4"	CONFERENCE ROOM	3/4"	WAITING AREA	1/2"	

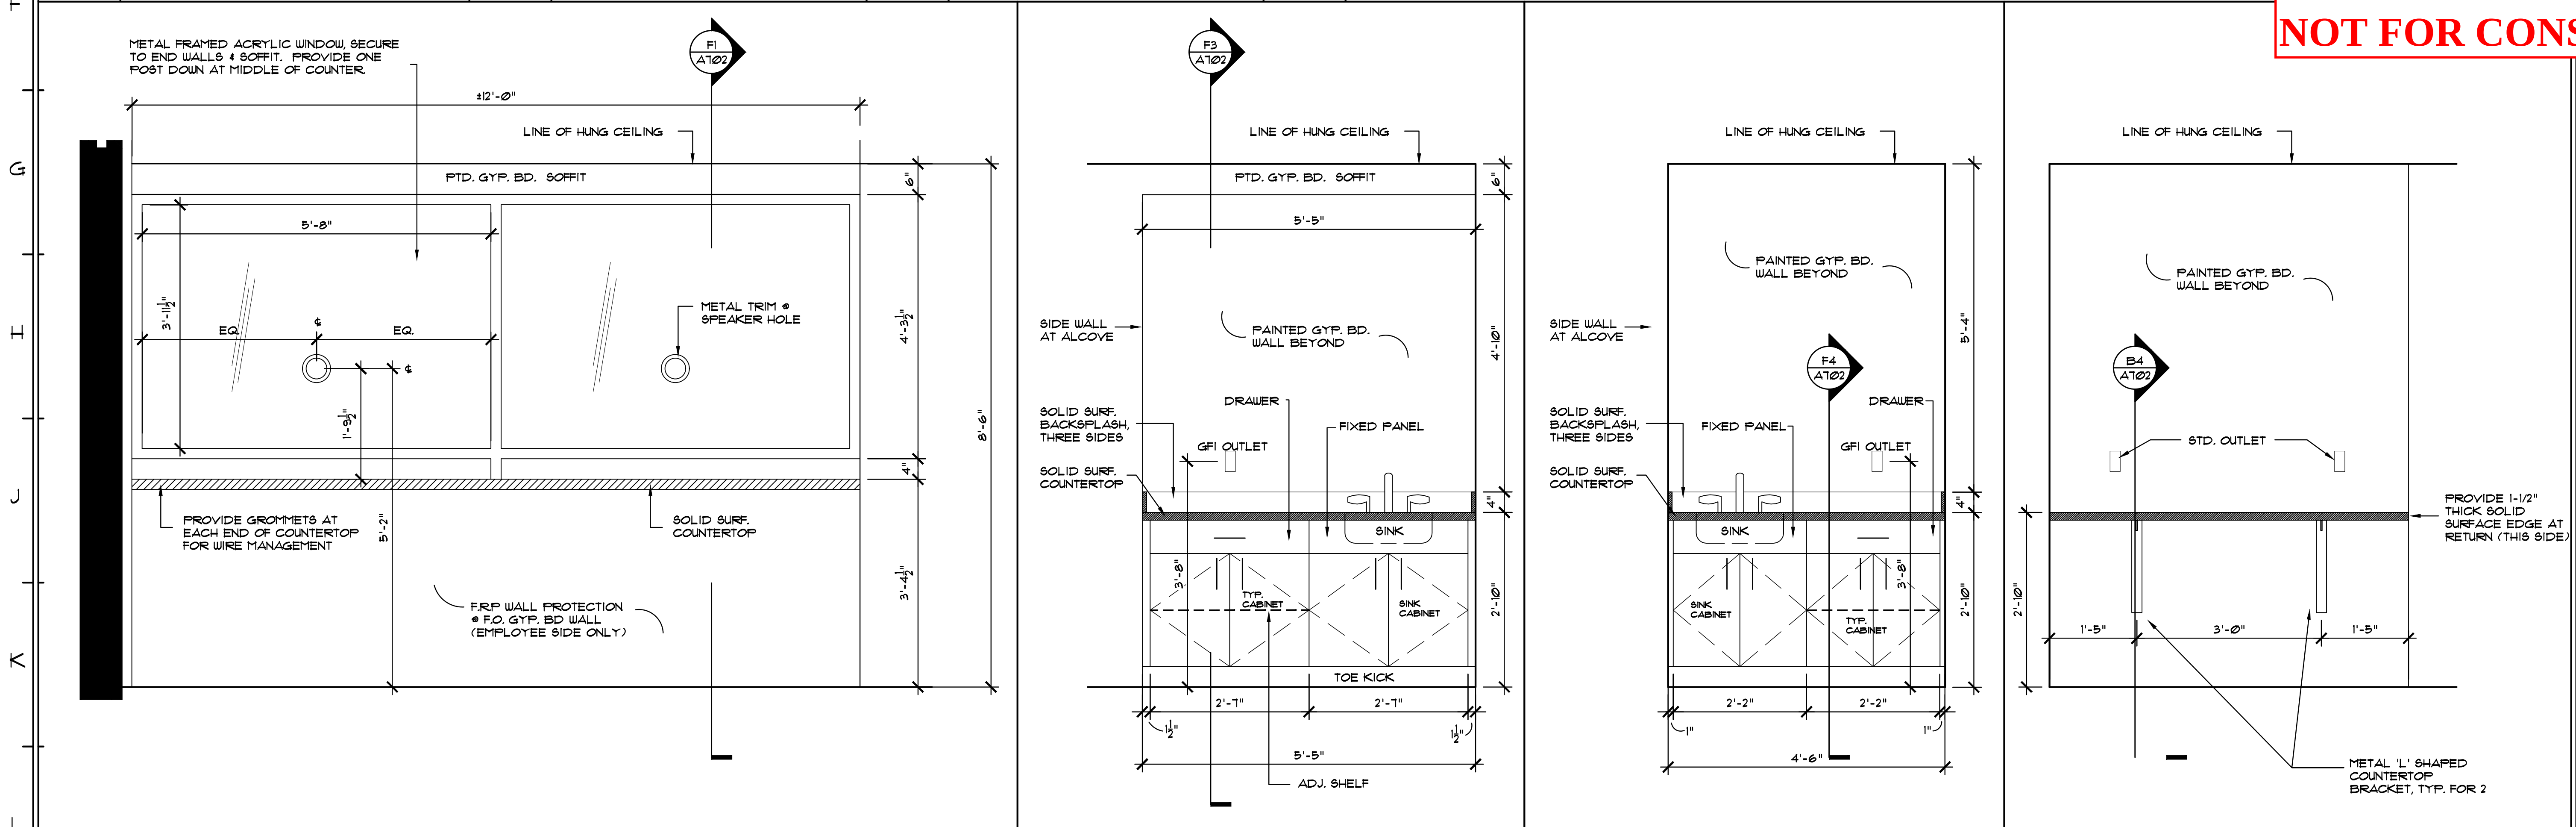

L1	MILLWORK ELEVATION - CUST. SERVICE COUNTER	L5	MILLWORK ELEVATION	L7	MILLWORK ELEVATION	L9	MILLWORK ELEVATION
3/4"		3/4"	CONFERENCE ROOM	3/4"	CUSTOMER WAITING AREA	3/4"	CUSTOMER SERVICE WORK AREA

3000 ORANGE GROVE, CHRISTIANSTED
ST. CROIX, U.S. VIRGIN ISLANDS 00602
PHONE: (340) 718-1222 FAX: (340) 718-4175
WEBSITE: WWW.BCV.COM

ARCHITECT

SILVERBERG
ASSOCIATES V.I., P.C.
ARCHITECTS
55 COMPANY STREET, SUITE B, CHRISTIANSTED
ST. CROIX, U.S.V.I. 00602
U.S. PHONE: (609) 521-1861 U.S. FAX: (609) 521-8326

MEP ENGINEER

T.J.D. ENGINEERING ASSOCIATES, INC.
2 Hancock Drive, West Milford, N.J. 07480
Certificate of Authorization 24CA27944000
Phone 973-208-0054
Fax 973-208-0851

STRUCTURAL ENGINEER

HARRISON HAMNETT, P.C.
40 Knowles Street
Pennington, New Jersey 08534
Office (609) 818-1808
Fax (609) 818-1809

OWNER

PROFESSIONAL SEAL:

THIS DRAWING SHALL NOT BE USED FOR
CONSTRUCTION UNLESS A PROFESSIONAL'S
SEAL AND SIGNATURE ARE ON THE DRAWING

PROJECT TITLE / DESCRIPTION:
**TROPICAL SHIPPING
NEW OFFICES**

FACILITY LOCATION:
TROPICAL SHIPPING LLC.
(LEASED PLOT)
PLOT NO. 8
EAST HOPE (H.O.V.I.C. LANDS)
QUEEN'S QUARTER, ST. CROIX USVI

DATE:
5-28-24

NO.	REVISION	DATE

PROJECT NUMBER:
22254


DRAWING TITLE:
**CUST. SERVICE
MILLWORK**

SHEET NUMBER:
A702

SHEET OF

SHEET OF

Drawing name: C:\Users\Natalia\AppData\Local\Temp\AcPublish_22972\Tropical Shipping.dwg
Date: May 23, 2024 5:22pm

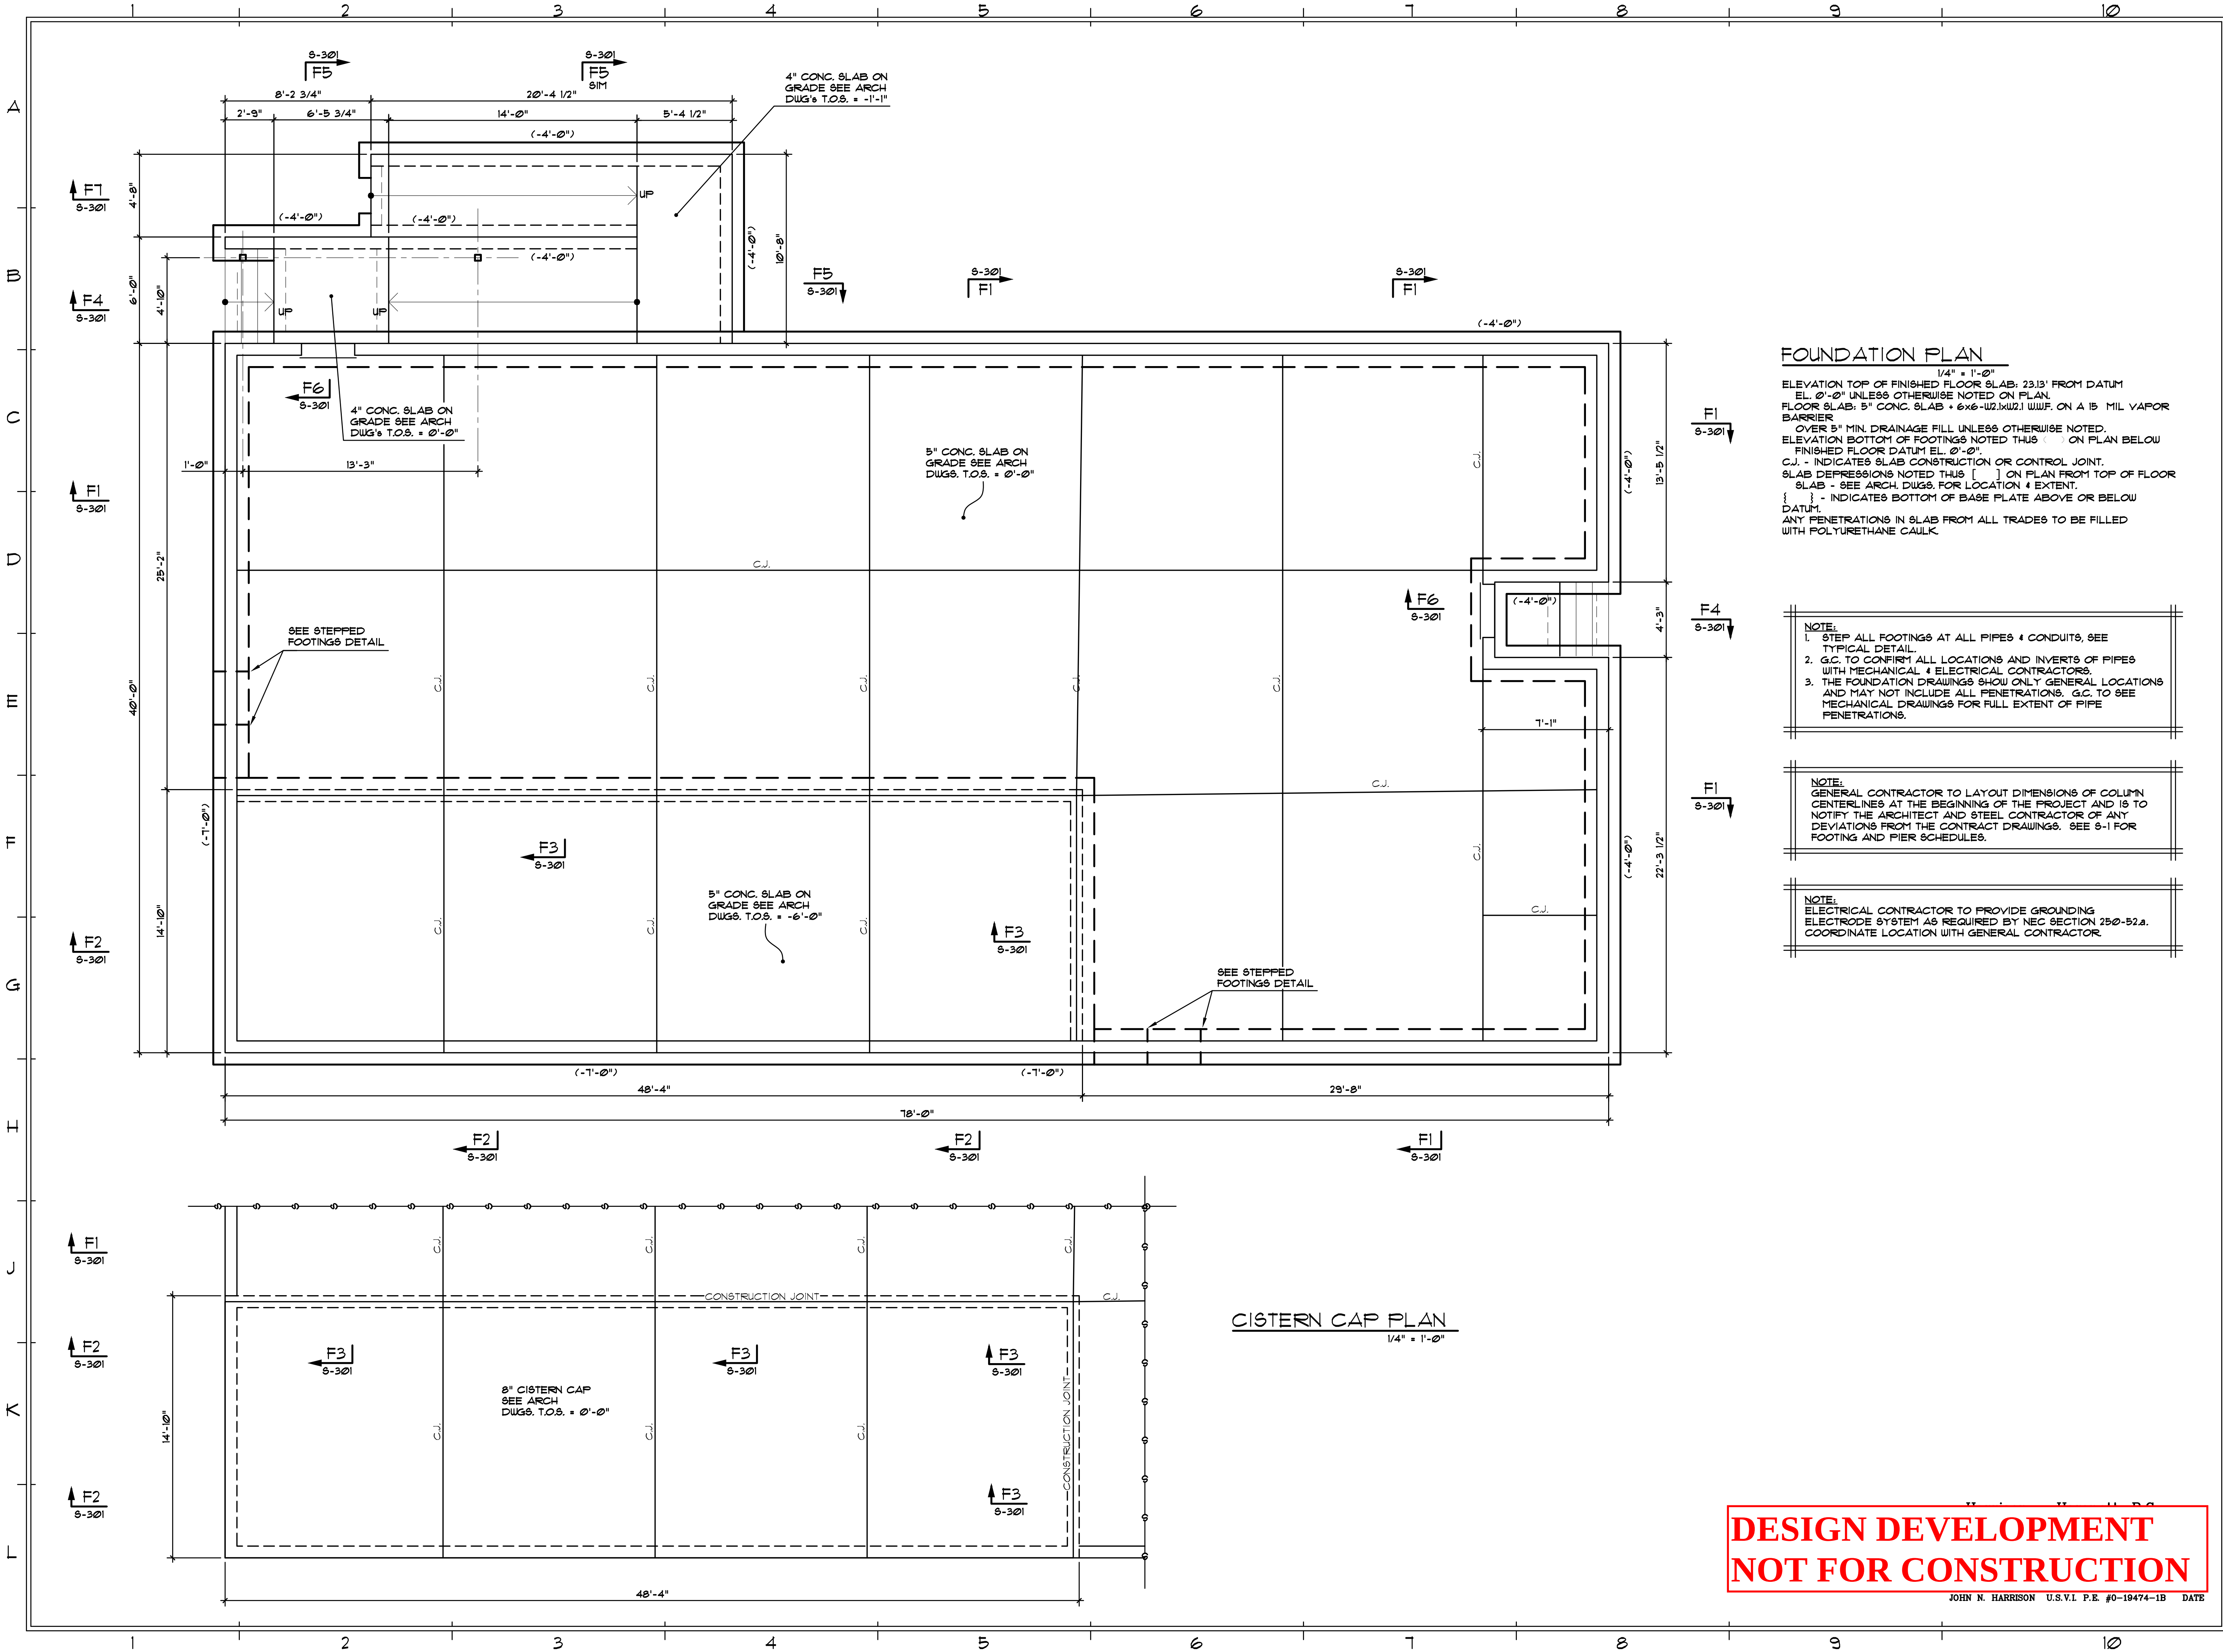

FOUNDATION PLAN
1/4" = 1'-0"

ELEVATION TOP OF FINISHED FLOOR SLAB: 23.13' FROM DATUM
EL. 0'-0" UNLESS OTHERWISE NOTED ON PLAN.
FLOOR SLAB: 5" CONC. SLAB + 6x6-W2.1xW2.1 W/WF. ON A 15 MIL VAPOR BARRIER
OVER 5" MIN. DRAINAGE FILL UNLESS OTHERWISE NOTED.
ELEVATION BOTTOM OF FOOTINGS NOTED THUS [] ON PLAN BELOW
FINISHED FLOOR DATUM EL. 0'-0".
C.J. - INDICATES SLAB CONSTRUCTION OR CONTROL JOINT.
SLAB DEPRESSIONS NOTED THUS [] ON PLAN FROM TOP OF FLOOR SLAB - SEE ARCH. DWGS. FOR LOCATION & EXTENT.
[] - INDICATES BOTTOM OF BASE PLATE ABOVE OR BELOW DATUM.
ANY PENETRATIONS IN SLAB FROM ALL TRADES TO BE FILLED WITH POLYURETHANE CAULK.

NOTE:
1. STEP ALL FOOTINGS AT ALL PIPES & CONDUITS, SEE TYPICAL DETAIL.
2. G.C. TO CONFIRM ALL LOCATIONS AND INVERTS OF PIPES WITH MECHANICAL & ELECTRICAL CONTRACTORS.
3. THE FOUNDATION DRAWINGS SHOW ONLY GENERAL LOCATIONS AND MAY NOT INCLUDE ALL PENETRATIONS. G.C. TO SEE MECHANICAL DRAWINGS FOR FULL EXTENT OF PIPE PENETRATIONS.




NOTE:
GENERAL CONTRACTOR TO LAYOUT DIMENSIONS OF COLUMN CENTERLINES AT THE BEGINNING OF THE PROJECT AND IS TO NOTIFY THE ARCHITECT AND STEEL CONTRACTOR OF ANY DEVIATIONS FROM THE CONTRACT DRAWINGS. SEE S-1 FOR FOOTING AND PIER SCHEDULES.

NOTE:
ELECTRICAL CONTRACTOR TO PROVIDE GROUNDING ELECTRODE SYSTEM AS REQUIRED BY NEC SECTION 250-52.8. COORDINATE LOCATION WITH GENERAL CONTRACTOR.

CISTERN CAP PLAN
1/4" = 1'-0"

**DESIGN DEVELOPMENT
NOT FOR CONSTRUCTION**

JOHN N. HARRISON U.S.V.I. P.E. #0-19474-1B DATE

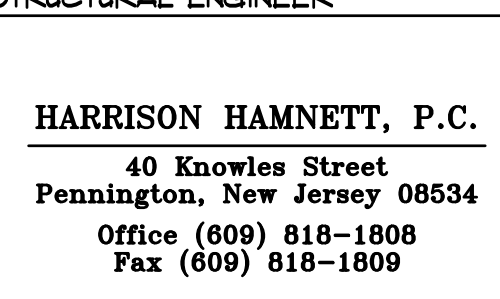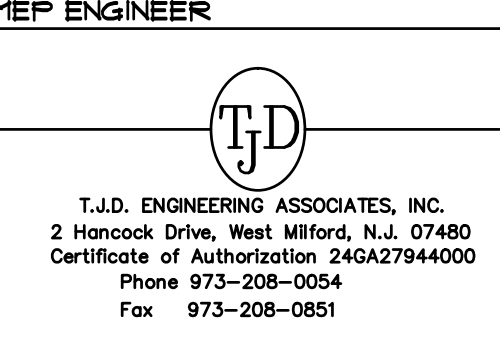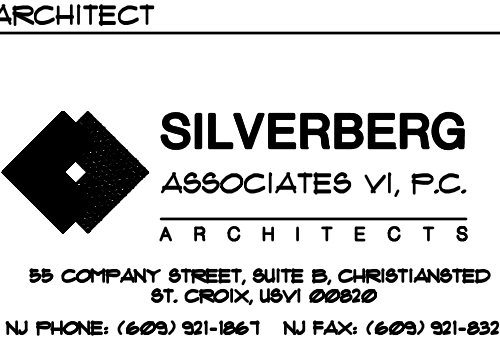

PROFESSIONAL SEAL:

THIS DRAWING SHALL NOT BE USED FOR CONSTRUCTION UNLESS A PROFESSIONAL'S SEAL AND SIGNATURE ARE ON THE DRAWING

PROJECT TITLE / DESCRIPTION:
TROPICAL SHIPPING
NEW OFFICES

FACILITY LOCATION:
TROPICAL SHIPPING LLC.
(LEASED PLOT)

PLOT NO. 8
EAST HOPE (H.O.V.I.C. LANDS)
QUEEN'S QUARTER, ST. CROIX USVI

DATE: 5-28-24		
NO.	REVISION:	DATE:


PROJECT NUMBER:
22254

DRAWING TITLE:
FOUNDATION &
CIST. CAP PLAN

SHEET NUMBER:
S-101

SHEET **OF**

Drawing name: C:\Users\Natalia\AppData\Local\Temp\AcPublish_22972\Tropical Shipping.dwg
Date: May 23, 2024 5:22pm

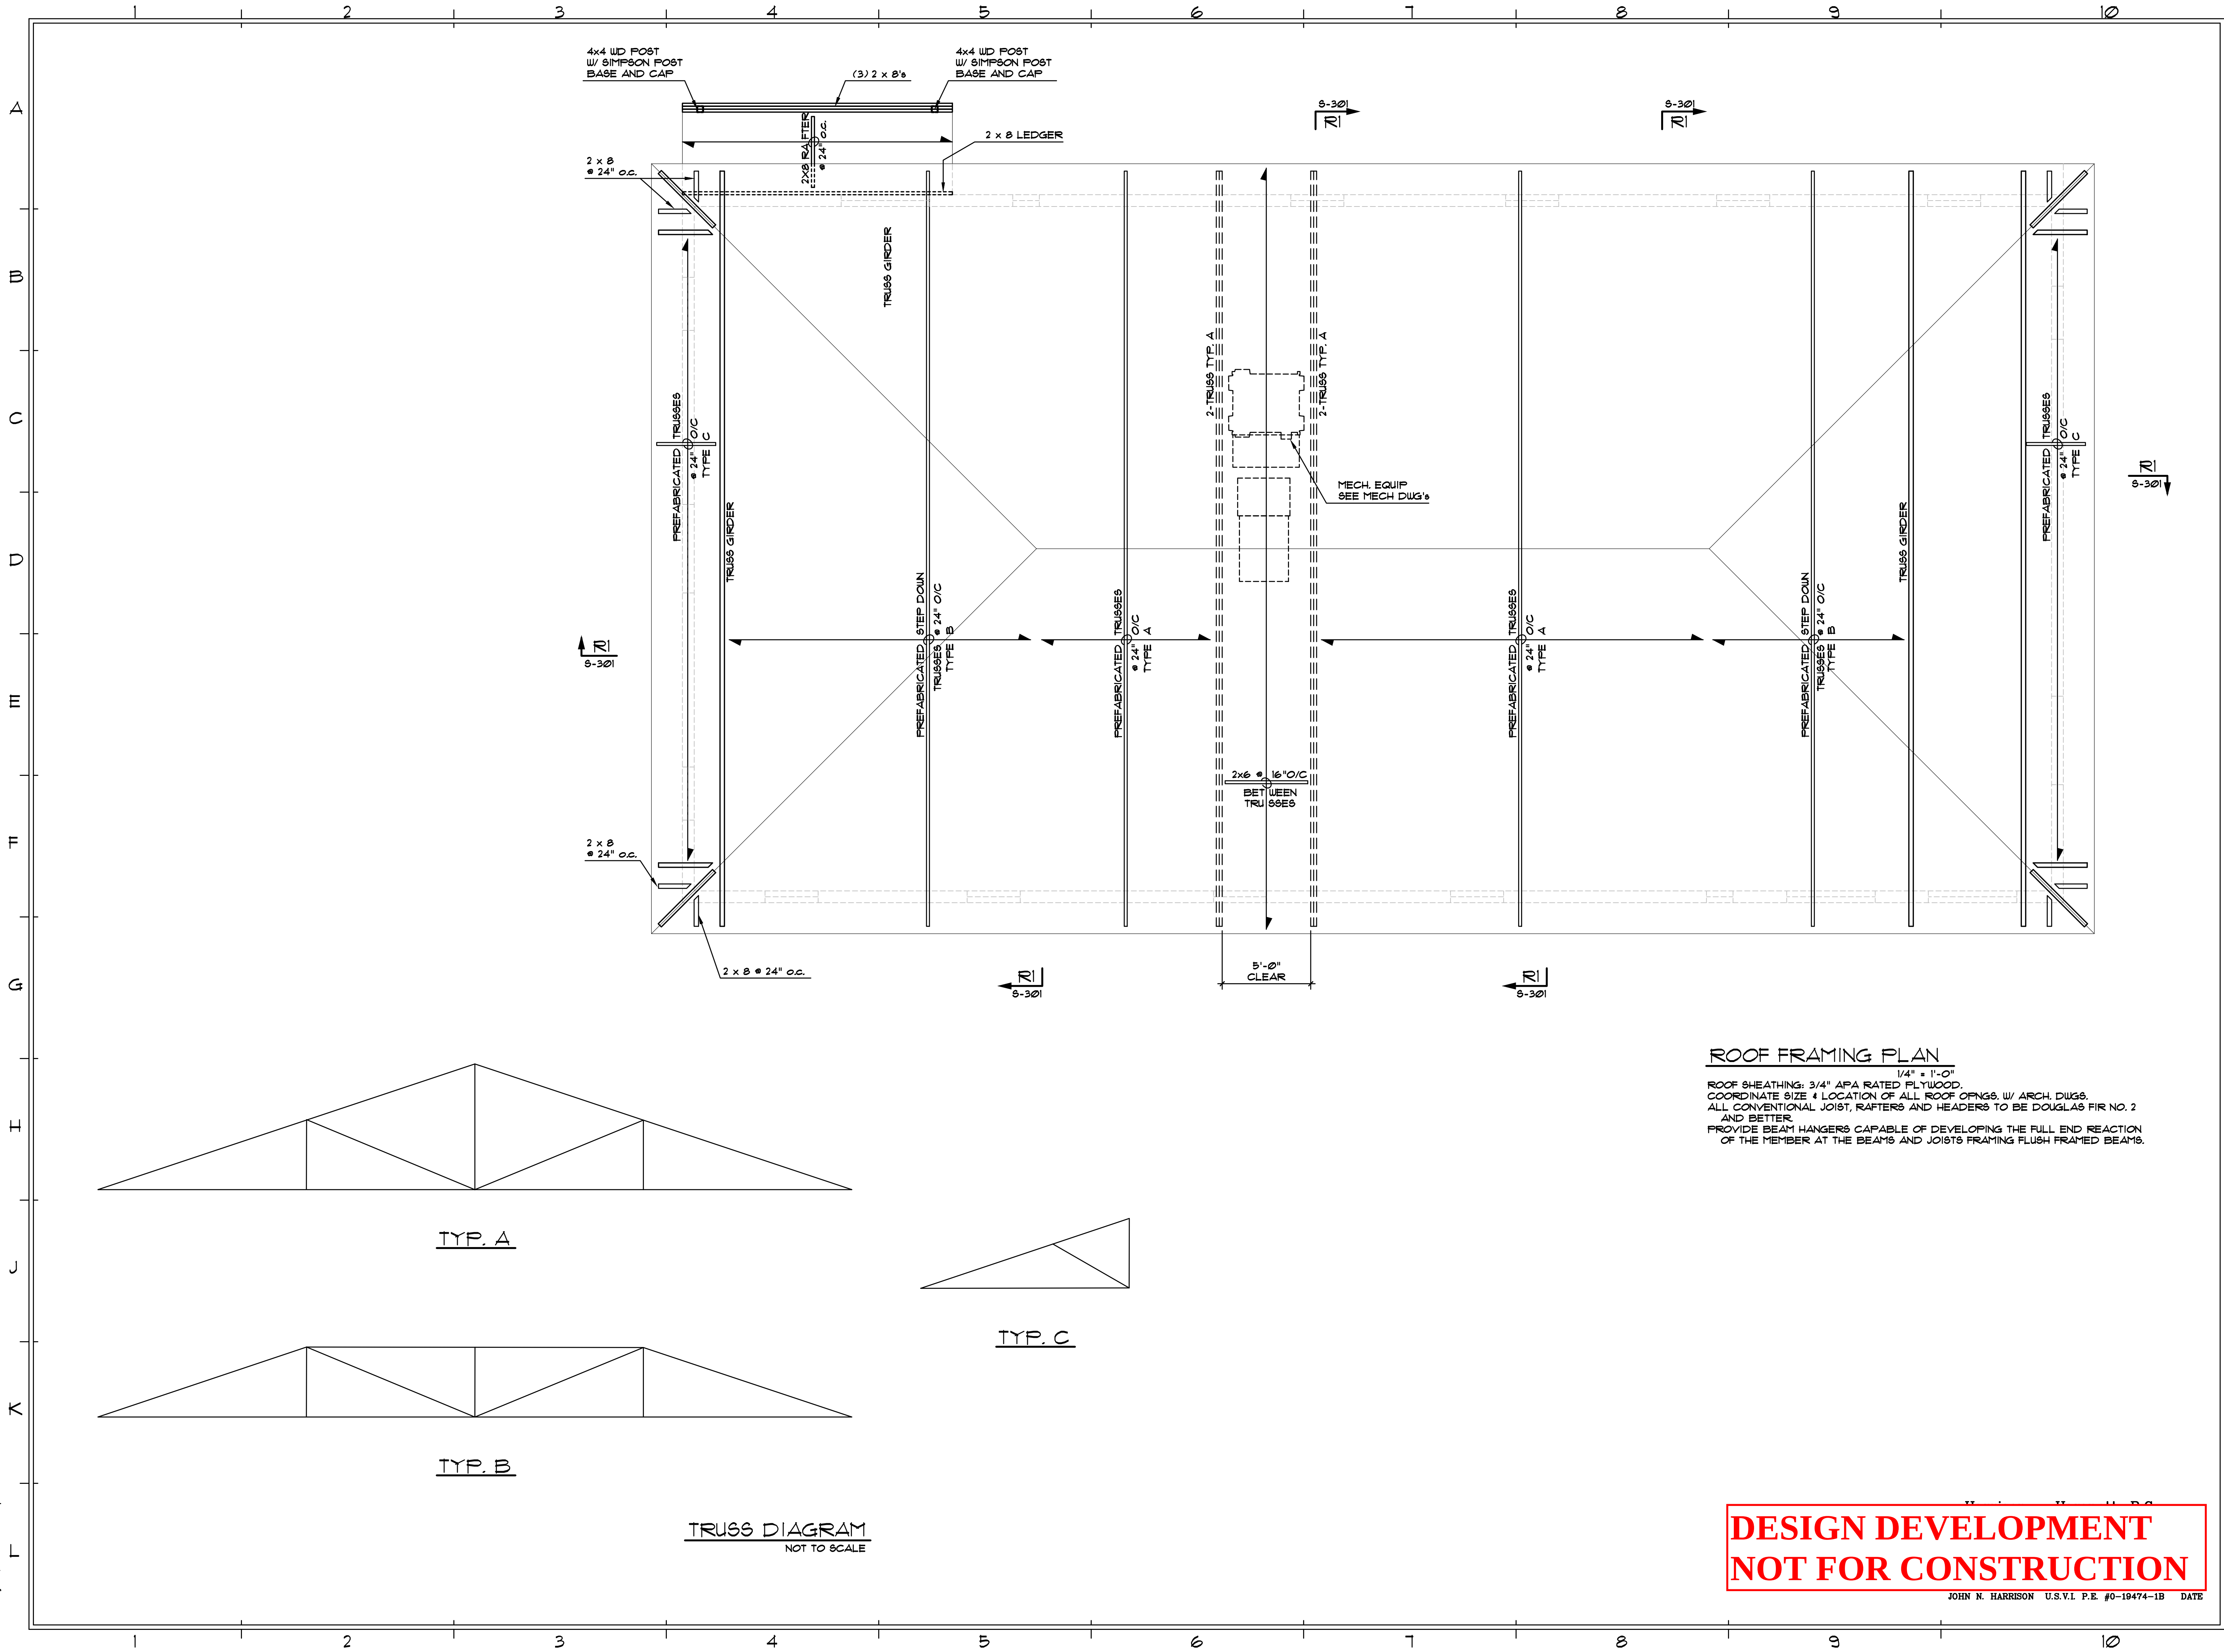

ROOF FRAMING PLAN

1/4" = 1'-0"
ROOF SHEATHING: 3/4" APA RATED PLYWOOD.
COORDINATE SIZE & LOCATION OF ALL ROOF OPNGS. W/ ARCH. DUGS.
ALL CONVENTIONAL JOIST, RAFTERS AND HEADERS TO BE DOUGLAS FIR NO. 2
AND BETTER.
PROVIDE BEAM HANGERS CAPABLE OF DEVELOPING THE FULL END REACTION
OF THE MEMBER AT THE BEAMS AND JOISTS FRAMING FLUSH FRAMED BEAMS.

**DESIGN DEVELOPMENT
NOT FOR CONSTRUCTION**


JOHN N. HARRISON U.S.V.I. P.E. #0-19474-1B DATE




ARCHITECT



MEP ENGINEER

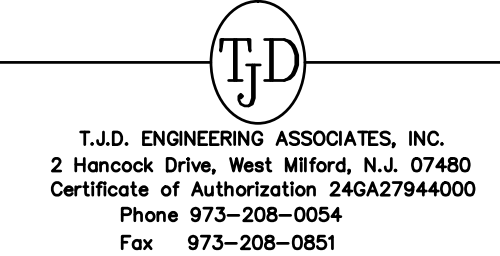

STRUCTURAL ENGINEER

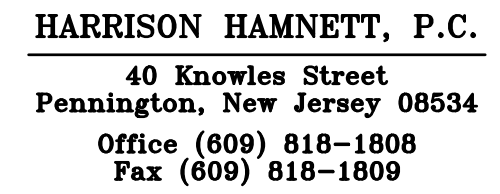

OWNER



PROFESSIONAL SEAL:

THIS DRAWING SHALL NOT BE USED FOR
CONSTRUCTION UNLESS A PROFESSIONAL'S
SEAL AND SIGNATURE ARE ON THE DRAWING

PROJECT TITLE / DESCRIPTION:
**TROPICAL SHIPPING
NEW OFFICES**

FACILITY LOCATION:
TROPICAL SHIPPING L.L.C.
(LEASED PLOT)

PLOT NO. 8
EAST HOPE (H.O.V.I.C. LANDS)
QUEEN'S QUARTER, ST. CROIX USVI

DATE:
5-28-24

NO.	REVISION:	DATE:

PROJECT NUMBER:
22254


DRAWING TITLE:
**ROOF FRAMING
PLAN**

SHEET NUMBER:

S-201

SHEET OF

Drawing name: C:\Users\Natalia\AppData\Local\Temp\AcPublish_22972\Tropical Shipping.dwg
Date: May 23, 2024 5:22pm

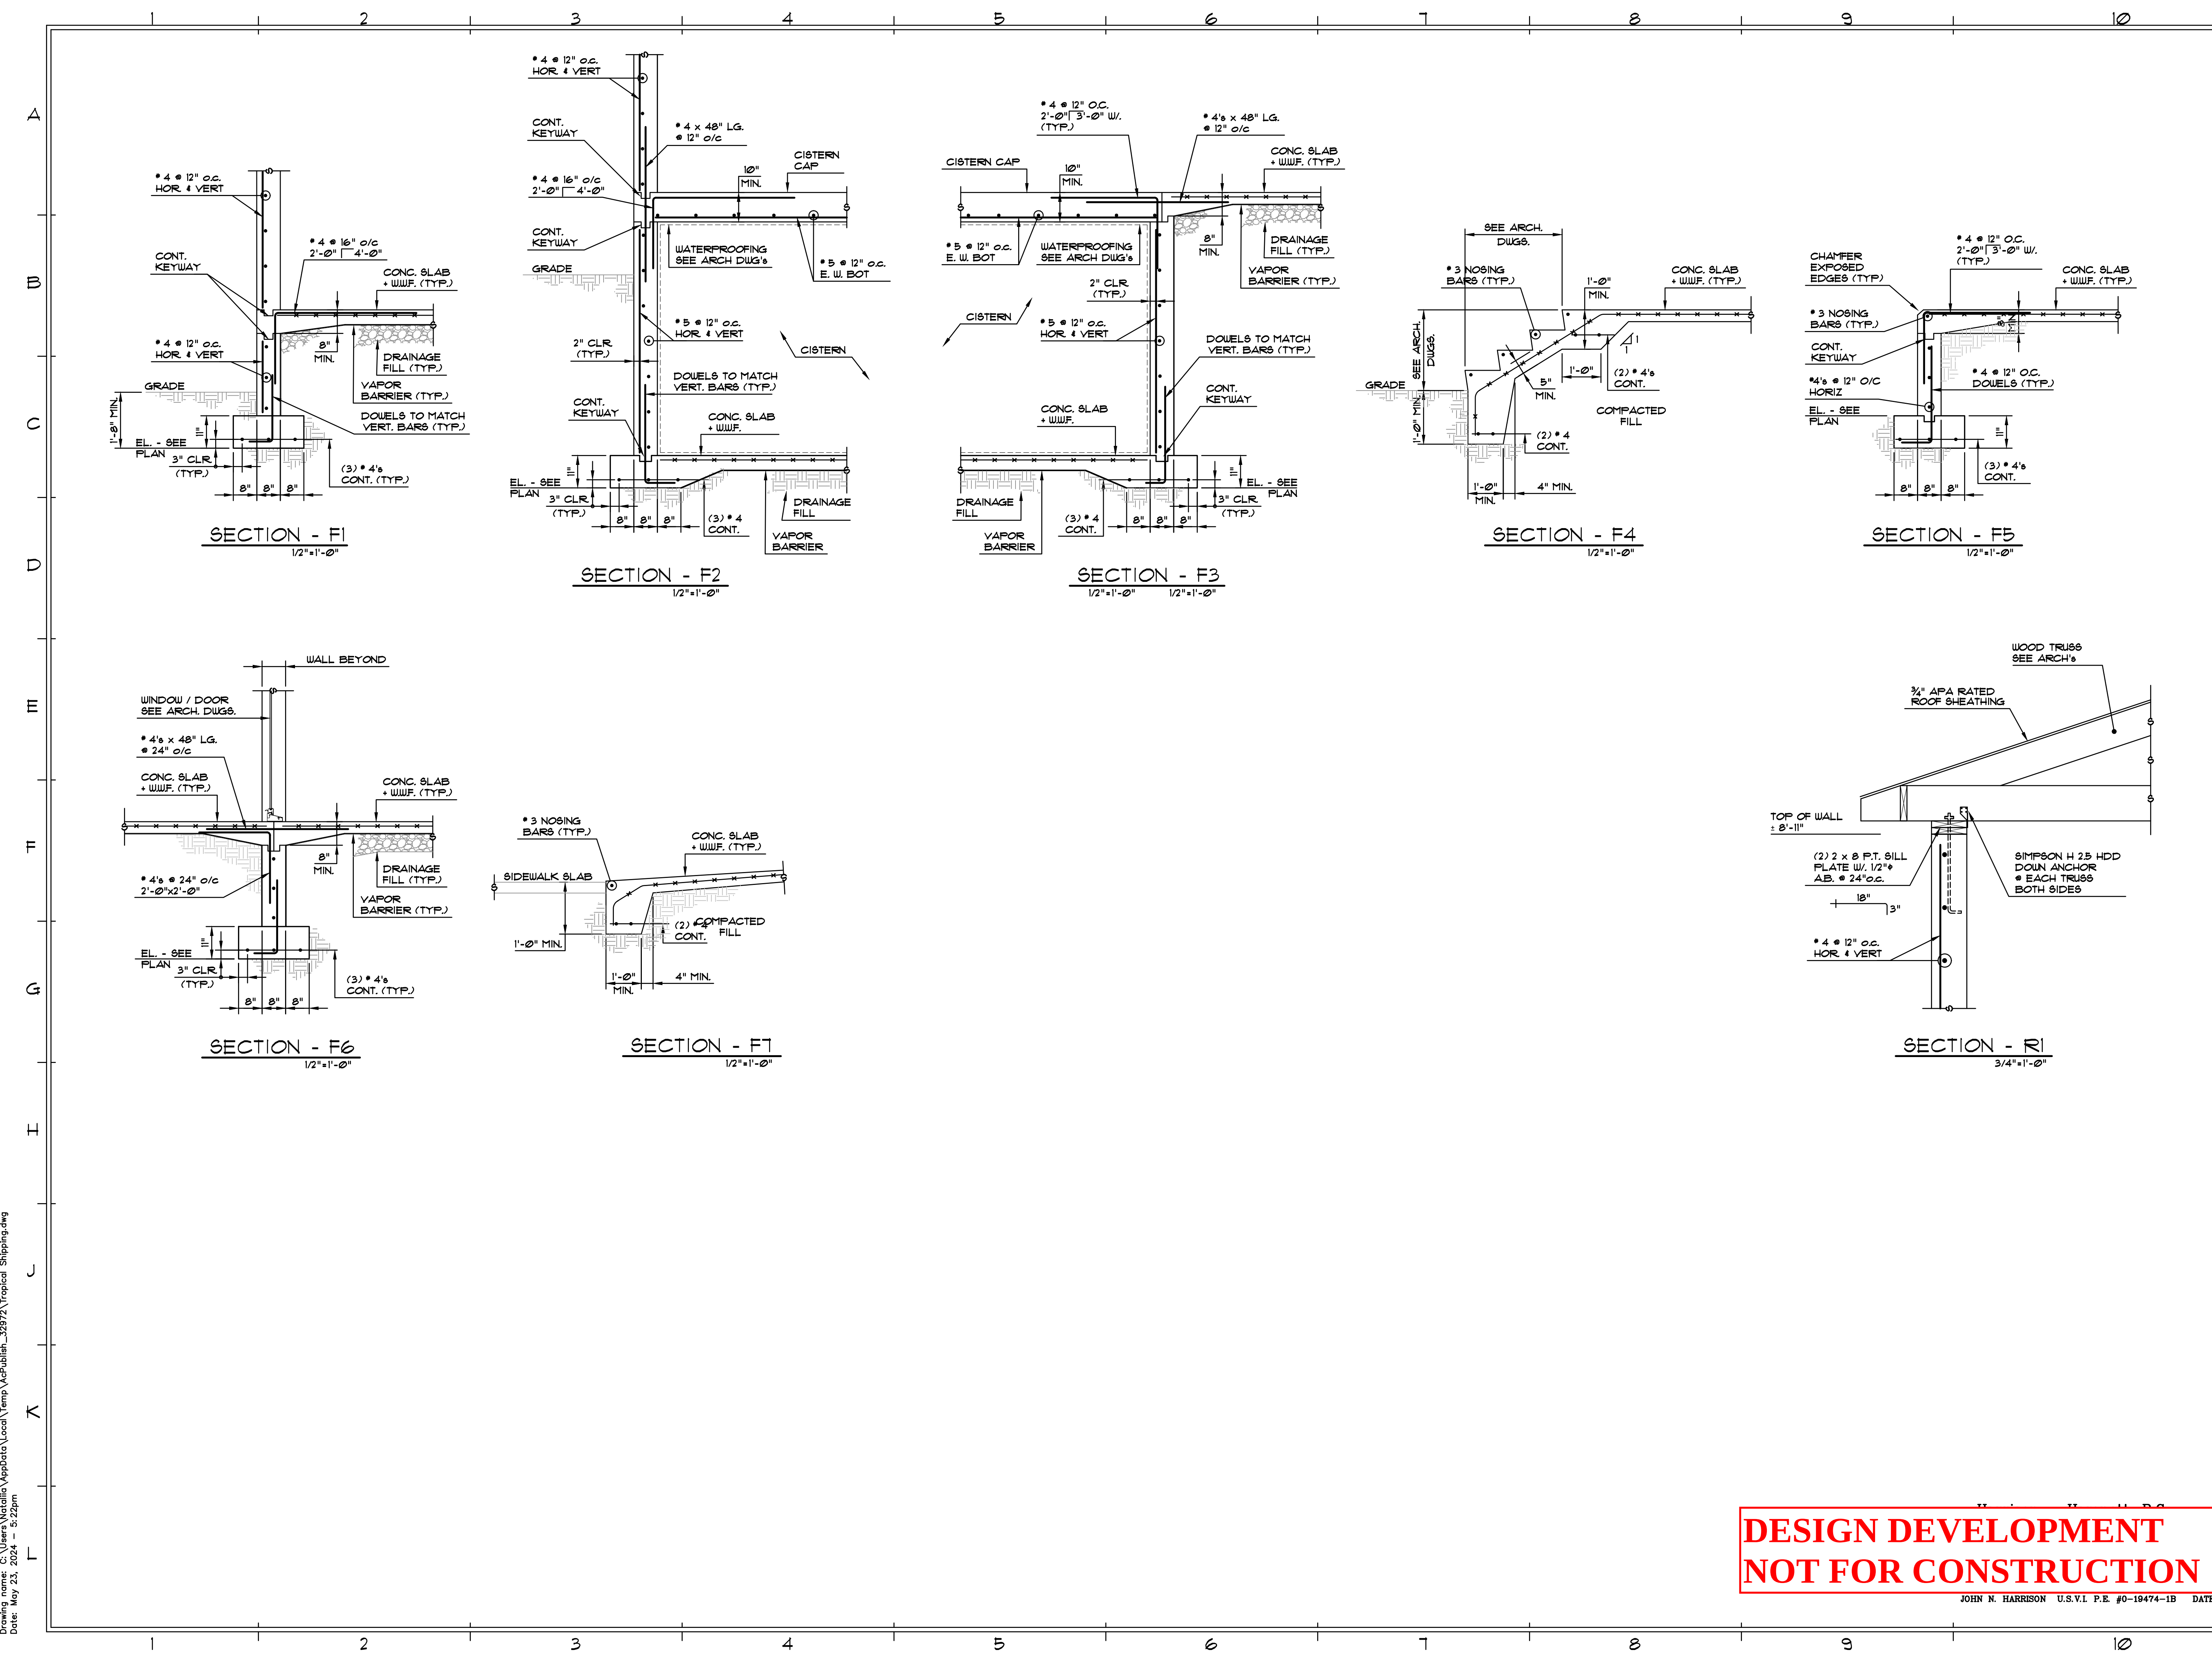

**DESIGN DEVELOPMENT
NOT FOR CONSTRUCTION**


JOHN N. HARRISON U.S.V.I. P.E. #0-19474-1B DATE




ARCHITECT



MEP ENGINEER

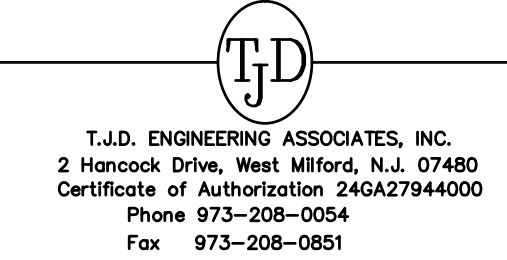

STRUCTURAL ENGINEER

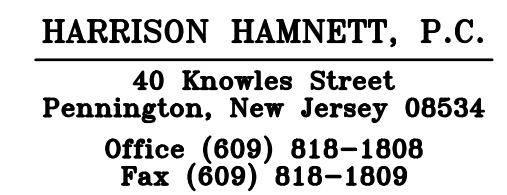

OWNER



PROFESSIONAL SEAL:

THIS DRAWING SHALL NOT BE USED FOR CONSTRUCTION UNLESS A PROFESSIONAL'S SEAL AND SIGNATURE ARE ON THE DRAWING

PROJECT TITLE / DESCRIPTION:
**TROPICAL SHIPPING
NEW OFFICES**

FACILITY LOCATION:
TROPICAL SHIPPING LLC.
(LEASED PLOT)

PLOT NO. 8
EAST HOPE (H.O.V.I.C. LANDS)
QUEEN'S QUARTER, ST. CROIX USVI

DATE:
5-28-24


NO.	REVISION:	DATE:

PROJECT NUMBER:
22254

DRAWING TITLE:
SECTIONS

SHEET NUMBER:
S-301

SHEET OF

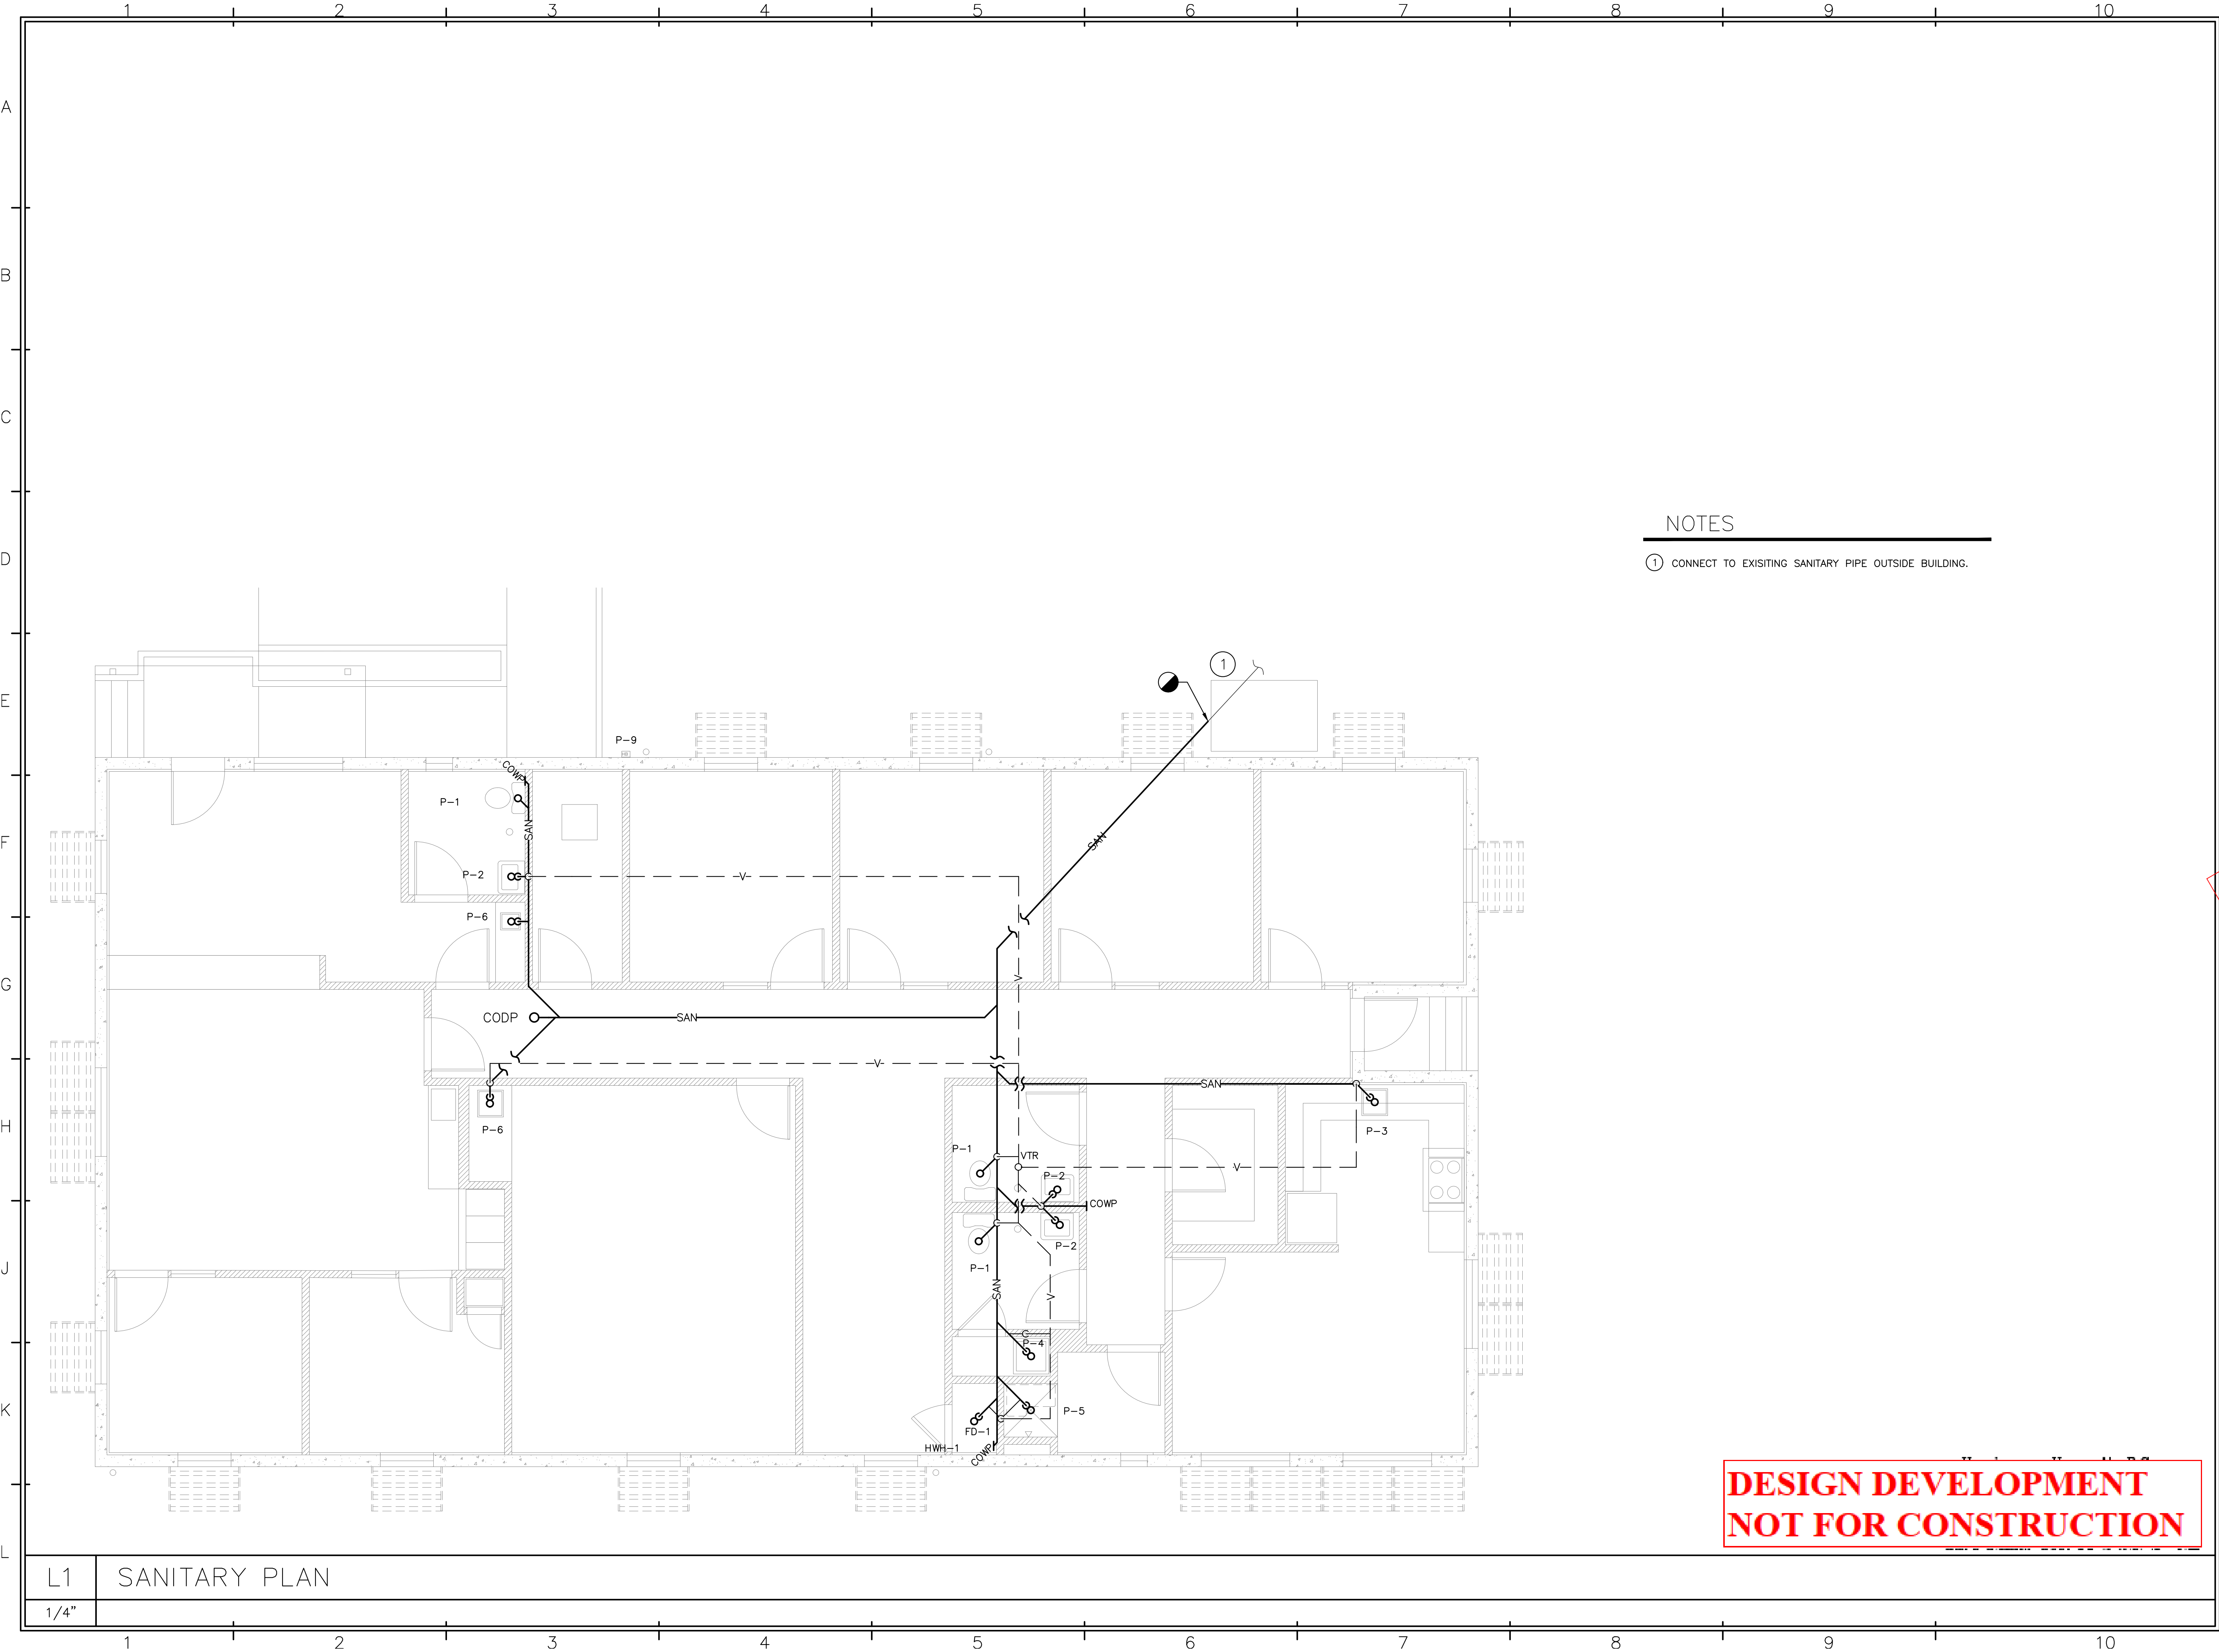

NOTES

- ① CONNECT TO EXISTING SANITARY PIPE OUTSIDE BUILDING.



3000 ORANGE GROVE, CHRISTIANSTED
ST. CROIX, U.S. VIRGIN ISLANDS 00820
PHONE: (340) 718-7222 FAX: (340) 718-4779
WEBSITE: WWW.BCVI.COM

ARCHITECT



55 COMPANY STREET, SUITE B, CHRISTIANSTED
ST. CROIX, USVI 00820
NJ PHONE: (609) 921-1867 NJ FAX: (609) 921-8328

MEP ENGINEER



T.J.D. ENGINEERING ASSOCIATES, INC.
2 Hancock Drive, West Milford, N.J. 07480
Certificate of Authorization 24GA27944000
Phone 973-208-0054
Fax 973-208-0851

OWNER



PROFESSIONAL SEAL:

**DESIGN DEVELOPMENT
NOT FOR CONSTRUCTION**

THIS DRAWING SHALL NOT BE USED FOR
CONSTRUCTION UNLESS A PROFESSIONAL'S
SEAL AND SIGNATURE ARE ON THE DRAWING

PROJECT TITLE / DESCRIPTION:

TROPICAL SHIPPING
NEW OFFICES

FACILITY LOCATION:

TROPICAL SHIPPING L.L.C.
(LEASED PLOT)

PLOT NO. 8
EAST HOPE (H.O.V.I.C. LANDS)
QUEEN'S QUARTER, ST. CROIX USVI

DATE:

MAY 15, 2024

NO:

REVISION:

DATE:

1

REVIEW

5/28/24

PROJECT NUMBER:

2421B

DRAWING TITLE:

SANITARY
PLAN

SHEET NUMBER:


P101

SHEET

1

OF

6

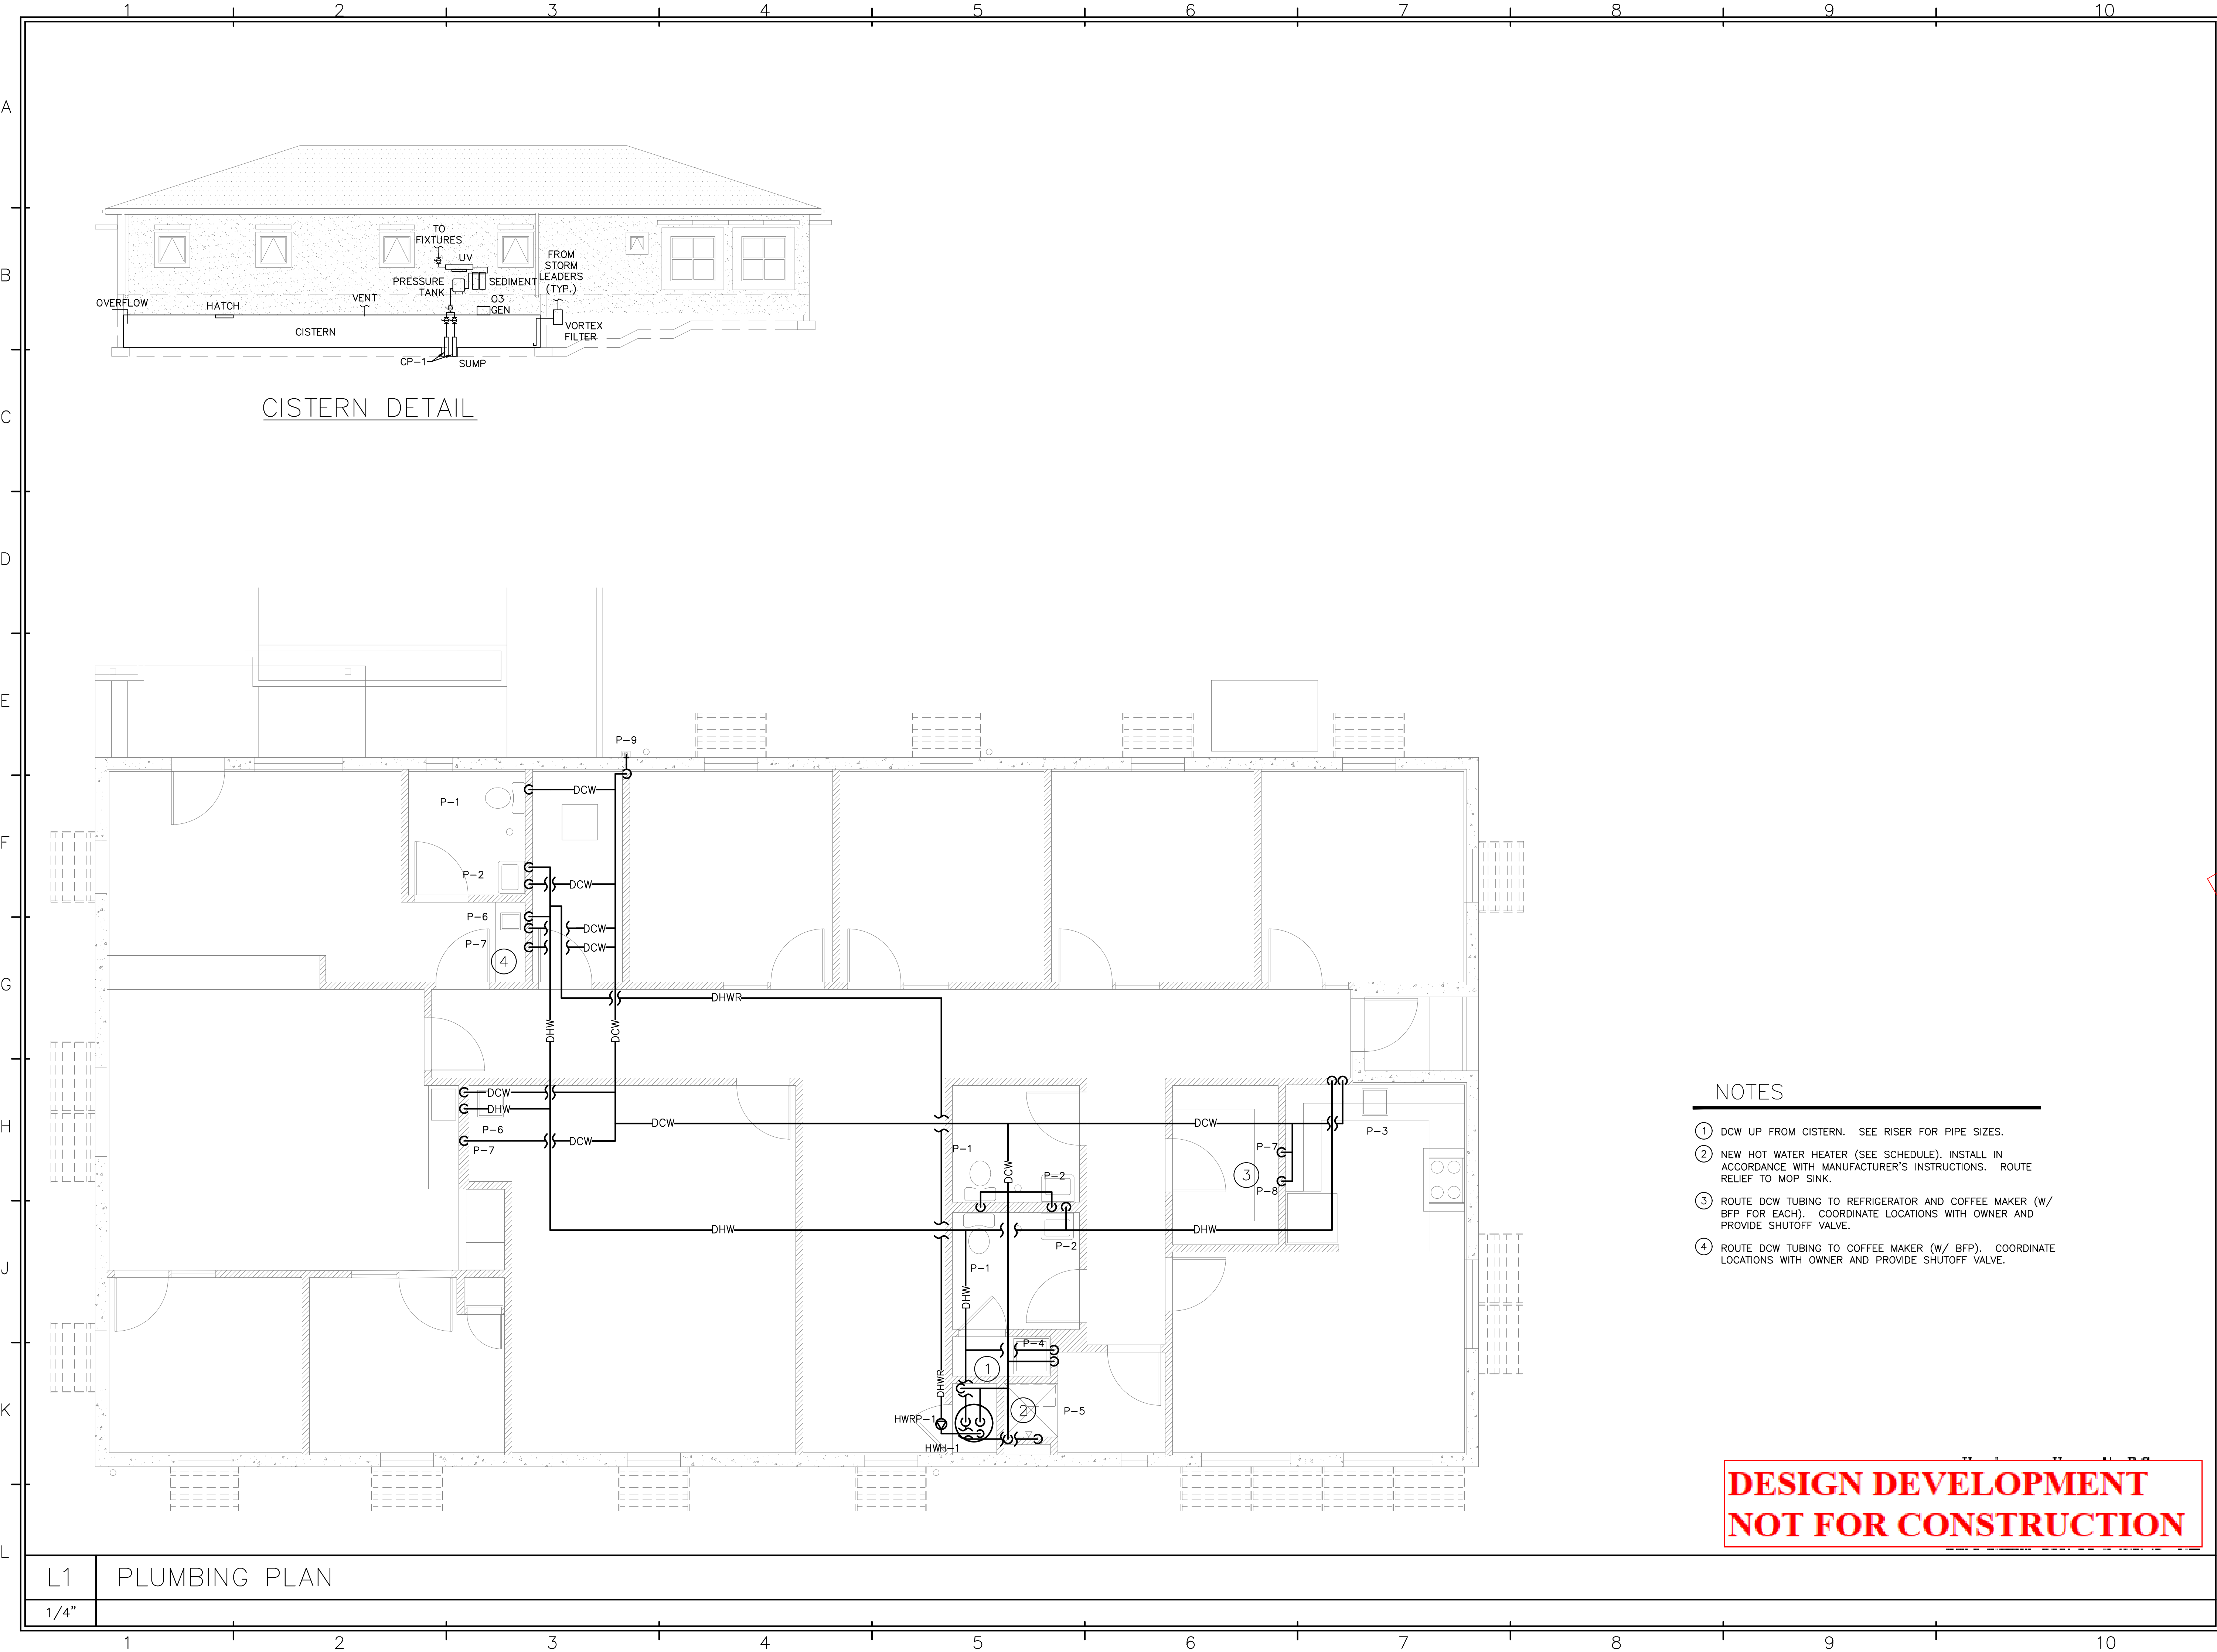

3000 ORANGE GROVE, CHRISTIANSTED
ST. CROIX, U.S. VIRGIN ISLANDS 00820
PHONE: (340) 718-7222 FAX: (340) 718-4779
WEBSITE: WWW.BCVI.COM

ARCHITECT



55 COMPANY STREET, SUITE B, CHRISTIANSTED
ST. CROIX, USVI 00820
NJ PHONE: (609) 921-1867 NJ FAX: (609) 921-8328

MEP ENGINEER



T.J.D. ENGINEERING ASSOCIATES, INC.
2 Hancock Drive, West Milford, N.J. 07480
Certificate of Authorization 24GA27944000
Phone 973-208-0054
Fax 973-208-0851

OWNER



PROFESSIONAL SEAL:

DESIGN DEVELOPMENT
NOT FOR CONSTRUCTION

THIS DRAWING SHALL NOT BE USED FOR
CONSTRUCTION UNLESS A PROFESSIONAL'S
SEAL AND SIGNATURE ARE ON THE DRAWING

PROJECT TITLE / DESCRIPTION:
TROPICAL SHIPPING
NEW OFFICES

FACILITY LOCATION:
TROPICAL SHIPPING L.L.C.
(LEASED PLOT)
PLOT NO. 8
EAST HOPE (H.O.V.I.C. LANDS)
QUEEN'S QUARTER, ST. CROIX USVI

DATE:
MAY 15, 2024


NO:	REVISION:	DATE:
1	REVIEW	5/28/24

PROJECT NUMBER:
2421B

DRAWING TITLE:
PLUMBING
PLAN

SHEET NUMBER:
P102

SHEET 2 OF 6

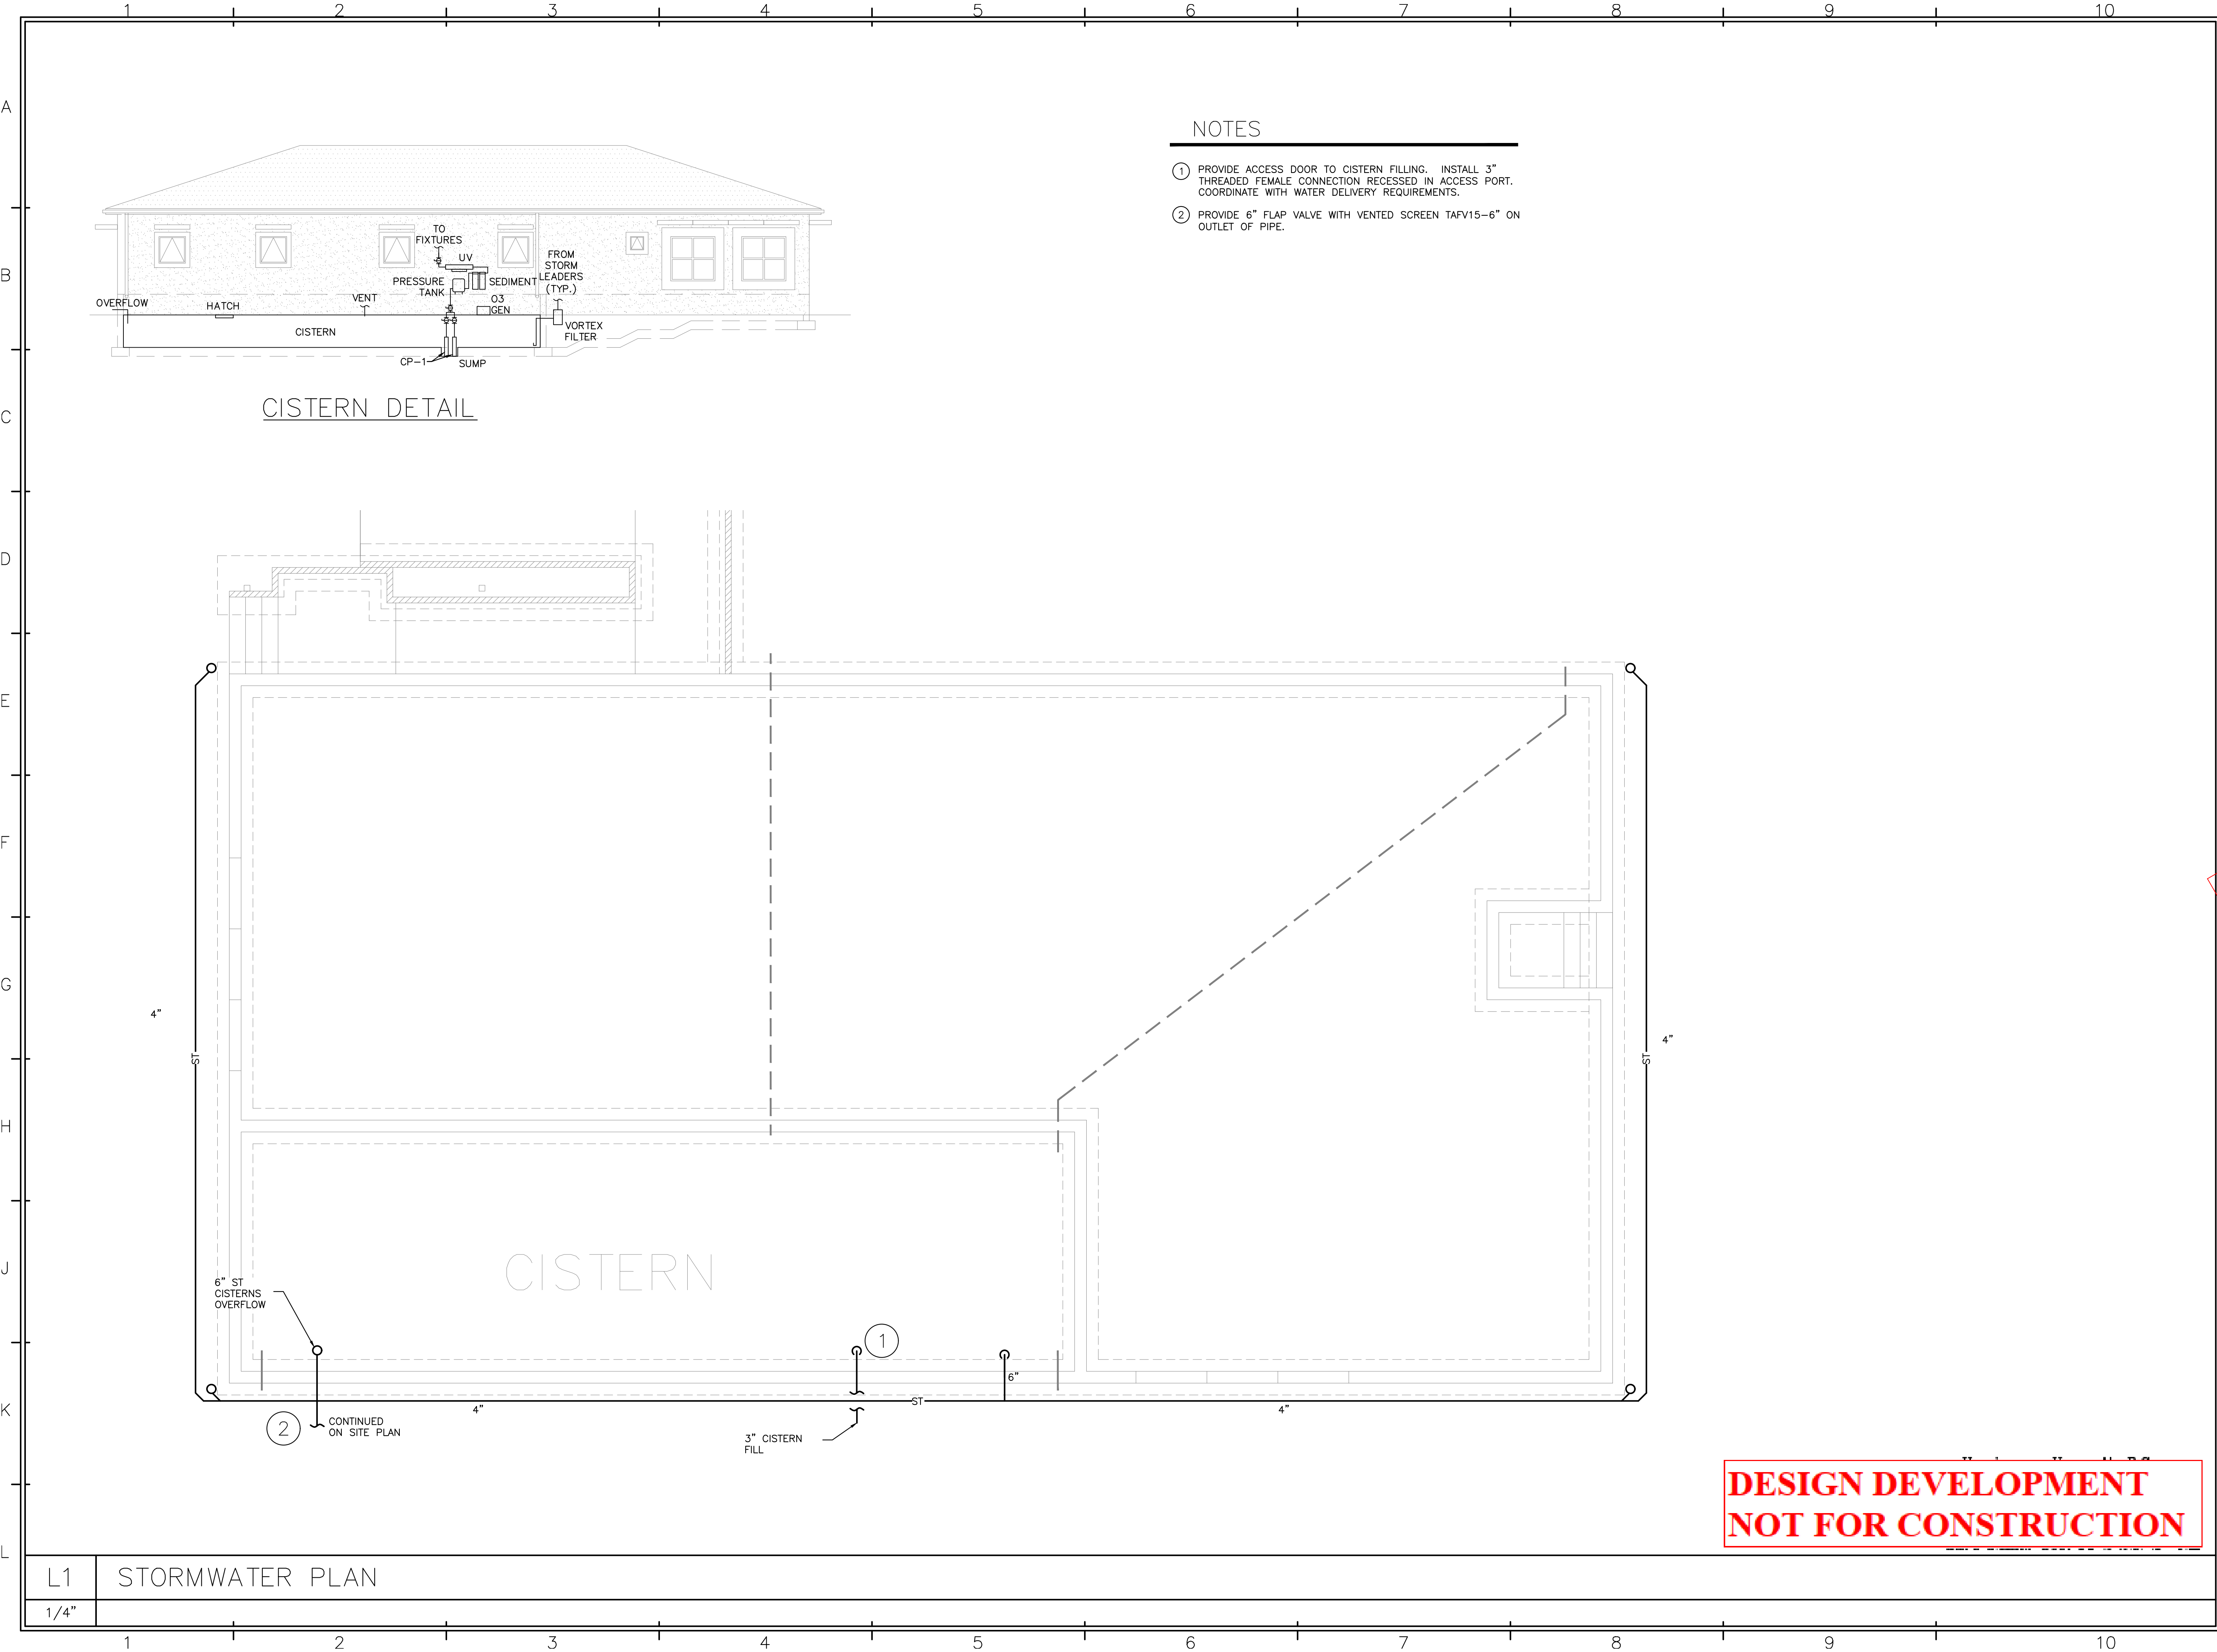

3000 ORANGE GROVE, CHRISTIANSTED
ST. CROIX, U.S. VIRGIN ISLANDS 00820
PHONE: (340) 718-7222 FAX: (340) 718-4779
WEBSITE: WWW.JBCV.COM

ARCHITECT

55 COMPANY STREET, SUITE B, CHRISTIANSTED
ST. CROIX, USVI 00820
NU PHONE: (609) 921-1867 NU FAX: (609) 921-8328

MEP ENGINEER

T.J.D. ENGINEERING ASSOCIATES, INC.
2 Hancock Drive, West Milford, N.J. 07480
Certificate of Authorization 24GA27944000
Phone 973-208-0054
Fax 973-208-0851

OWNER

PROFESSIONAL SEAL:

THIS DRAWING SHALL NOT BE USED FOR
CONSTRUCTION UNLESS A PROFESSIONAL'S
SEAL AND SIGNATURE ARE ON THE DRAWING

PROJECT TITLE / DESCRIPTION:
TROPICAL SHIPPING
NEW OFFICES

FACILITY LOCATION:
TROPICAL SHIPPING L.L.C.
(LEASED PLOT)
PLOT NO. 8
EAST HOPE (H.O.V.I.C. LANDS)
QUEEN'S QUARTER, ST. CROIX USVI

DATE:
MAY 15, 2024



NO:	REVISION:	DATE:
1	REVIEW	5/28/24

PROJECT NUMBER:
2421B

DRAWING TITLE:
STORM WATER
PLAN

SHEET NUMBER:
P103

SHEET	3	OF	6
-------	---	----	---

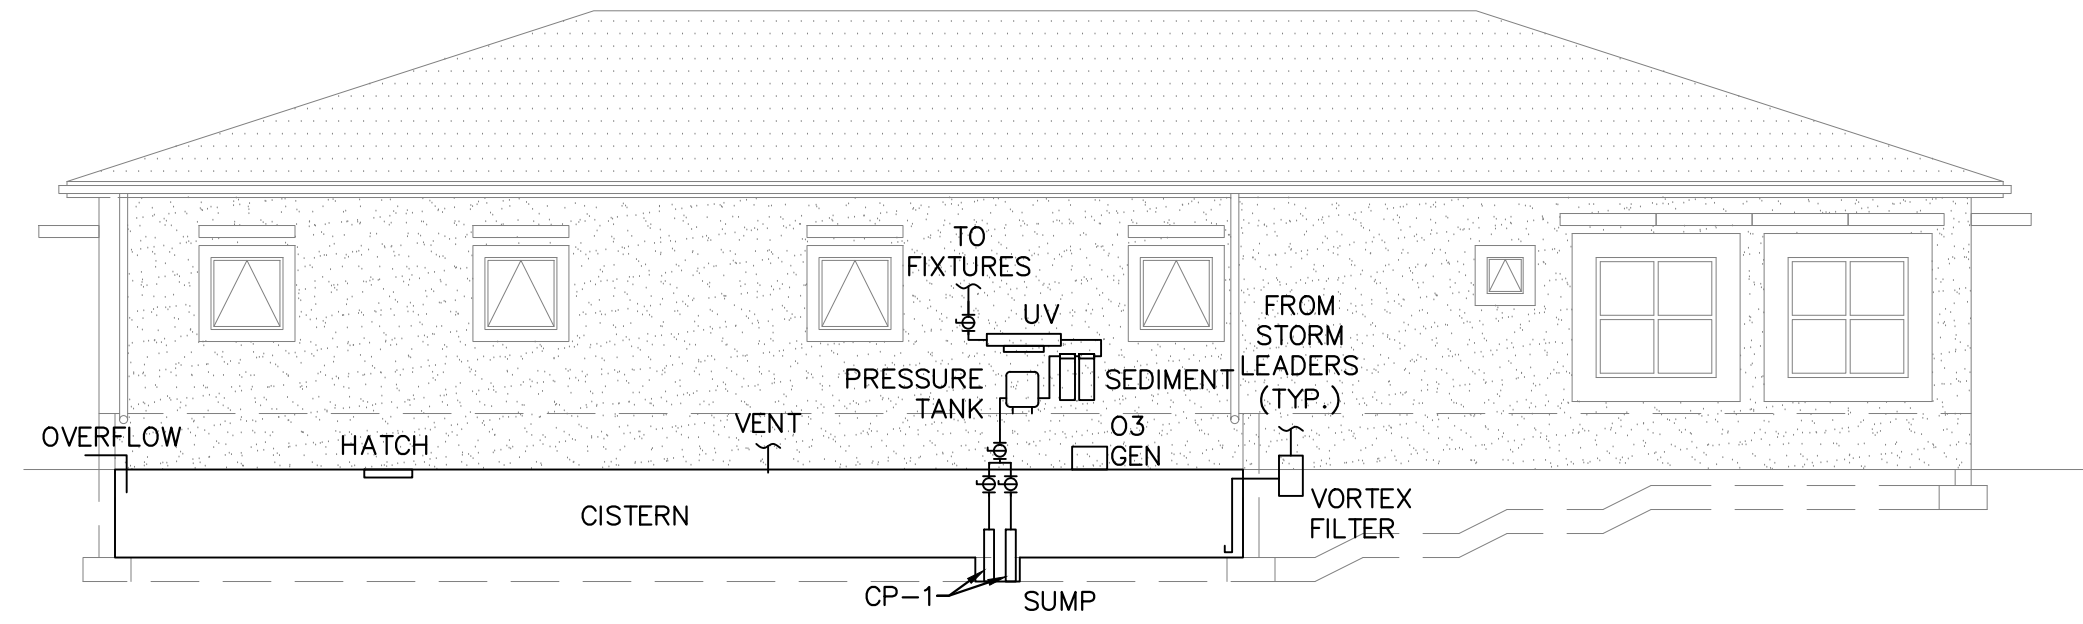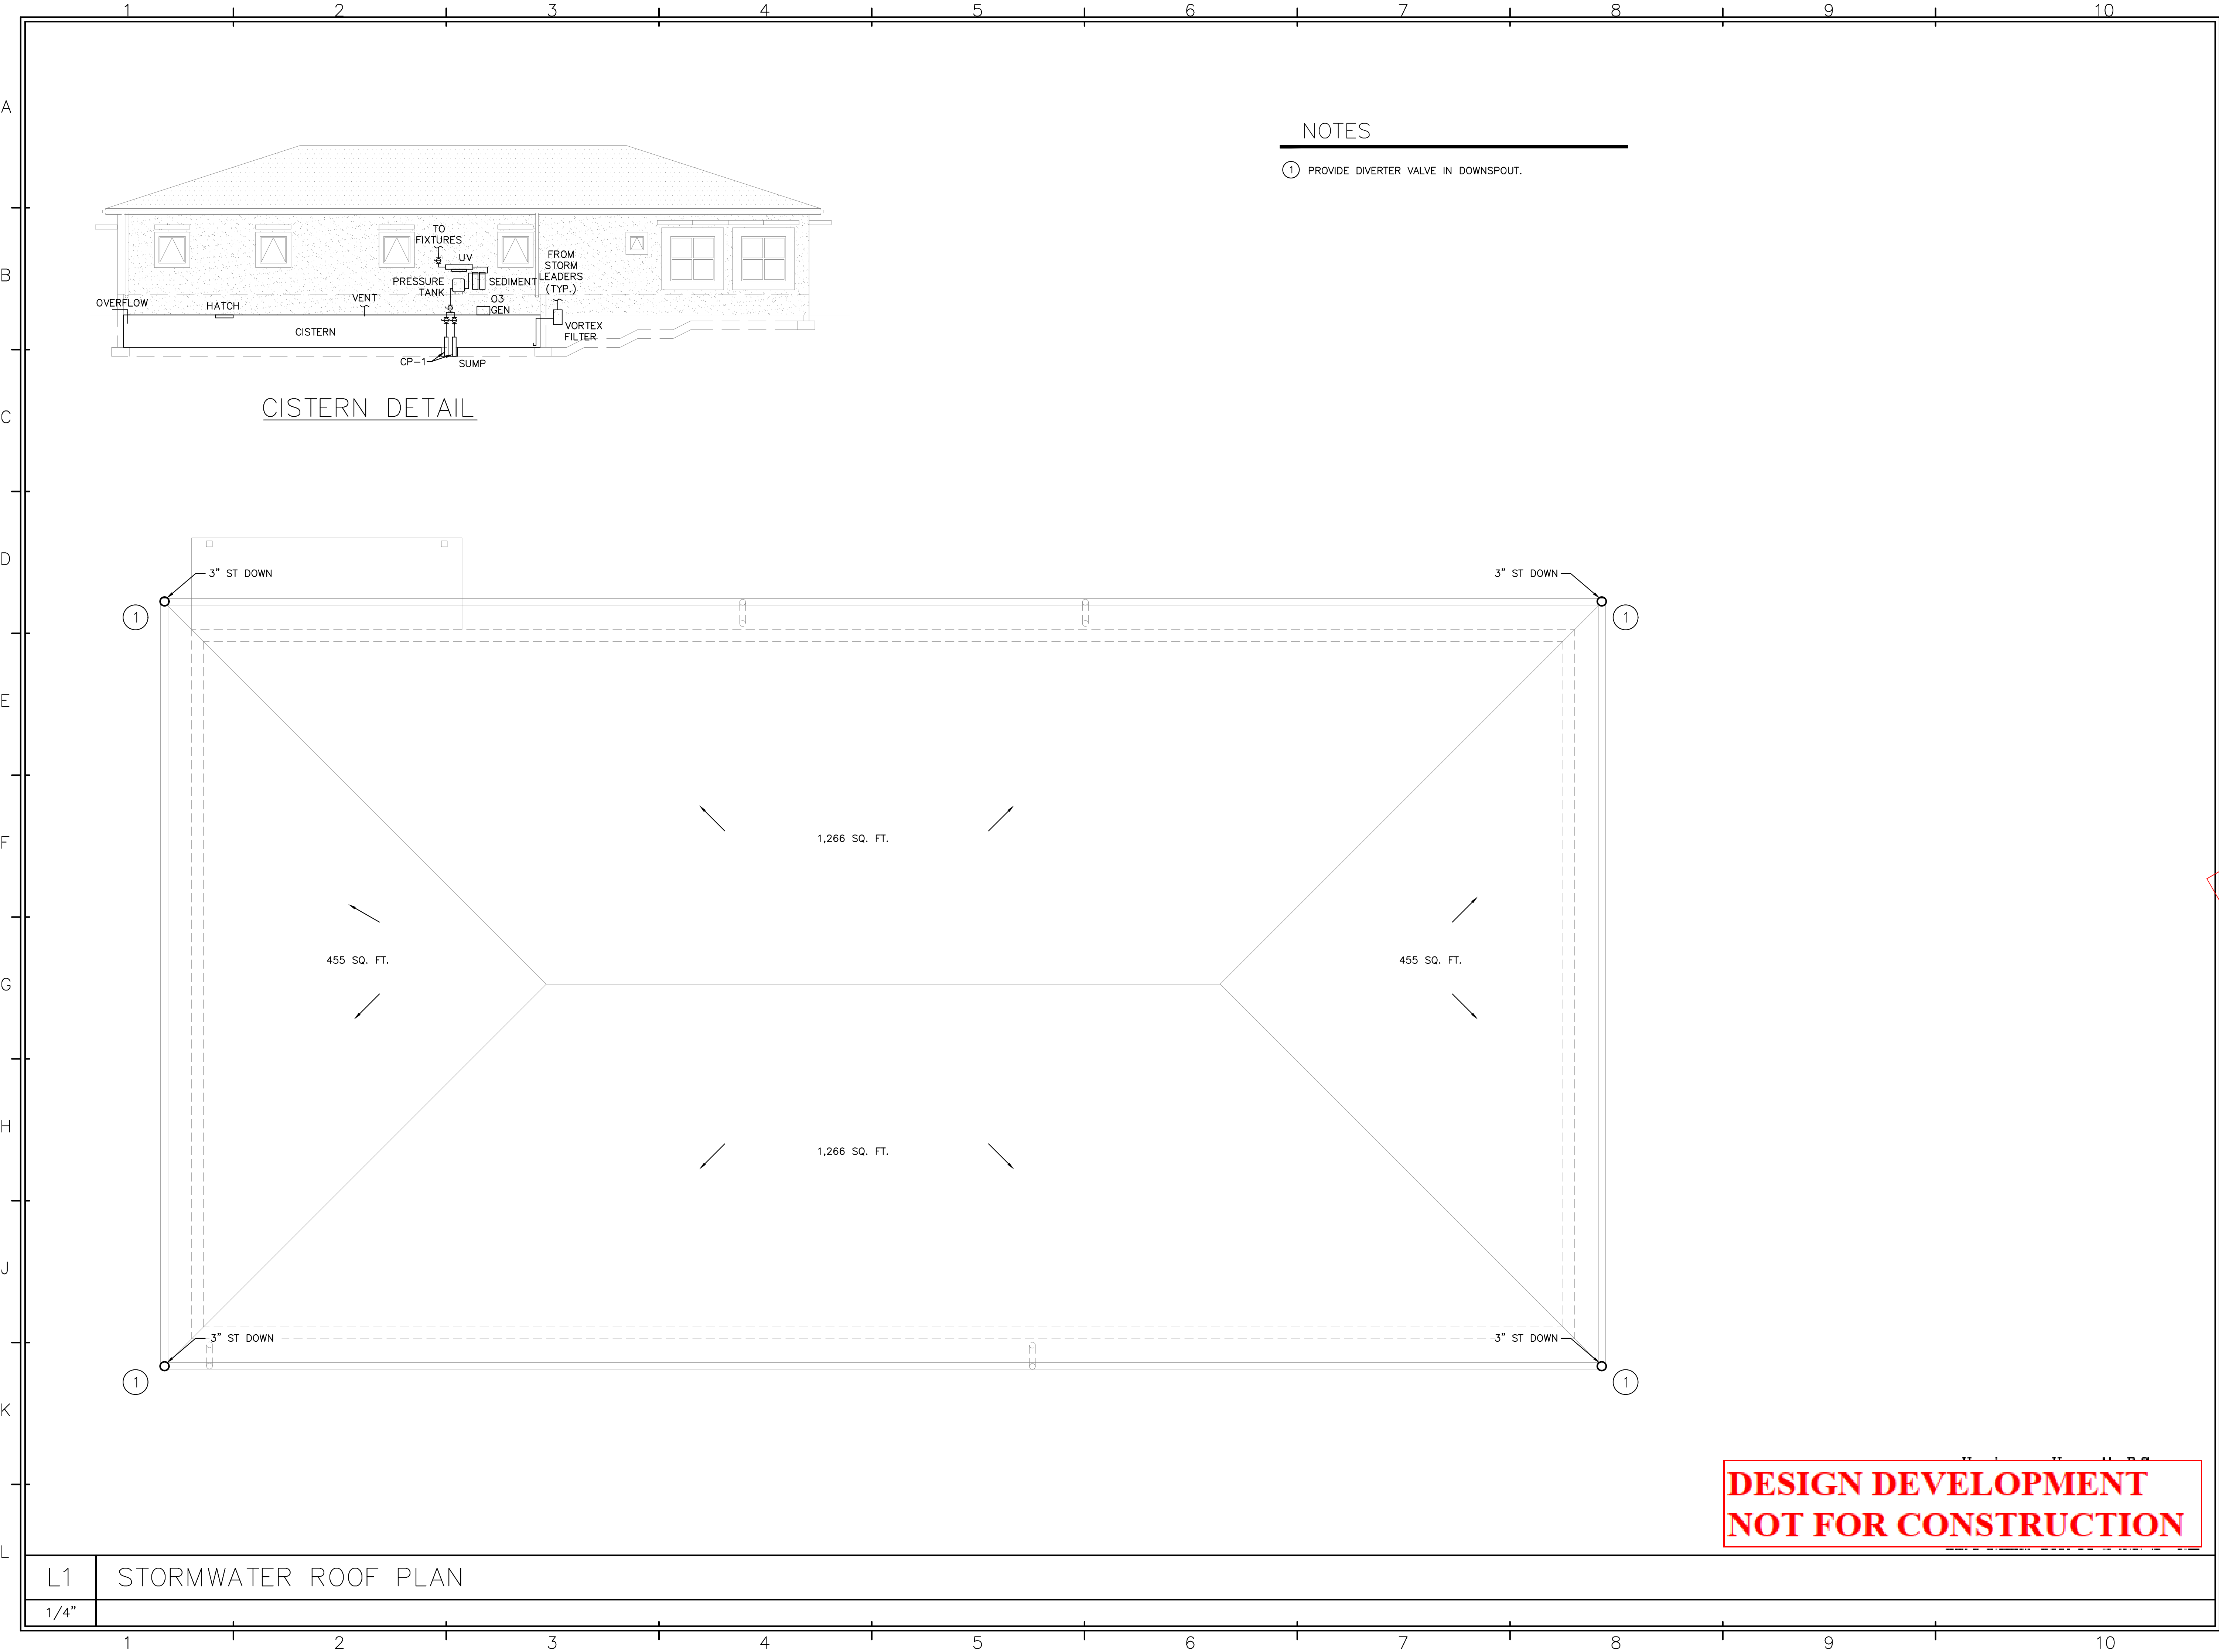

CISTERN DETAIL

NOTES

- ① PROVIDE DIVERTER VALVE IN DOWNSPOUT.



3000 ORANGE GROVE, CHRISTIANSTED
ST. CROIX, U.S. VIRGIN ISLANDS 00820
PHONE: (340) 718-7222 FAX: (340) 718-4779
WEBSITE: WWW.BCVI.COM

ARCHITECT



55 COMPANY STREET, SUITE B, CHRISTIANSTED
ST. CROIX, USVI 00820
NJ PHONE: (609) 921-1867 NJ FAX: (609) 921-8328

MEP ENGINEER



T.J.D. ENGINEERING ASSOCIATES, INC.
2 Hancock Drive, West Milford, N.J. 07480
Certificate of Authorization 24GA27944000
Phone 973-208-0054
Fax 973-208-0851

OWNER



PROFESSIONAL SEAL:

DESIGN DEVELOPMENT
NOT FOR CONSTRUCTION

THIS DRAWING SHALL NOT BE USED FOR
CONSTRUCTION UNLESS A PROFESSIONAL'S
SEAL AND SIGNATURE ARE ON THE DRAWING

PROJECT TITLE / DESCRIPTION:
TROPICAL SHIPPING
NEW OFFICES

FACILITY LOCATION:
TROPICAL SHIPPING L.L.C.
(LEASED PLOT)
PLOT NO. 8
EAST HOPE (H.O.V.I.C. LANDS)
QUEEN'S QUARTER, ST. CROIX USVI

DATE:
MAY 15, 2024

NO:	REVISION:	DATE:
1	REVIEW	5/28/24

PROJECT NUMBER:
2421B

DRAWING TITLE:
STORM WATER
ROOF PLAN

SHEET NUMBER:
P104

SHEET 4 OF 6

WATER HEATER SCHEDULE								
SYMBOL	MANUFACTURER	MODEL	TANK CAPACITY (GAL)	ELECTRIC INPUT (KW)	VOLTS	AMPS	PHASE	REMARKS
HWH-1	AO SMITH	DEL-30S-4	20	4.5/4.5	208			

PLUMBING FIXTURE SCHEDULE										
SYMBOL	FIXTURE TYPE	MANUFACTURER	MODEL	FLOW	PIPE SIZES					REMARKS
					TRAP	DRAIN	VENT	DCW	DHW	
P-1	WATER CLOSET	KOHLER	K-25077-SSTR	1.28 GPF	-	3"	1.5"	1/2"	-	K-20110 SEAT
P-2	LAVATORY	KOHLER	K-2006	1 GPM	1.5"	1.5"	1.5"	1/2"	1/2"	K-800T20-4AKL FAUCET, K-7114-A-CP DRAIN,
P-3	KITCHEN SINK	ELKAY	ECTRU17179TC	1.8	1.5"	1.5"	1.5"	1/2"	1/2"	LKAV3032CR FAUCET
P-4	MOP SINK	MUSTEE	63M	6 GPM	3"	3"	1.5"	1/2"	1/2"	63.600A FAUCET, 67.2424 & 67.24C WALLS
P-5	SHOWER	MUSTEE	140	1.75 GPM	2"	2"	1.5"	1/2"	1/2"	48.700 DOOR, KOHLER K-630T40-4AG FAUCET
P-6	PANTRY SINK	ELKAY	ECTRU12179TC	1.8 GPM	1.5"	1.5"	1.5"	1/2"	1/2"	LKAV3032 FAUCET
P-7	COFFEE OUTLET BOX	OATEY	MODA	-	-	-	1/2"	-	-	WATTS 3/8" SD-3 BFP
P-8	WATER OUTLET BOX	OATEY	MODA	-	-	-	1/2"	-	-	WATTS 3/8" 9BD BFP
P-9	HOSE BIBB	WATTS	HY-330	8 GPM	-	-	-	3/4"	-	-
FD-1	FLOOR DRAIN	WATTS	FD-100-A	-	-	2"	-	-	-	SIDE OUTLET WITH TRAP PRIMER TAPPING

PUMP SCHEDULE										
SYMBOL	MANUFACTURER	MODEL	GPM	HEAD (FT H2O)	SUCT./DISCH.	ELECTRICAL				REMARKS
						HP	VOLTS	AMPS	PHASE	
HWRP-1	TACO	008-IQSF6-IFC	0-13	0-14.5	0.75"/0.75"	1/25	115	0.84	1	PLUG IN

D1

NS

PLUMBING SCHEDULES

L6

NS

PLUMBING DETAILS

3000 ORANGE GROVE, CHRISTIANSTED
ST. CROIX, U.S. VIRGIN ISLANDS 00820

PHONE: (340) 718-7222 FAX: (340) 718-4779

WEBSITE: WWW.BCVI.COM

ARCHITECT

SILVERBERG
ASSOCIATES VI, P.C.
ARCHITECTS

55 COMPANY STREET, SUITE B, CHRISTIANSTED
ST. CROIX, USVI 00820

NU PHONE: (609) 921-1867 NU FAX: (609) 921-8328

MEP ENGINEER

T.J.D. ENGINEERING ASSOCIATES, INC.
2 Hancock Drive, West Milford, N.J. 07480

Certificate of Authorization 240A27944000

Phone 973-208-0054

Fax 973-208-0851

OWNER

TROPICAL SHIPPING

PROFESSIONAL SEAL:

DESIGN DEVELOPMENT
NOT FOR CONSTRUCTION

THIS DRAWING SHALL NOT BE USED FOR
CONSTRUCTION UNLESS A PROFESSIONAL'S
SEAL AND SIGNATURE ARE ON THE DRAWING

PROJECT TITLE / DESCRIPTION:

TROPICAL SHIPPING
NEW OFFICES

FACILITY LOCATION:

TROPICAL SHIPPING L.L.C.
(LEASED PLOT)

PLOT NO. 8
EAST HOPE (H.O.V.I.C. LANDS)
QUEEN'S QUARTER, ST. CROIX USVI

DATE:

MAY 15, 2024

NO:

1

REVISION:

REVIEW

DATE:

5/28/24

PROJECT NUMBER:

2421B

DRAWING TITLE:

PLUMBING SCHED
RISERS & DETAILS

SHEET NUMBER:

P105

SHEET



5

OF

6

**DESIGN DEVELOPMENT
NOT FOR CONSTRUCTION**

 BENTON CONSTRUCTION, LLC		
3000 ORANGE GROVE, CHRISTIANSTED ST. CROIX, U.S. VIRGIN ISLANDS 00820 PHONE: (340) 718-7222 FAX: (340) 718-4779 WEBSITE: WWW.BCN.COM		
ARCHITECT		
 SILVERBERG ASSOCIATES VI, P.C. ARCHITECTS 55 COMPANY STREET, SUITE B, CHRISTIANSTED ST. CROIX, USVI 00820 NJ PHONE: (609) 921-1867 NJ FAX: (609) 921-8326		
MEP ENGINEER		
 T.J.D. ENGINEERING ASSOCIATES, INC. 2 Hancock Drive, West Milford, N.J. 07480 Certificate of Authorization 24CA27944000 Phone 973-208-0054 Fax 973-208-0851		
OWNER		
		
PROFESSIONAL SEAL:		
DESIGN DEVELOPMENT NOT FOR CONSTRUCTION THIS DRAWING SHALL NOT BE USED FOR CONSTRUCTION UNLESS A PROFESSIONAL'S SEAL AND SIGNATURE ARE ON THE DRAWING		
PROJECT TITLE / DESCRIPTION:		
TROPICAL SHIPPING NEW OFFICES		
FACILITY LOCATION:		
TROPICAL SHIPPING L.L.C. (LEASED PLOT)		
PLOT NO. 8 EAST HOPE (H.O.V.I.C. LANDS) QUEEN'S QUARTER, ST. CROIX USVI		
DATE:		
MAY 15, 2024		
NO:	REVISION:	DATE:
1	REVIEW	5/28/24
PROJECT NUMBER:		
2421B		
DRAWING TITLE:		
PLUMBING SPECIFICATION		
SHEET NUMBER:		
P106		
SHEET	OF	
6		6

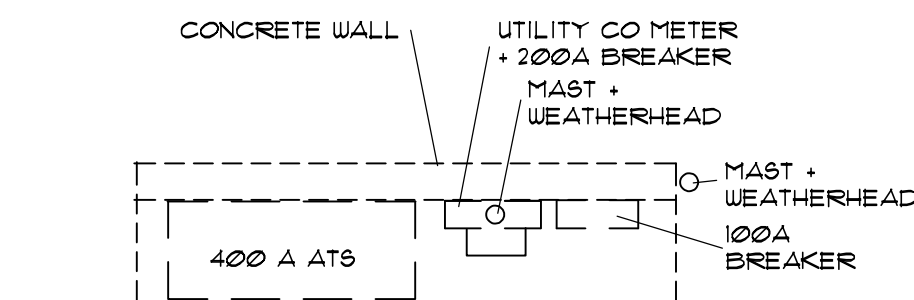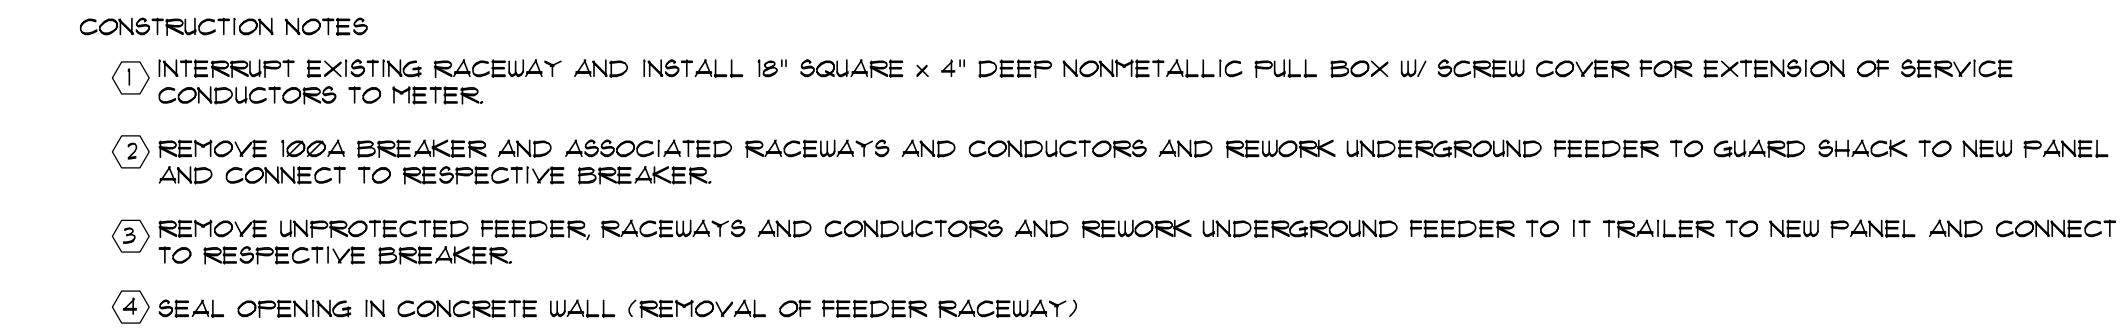

PLAN - EXISTING

DISTRIBUTION DIAGRAM

NEW BUILDING 3200 SQ' @ 6W/SQ'=20,000W.
20KW 2120-208Y = 50AMPS PROVIDE 100A
FEEDER TO BUILDING PANEL.

DESIGN DEVELOPMENT NOT FOR CONSTRUCTION

THIS DRAWING SHALL NOT BE USED FOR
CONSTRUCTION UNLESS A PROFESSIONAL'S
SEAL AND SIGNATURE ARE ON THE DRAWING

PROJECT TITLE / DESCRIPTION:
TROPICAL SHIPPING
NEW OFFICES

FACILITY LOCATION:
TROPICAL SHIPPING L.L.C.
(LEASED PLOT)

PLOT NO. 8
EAST HOPE (H.O.V.I.C. LANDS)
QUEEN'S QUARTER, ST. CROIX USVI

DATE: 5-28-24

[illegible]

PROJECT NUMBER:
22254

DRAWING TITLE:
DISTRIBUTION

SHEET NUMBER:

SHEET	OF
-------	----

FIXTURE SYMBOLS

- 

2x2 RECESSED LED FIXTURE
- 

2x4 RECESSED LED FIXTURE
- 

FIXTURE WITH BATTER POWER PACK
- 

BATTERY EMERGENCY FIXTURE
- 

EXIT FIXTURE
- 

DIRECTIONAL ARROW
- 

 
DOUBLE FACE




REFER TO FIXTURE SCHEDULE FOR CATALOG NUMBERS AND DETAILS. FIXTURE TYPE ARE TYPICAL FOR EACH SPACE.

POWER + CIRCUITING SYMBOLS

- 

PANELBOARD - FLUSH MOUNTED
- 

 CONCEALED CIRCUITING
- 

"HOMERUN" TO PANEL
- 

FLEX CONNECTION
- 

POWER + 0-10 VOLT CABLE
- 

CAT 5e CLASS 2P CABLE
- 

OUTLET / JUNCTION BOX
- 

VOICE/DATA OUTLET W/ 1" 'ER' TO HUNG CEILING SPACE AND DRAG LINE
- 

REFER TO CONSTRUCTION NOTES
- 

REFER TO DEMOLITION NOTE
- 

SYMBOLS INDICATED DASHED W/ 'E' ARE EXISTING TO REMAIN, W/ 'R' EXISTING TO BE REMOVED WITH 'ER' EXISTING REINSTALLED

WIRING DEVICE SYMBOLS

- 

DUPLEX RECEPTACLE 125 VOLT 20AMP
- 

GROUND FAULT PROTECTED RECEPTACLE 125 VOLT 20AMP
- 

RECEPTACLE MOUNTED ABOVE FINISHED FLOOR +44"
- 

POKE-THRU SYSTEMS FURNITURE FEED
- 

POKE-THRU FLOOR FITTING
- 

SINGLE POLE SWITCH 125V 20AMP
- 

OCCUPANCY SENSOR - TYPE AS NOTED
- 


REFER TO LIGHTING CONTROL SCHEDULE FOR DETAILS
- 

CARD READER DOOR ACCESS CONTROL

FIXTURES

TYPE	MANUFACTURER	CATALOG NUMBER	MOUNTING	LAMP DATA	WATTS	REMARKS
A	MAXLITE	MLFP-22 G4 18W CS CR	RECESSED	LED 3380 LUMENS	36.0	SEE NOTE 3+4
B	MAXLITE	MLFP-24 G4 27W CS CR	RECESSED	LED 3100 LUMENS	45.0	SEE NOTE 3+4
C	LITHONIA	LDN4SQ 35/20 L04 AR LSS TRW MV G210	RECESSED	LED 2006 LUMENS	22.5	
D	MARK	S2PD (REFER TO NOTE1)	SUSPENDED	LED 1200 LUMENS	40.0	
E	LITHONIA	EXT-RW-SD	UNIVERSAL	LED	1.5	SEE NOTE 1
F	GM LIGHTING	TGB 4 35 G2	RECESSED	LED 2600 LUMENS	20.0	SEE NOTE 2
G	WAC	PD 68909 T24 BN	SUSPENDED	LED 1718 LUMENS	16.0	
H	LITHONIA	ELM2LF UVOLT LTP BAA RTKIT	SURFACE	LED 220 LUMENS	2.4	
J						

REMARKS
1-PROVIDE DOUBLE FACE UNITS (DF) AND DIRECTIONAL ARROWS ' ' AS REQUIRED BY LIGHTING PLAN.
2-POWER SUPPLY 'TGB 4 PS 60' AND EXTENSION CORD 'TGB C EXT 12'.
3-FIXTURE WITH AN 'P' SHALL HAVE AN 'NN-RTPSW' CONTROL - FIXTURE WITH AN 'C' SHALL HAVE AN 'NN-RTW' CONTROL. INDIVIDUAL FIXTURES SHALL HAVE 'CN-RTPSW' CONTROL. PROVIDE 'CN-REMOTE' FOR FIXTURE PROGRAMMING AND PROVIDE MANUFACTURER'S REP FOR COMMISSIONING OF LIGHTING CONTROL SYSTEM.
4-FIXTURE WITH 'EM' SHALL BE PROVIDED MAXLITE 'EM' EMERGENCY BATTERY PACK.

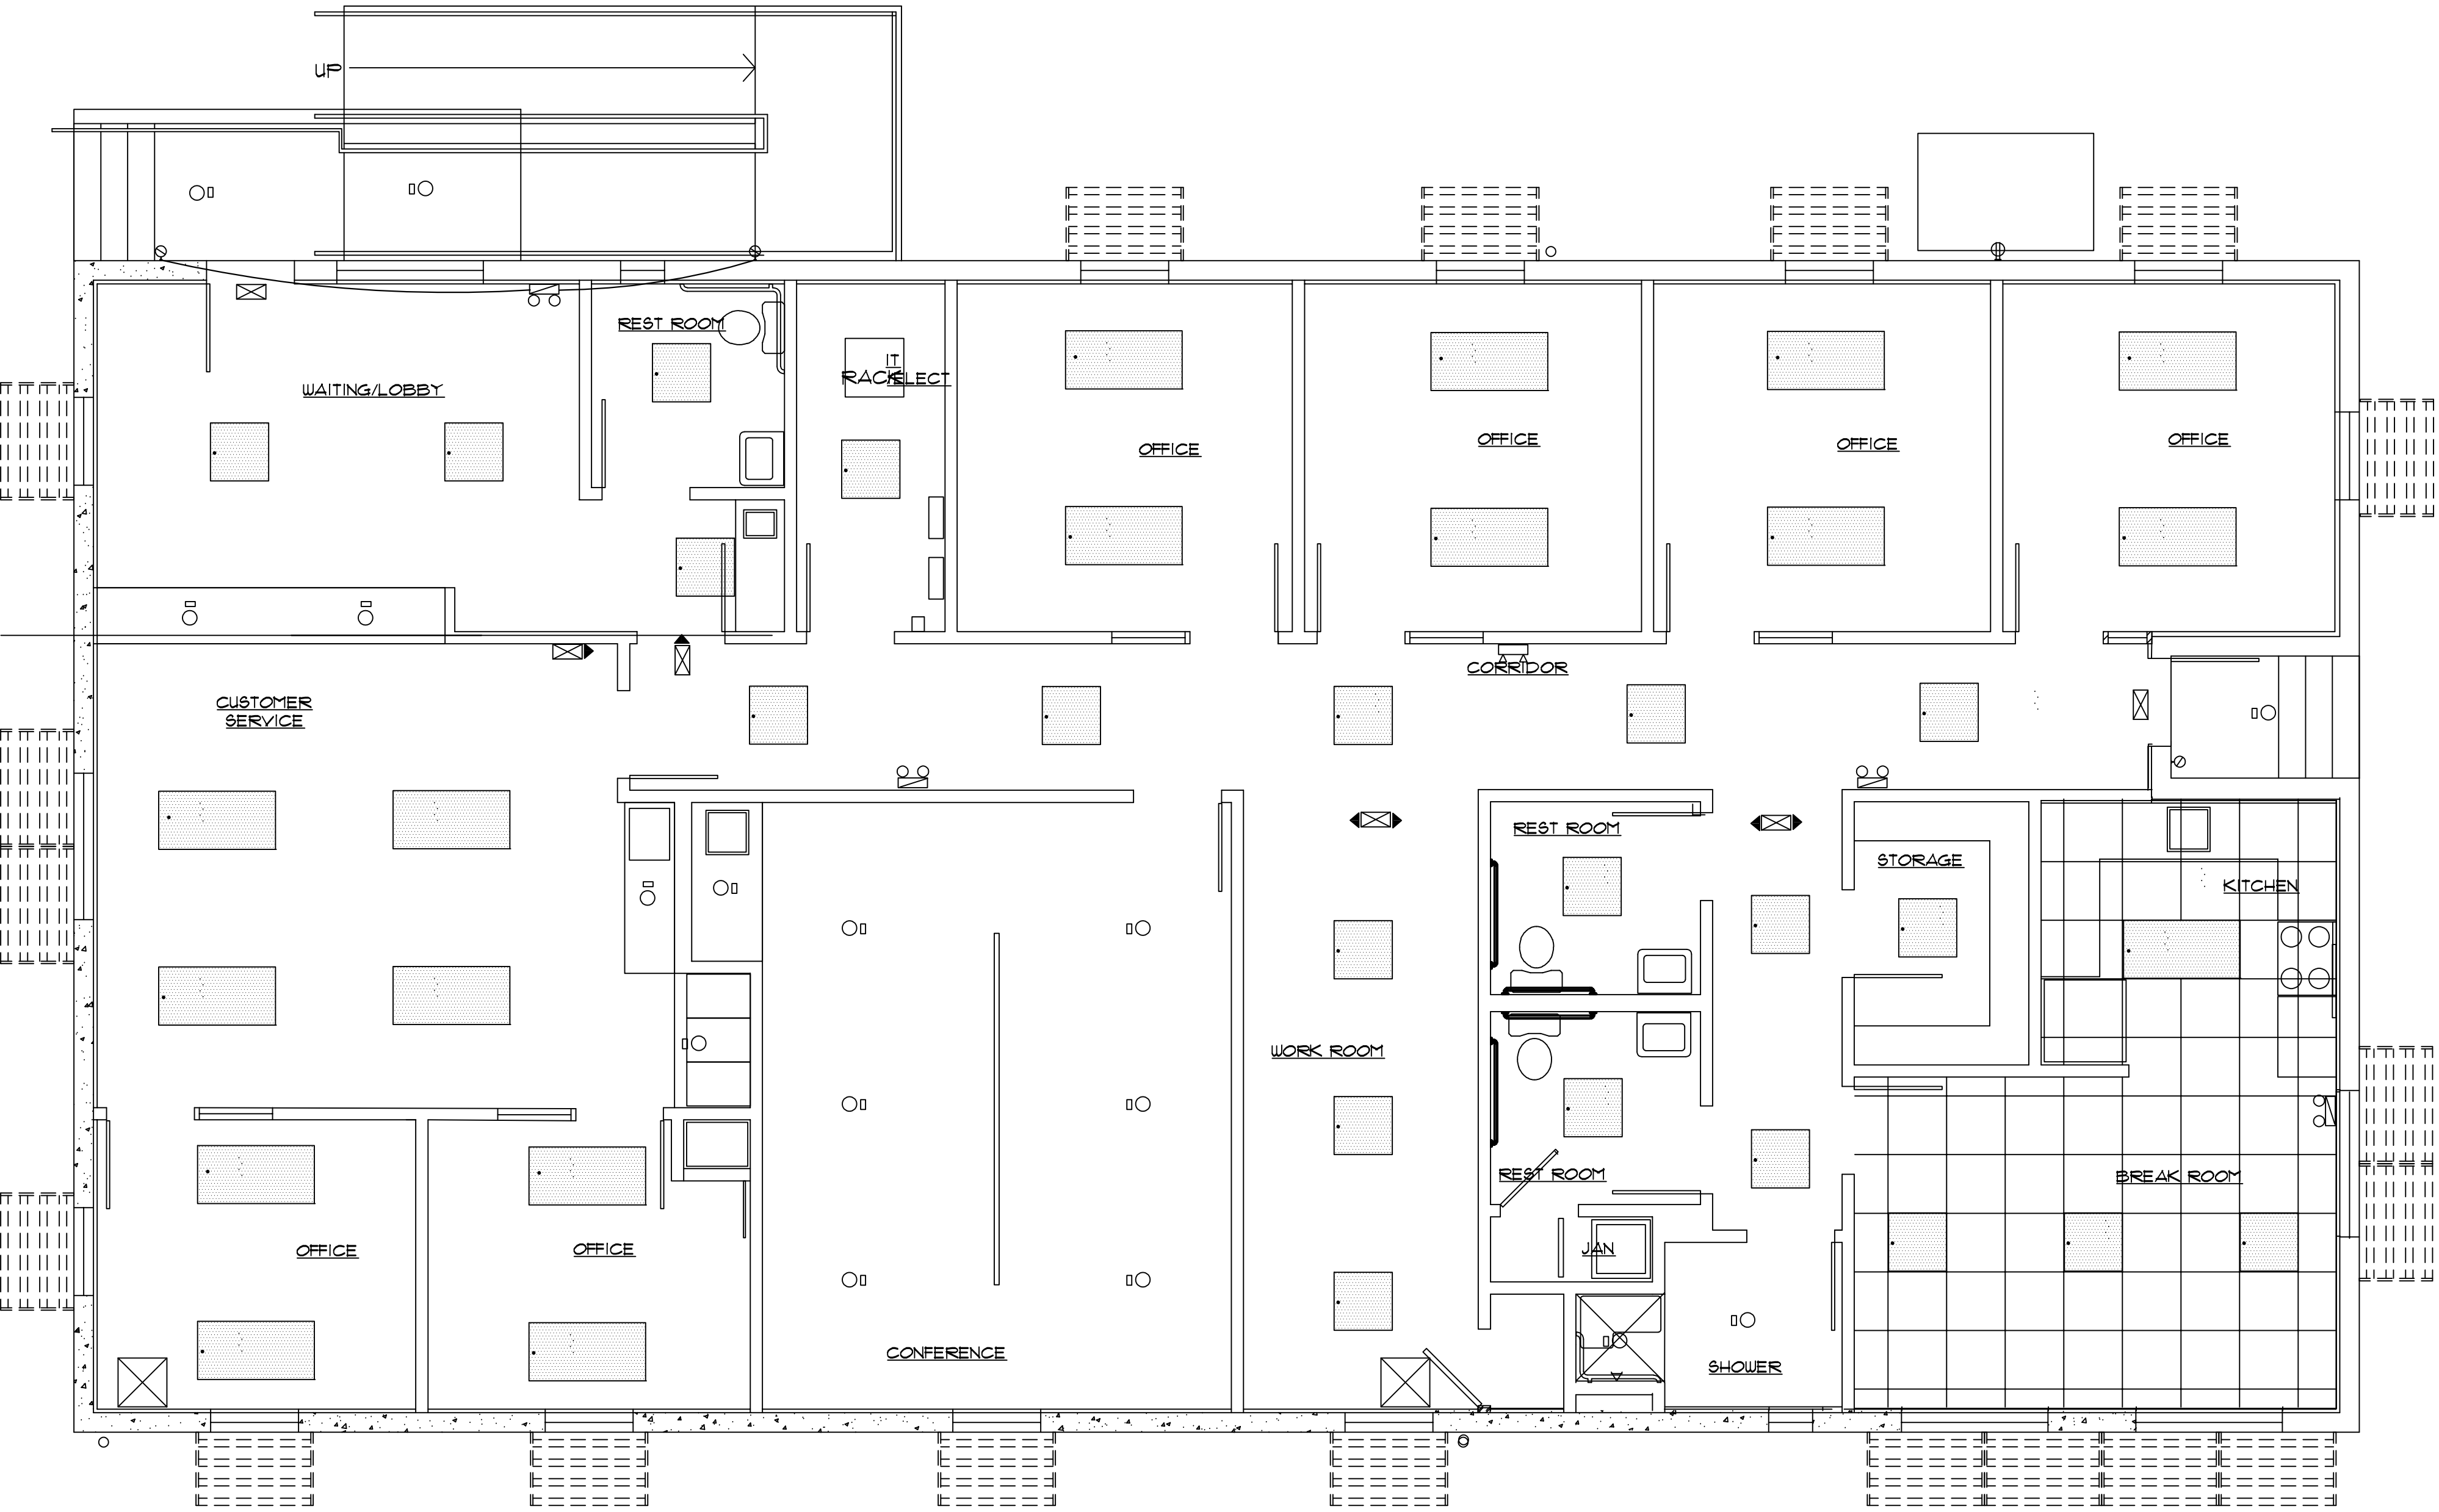

DESIGN DEVELOPMENT
NOT FOR CONSTRUCTION

L1 LIGHTING PLAN

1/4"



3000 ORANGE GROVE, CHRISTIANSTED
ST. CROIX, U.S. VIRGIN ISLANDS 00820
PHONE: (340) 718-1222 FAX: (340) 718-4178
WEBSITE: WWW.BENTONCON.COM

ARCHITECT



95 COMPANY STREET, SUITE B, CHRISTIANSTED
ST. CROIX, U.S.VI. 00820
NJ PHONE: (609) 921-0861 NJ FAX: (609) 921-8326

MEP ENGINEER



T.D. ENGINEERING ASSOCIATES, INC.
2 Hancock Drive, West Milford, N.J. 07480
Certificate of Authorization 240A27944000
Phone 973-208-0054
Fax 973-208-0851

STRUCTURAL ENGINEER

HARRISON HAMNETT, P.C.
40 Knowles Street
Pennington, New Jersey 08534
Office (609) 818-1808
Fax (609) 818-1809

OWNER



PROFESSIONAL SEAL:

THIS DRAWING SHALL NOT BE USED FOR
CONSTRUCTION UNLESS A PROFESSIONAL'S
SEAL AND SIGNATURE ARE ON THE DRAWING

PROJECT TITLE / DESCRIPTION:
TROPICAL SHIPPING
NEW OFFICES

FACILITY LOCATION:
TROPICAL SHIPPING L.L.C.
(LEASED PLOT)

PLOT NO. 8
EAST HOPE (H.O.V.I.C. LANDS)
QUEEN'S QUARTER, ST. CROIX USVI

DATE:
5-28-24


NO.	REVISION:	DATE:

PROJECT NUMBER:
22254

DRAWING TITLE:
LIGHTING PLAN
FIXTURE SCHED

SHEET NUMBER:
E102

SHEET OF

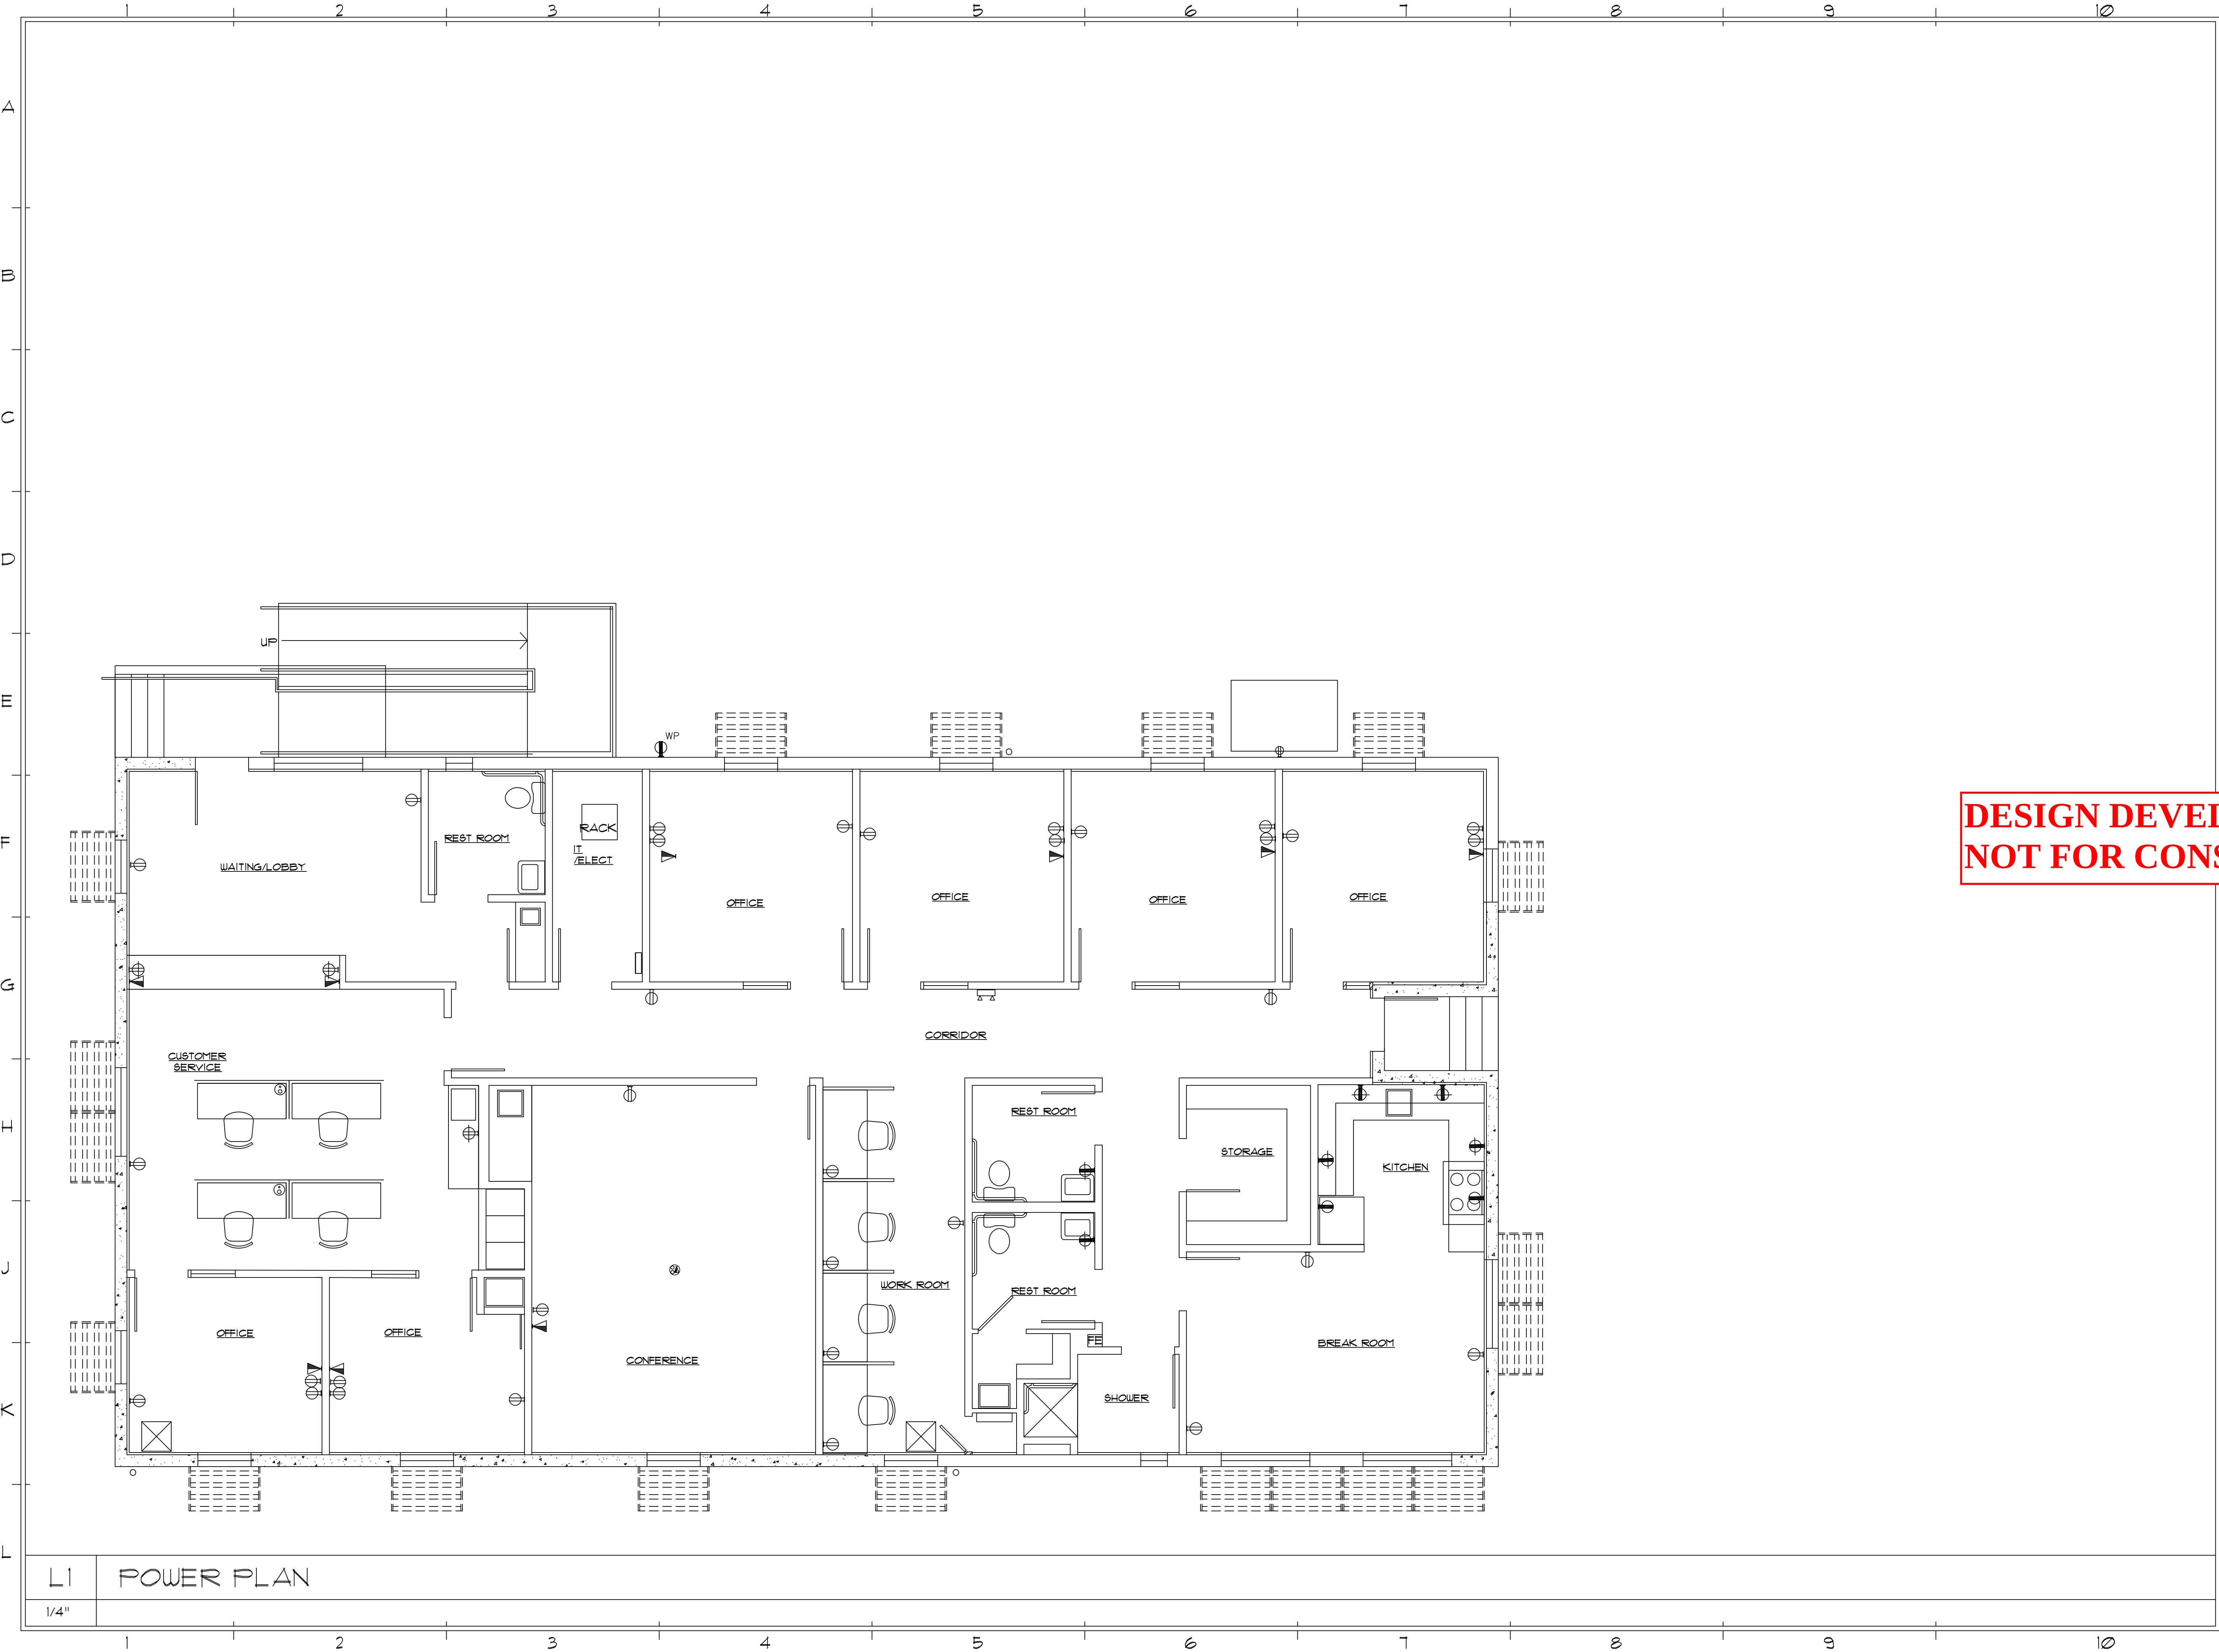

BENTON
CONSTRUCTION, LLC
3000 ORANGE GROVE, CHRISTIANSTED
ST. CROIX, U.S. VIRGIN ISLANDS 00820
PHONE: (340) 718-1222 FAX: (340) 718-4178
WEBSITE: WWW.BENTON.COM

ARCHITECT

SILVERBERG
ASSOCIATES VI, P.C.
ARCHITECTS
95 COMPANY STREET, SUITE B, CHRISTIANSTED
ST. CROIX, U.S.VI. 00820
NJ PHONE: (609) 921-8661 NJ FAX: (609) 921-8326

MEP ENGINEER



T.J.D. ENGINEERING ASSOCIATES, INC.
2 Hancock Drive, West Milford, N.J. 07480
Certificate of Authorization 24GA27944000
Phone 973-208-0054
Fax 973-208-0851

OWNER

Tropical
SHIPPING

PROFESSIONAL SEAL:

**DESIGN DEVELOPMENT
NOT FOR CONSTRUCTION**

THIS DRAWING SHALL NOT BE USED FOR
CONSTRUCTION UNLESS A PROFESSIONAL'S
SEAL AND SIGNATURE ARE ON THE DRAWING

PROJECT TITLE / DESCRIPTION:
**TROPICAL SHIPPING
NEW OFFICES**

FACILITY LOCATION:
**TROPICAL SHIPPING L.L.C.
(LEASED PLOT)**

PLOT NO. 8
EAST HOPE (H.O.V.I.C. LANDS)
QUEEN'S QUARTER, ST. CROIX USVI

DATE:
5-28-24

NO.	REVISION:	DATE:

PROJECT NUMBER:
22254

DRAWING TITLE:
**POWER PLAN
SCHEDULES**

SHEET NUMBER:

E103

SHEET OF